


R:\wopous 1:57:33 PM 12/12/2018 Projects\18-018.01 US 550 S Connection D-B - CDDT R-5\22420\Hydraulics\Drawings\22420HYDR_Plan04.dgn
 12/12/2018 CDDT-DebraPrinter_V81.plt.ctb CDDT V81 CLR-UTL.tbl

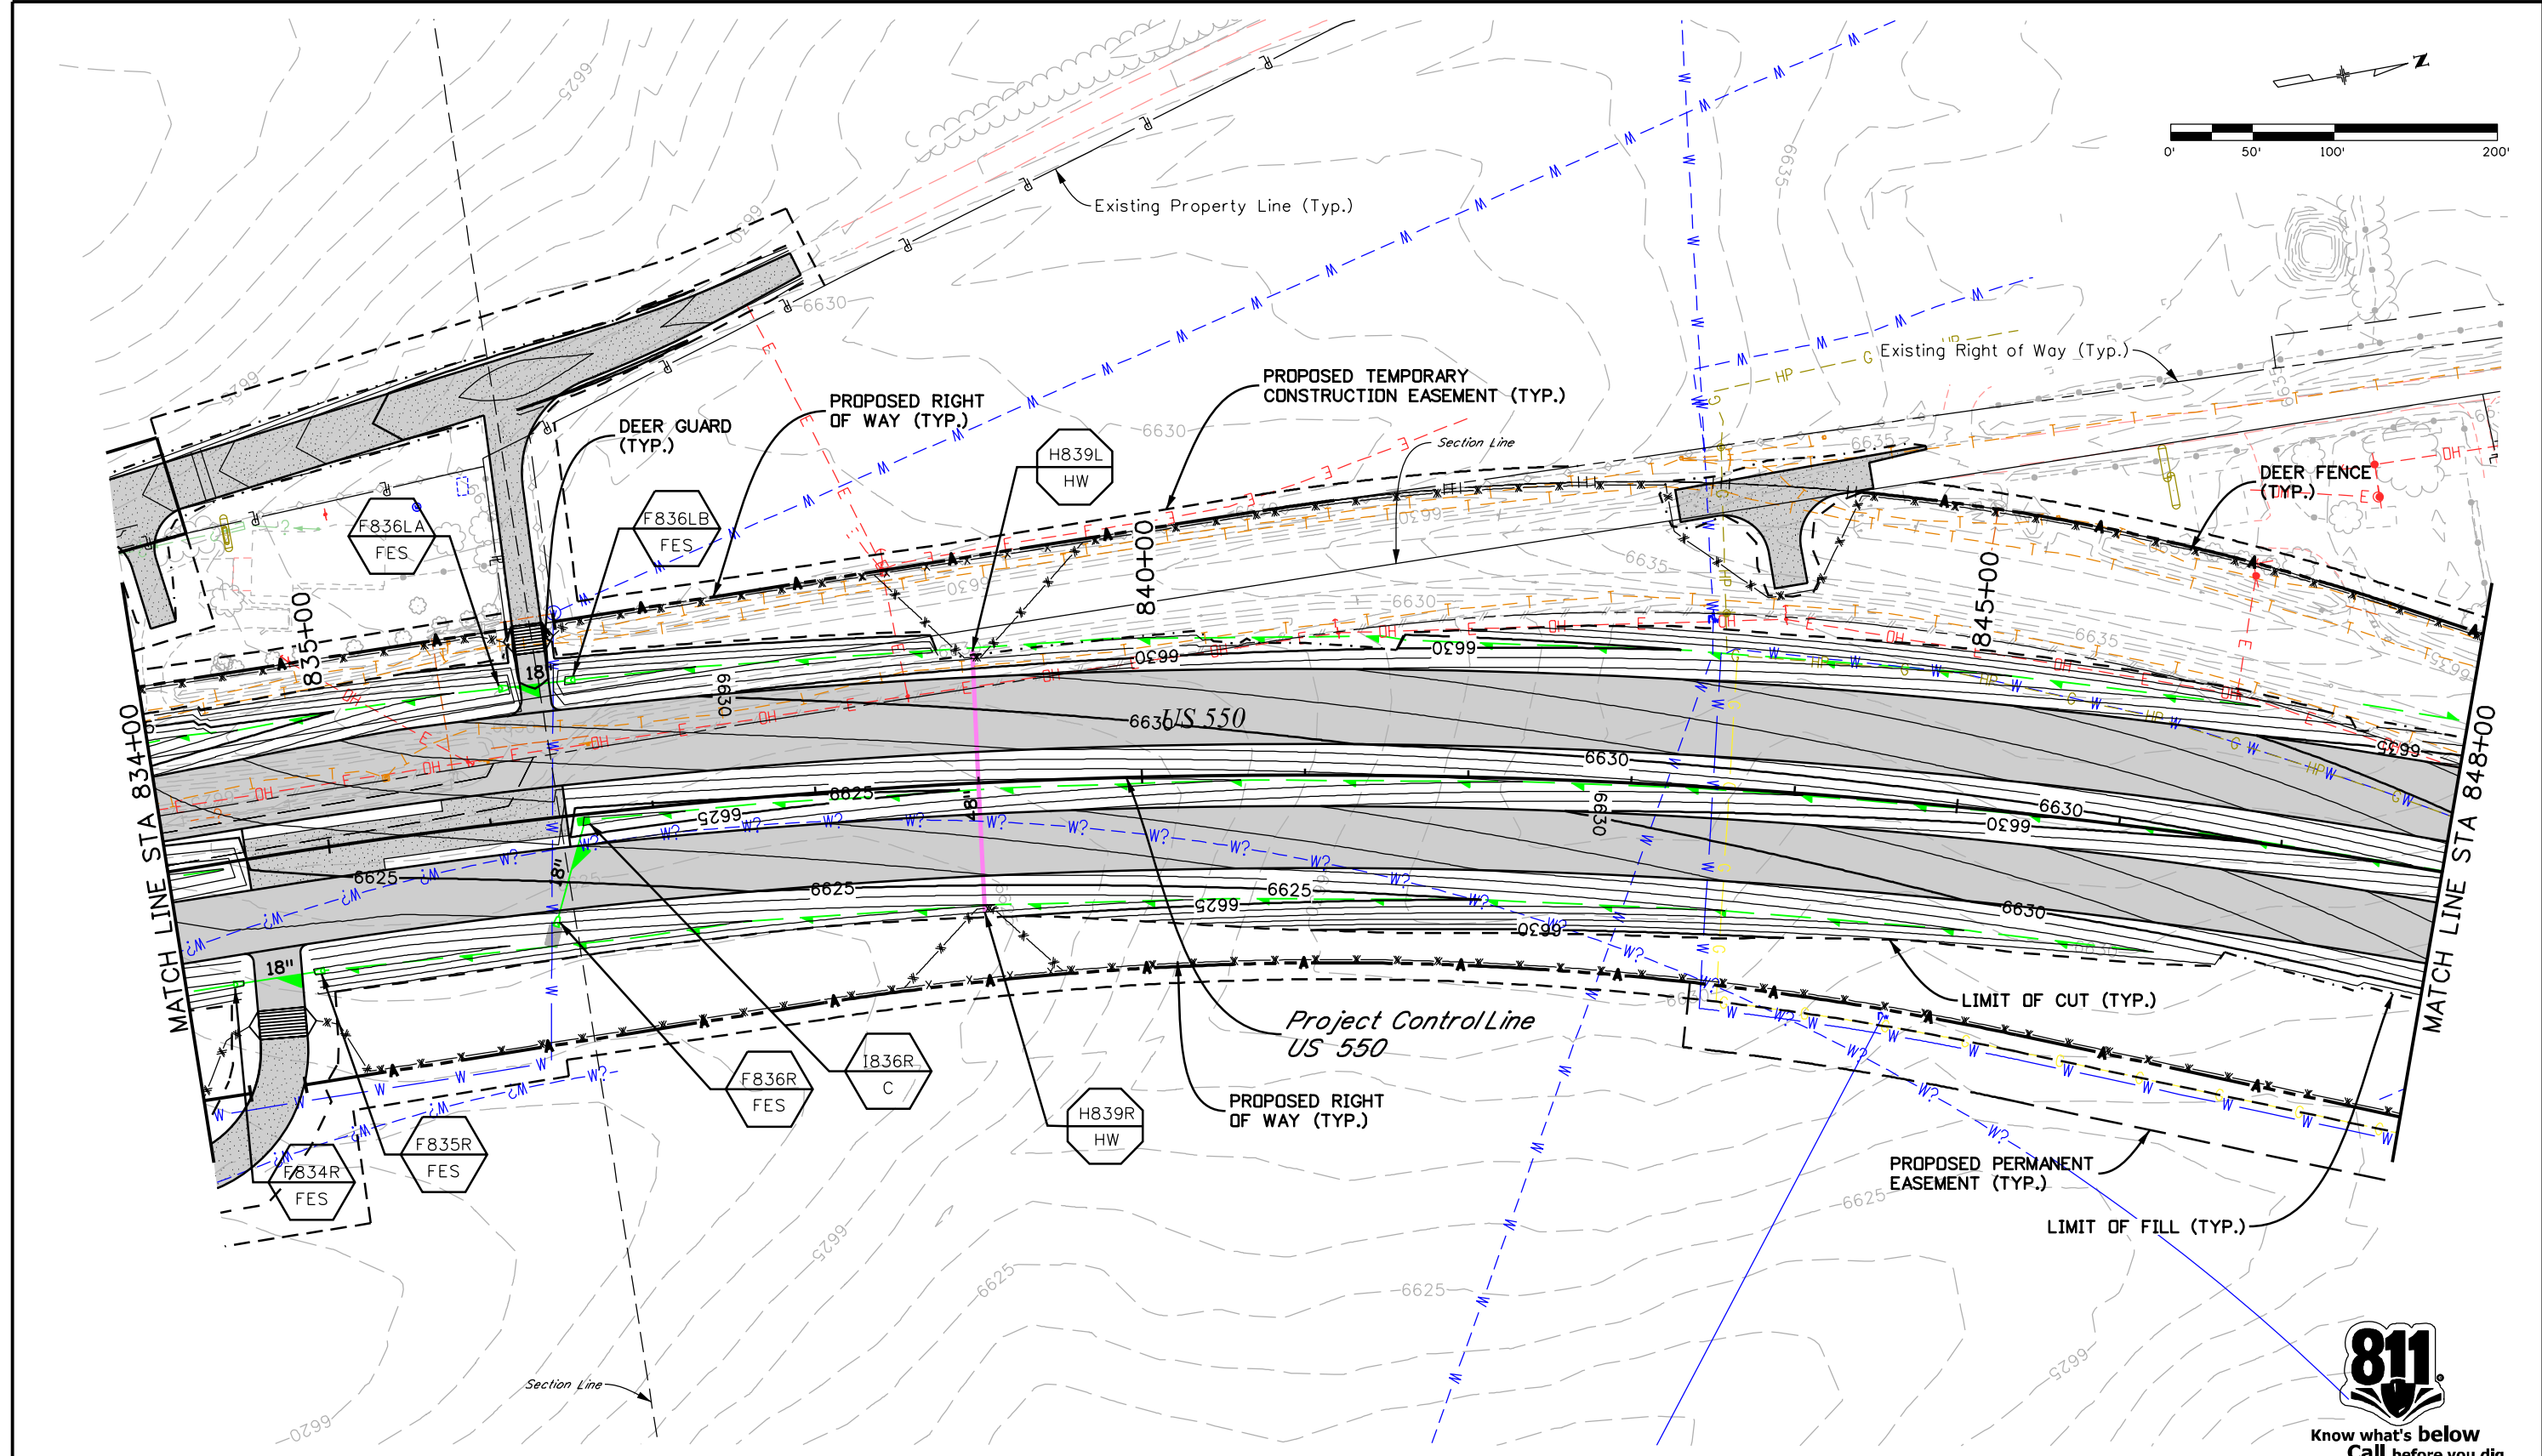

Print Date: 12/12/2018
Drawing File Name: 22420HYDR_Plan04.dgn
Horiz. Scale: 1:100 Vert. Scale: As Noted
Unit Information Unit Leader Initials
MULLER ENGINEERING COMPANY

Sheet Revisions		
Date:	Comments	Init.

Colorado Department of Transportation



 3803 North Main Avenue
 Suite 200
 Durango, CO 81301
 Phone: 970-385-1440 FAX: 970-385-8365
Region 5 **DRV**

As Constructed
No Revisions:
Revised:
Void:

US 550 DRAINAGE PLAN			
STA. 834+00 TO STA. 848+00			
Designer:	CHH	Structure	
Detailer:	LMR	Numbers	
Sheet Subset:	DRAINAGE	Subset Sheets:	4 of 19

Project No./Code
Project Number
22420
Sheet Number

R:\woprus\157141.PM\2018\Projects\18-018.01.US.550.S.Connection.D-B - CDDT - R-5\22420\Hydraulics\Drawings\22420HYDR_Plan05.dgn
 12/12/2018 1:57:41 PM CDDT-DebraPrinter-V8i.plt cddt V8i CLR-UTL.tbl

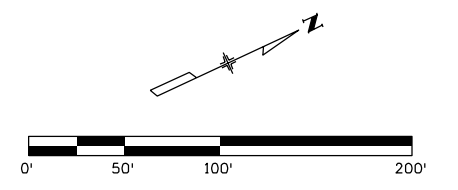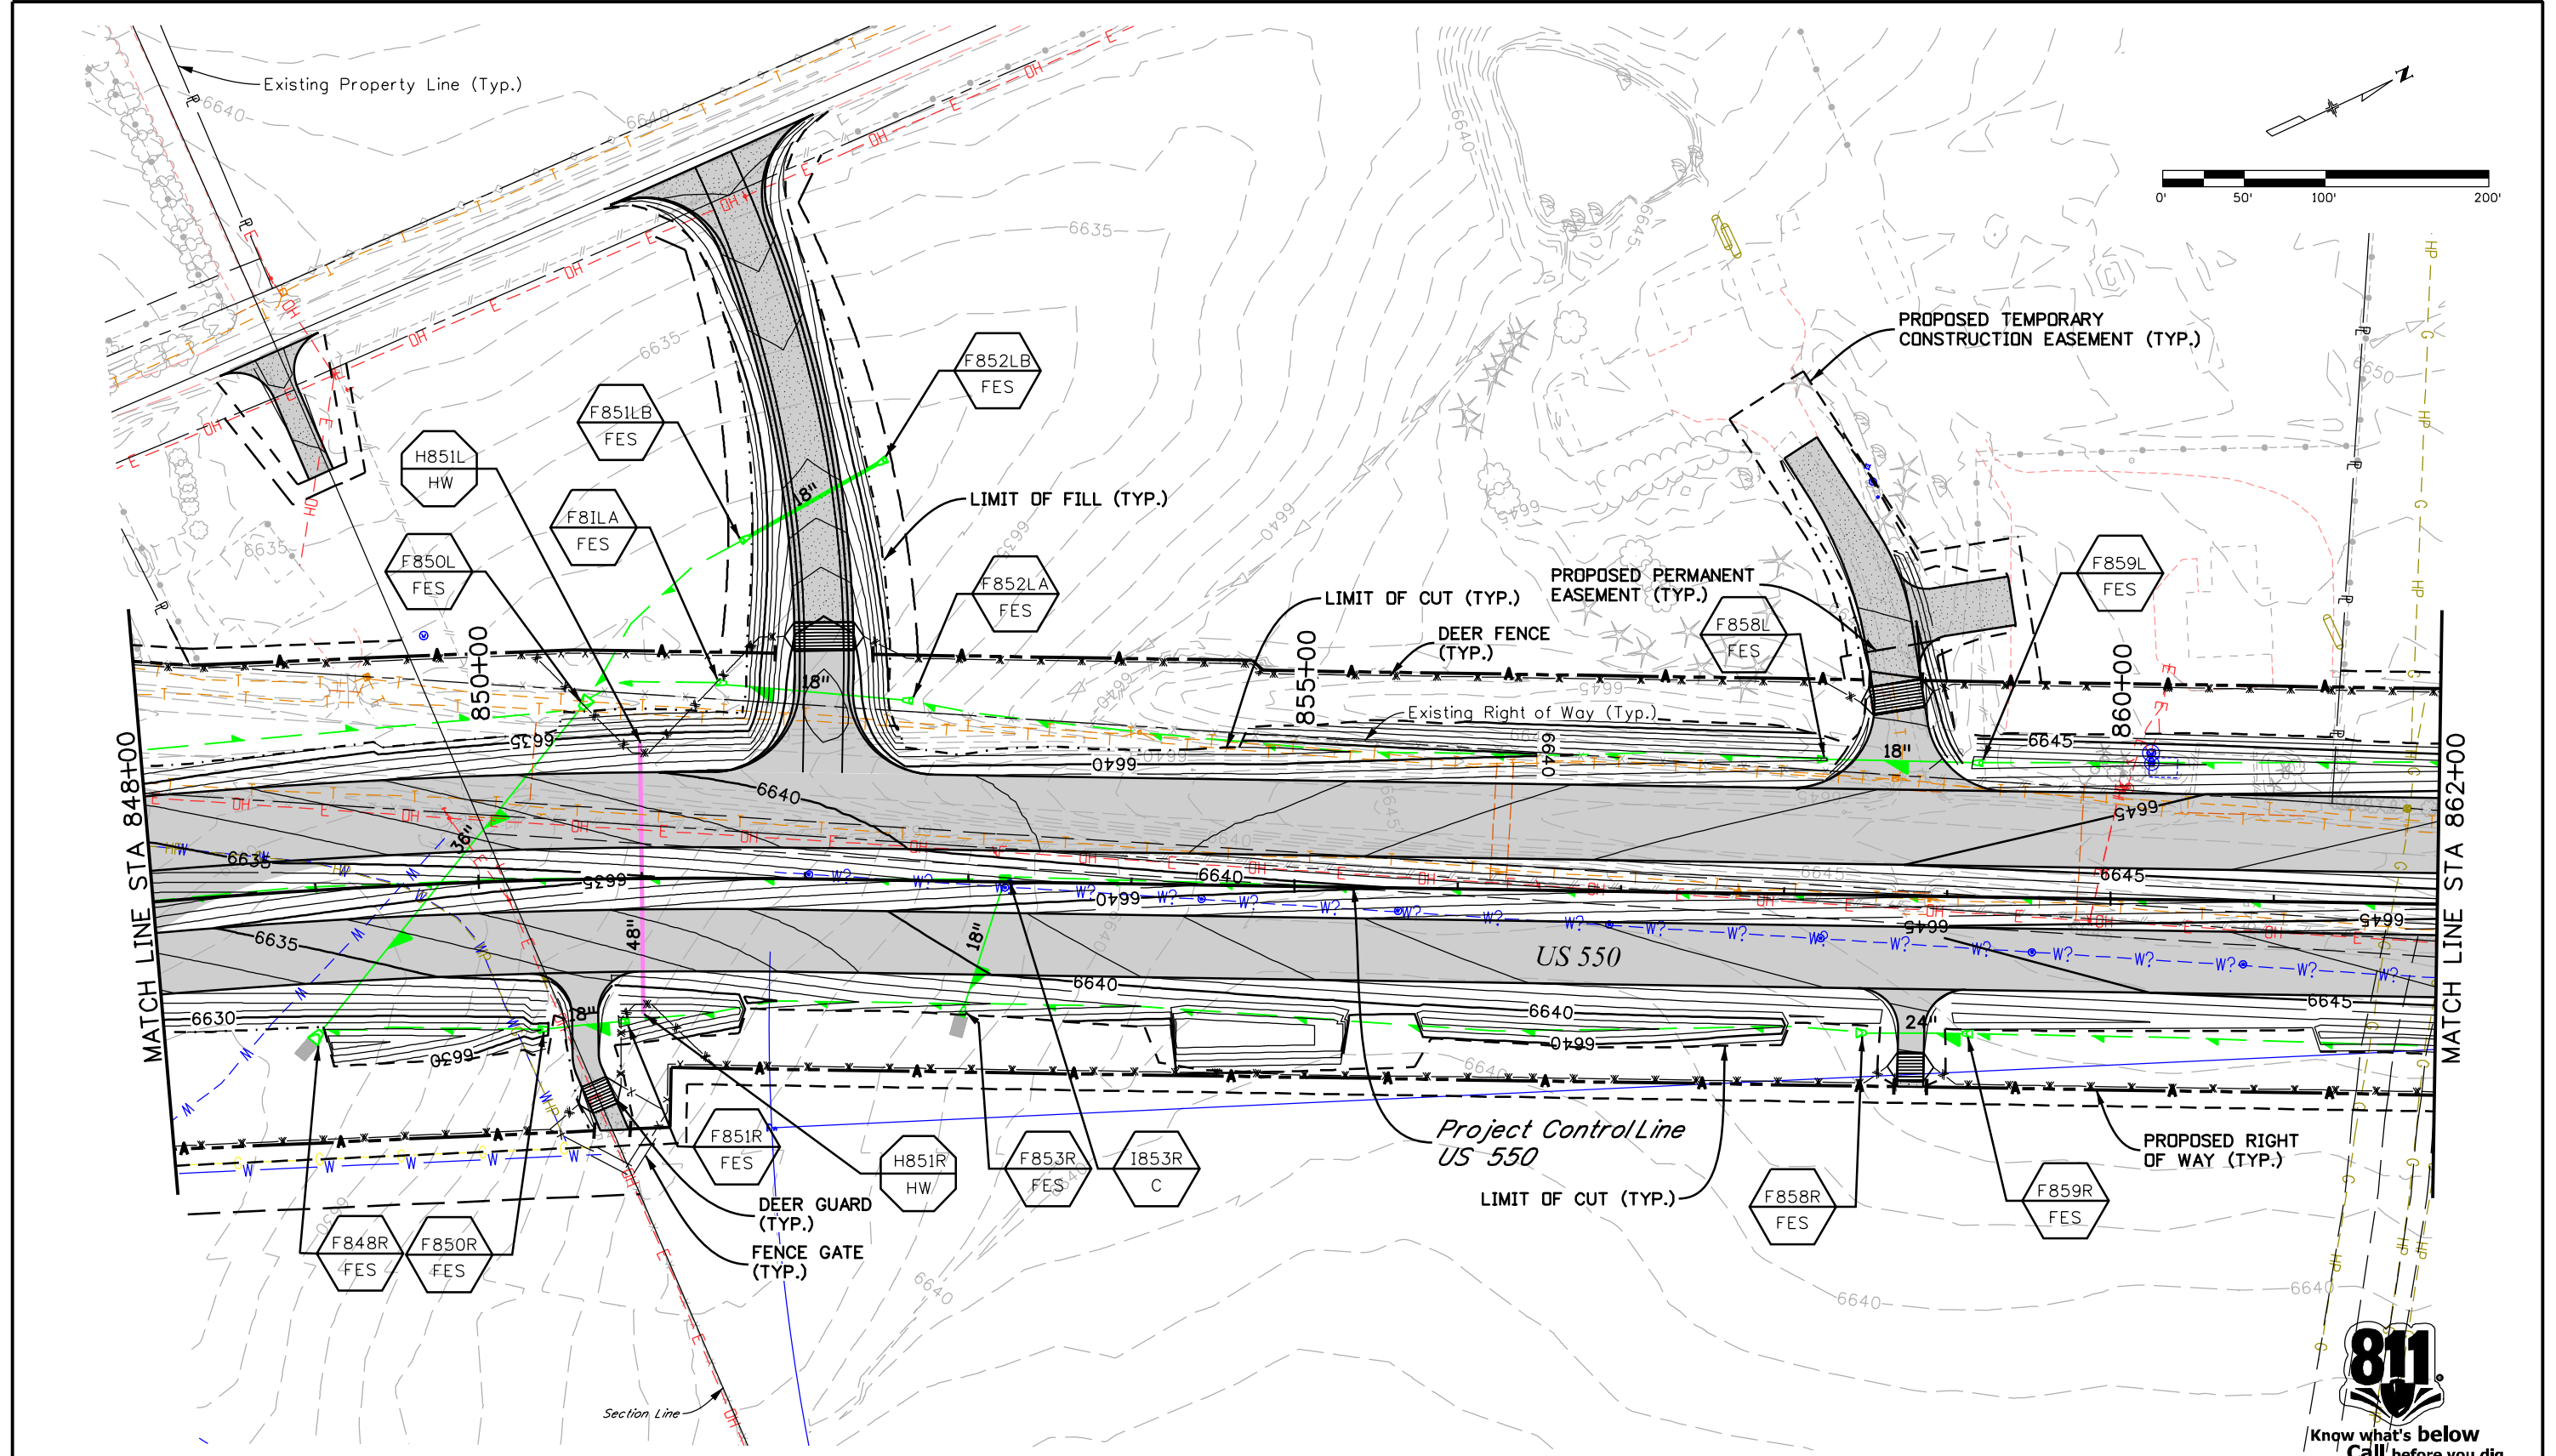

Print Date: 12/12/2018
Drawing File Name: 22420HYDR_Plan05.dgn
Horiz. Scale: 1:100 Vert. Scale: As Noted
Unit Information Unit Leader Initials
MULLER ENGINEERING COMPANY

Sheet Revisions		
Date:	Comments	Init.



Colorado Department of Transportation
 3803 North Main Avenue
 Suite 200
 Durango, CO 81301
 Phone: 970-385-1440 FAX: 970-385-8365
Region 5 **DRV**

As Constructed
No Revisions:
Revised:
Void:

US 550 DRAINAGE PLAN			
STA. 848+00 TO STA. 862+00			
Designer:	CHH	Structure	
Detailer:	LMR	Numbers	
Sheet Subset:	DRAINAGE	Subset Sheets:	5 of 19

Project No./Code
Project Number
22420
Sheet Number

R:\wopous 1:57:49 PM 12/12/2018 Projects\18-018.01 US 550 S Connection D-B - CDDT R-5\22420\Hydraulics\Drawings\22420HYDR_Plan06.dgn
 12/12/2018 CDDT-DePaulPrinter_V81.plt.ctb CDDT V81 CLR-UTL.tbl

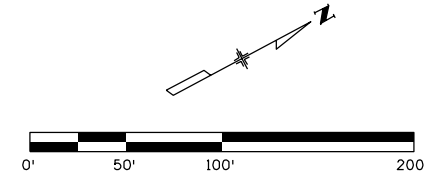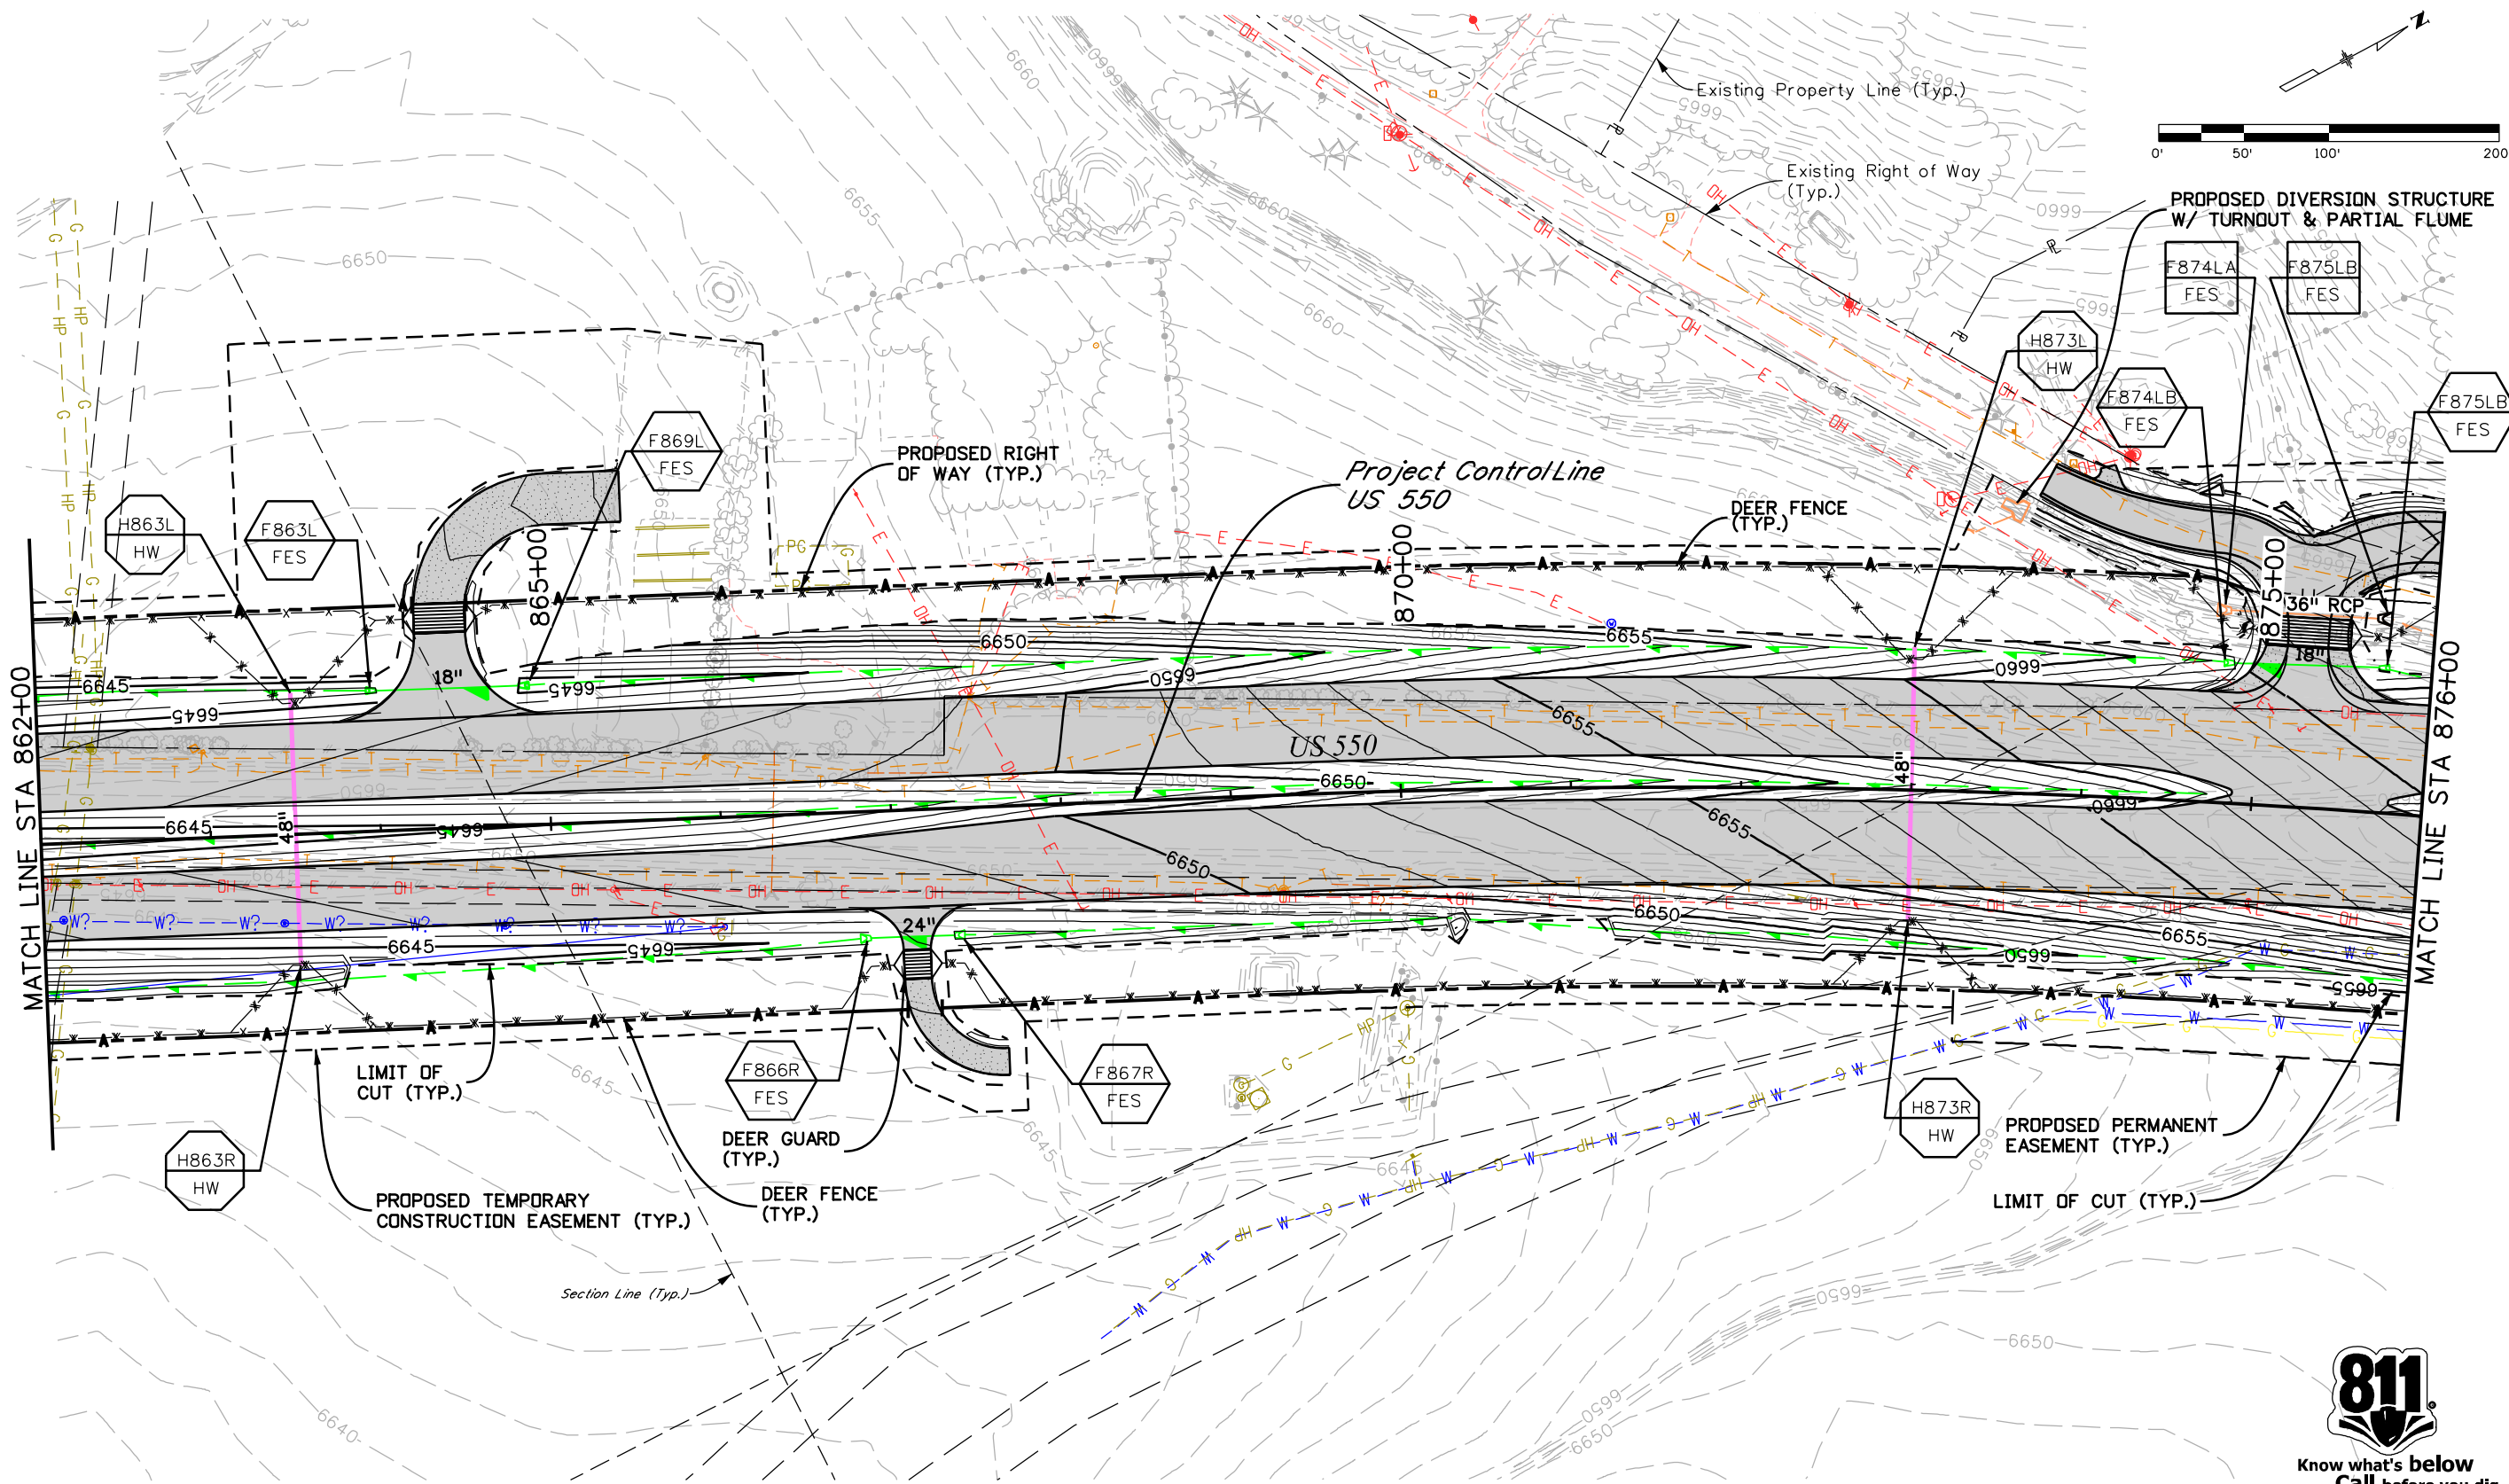

Print Date: 12/12/2018	
Drawing File Name: 22420HYDR_Plan06.dgn	
Horiz. Scale: 1:100	Vert. Scale: As Noted
Unit Information	Unit Leader Initials
MULLER ENGINEERING COMPANY	

Sheet Revisions		
Date:	Comments	Init.


Colorado Department of Transportation
 3803 North Main Avenue
 Suite 200
 Durango, CO 81301
 Phone: 970-385-1440 FAX: 970-385-8365
Region 5 **DRV**

As Constructed
No Revisions:
Revised:
Void:

US 550 DRAINAGE PLAN STA. 862+00 TO STA. 876+00			
Designer:	CHH	Structure	
Detailer:	LMR	Numbers	
Sheet Subset:	DRAINAGE	Subset Sheets:	6 of 19

Project No./Code
Project Number
22420
Sheet Number



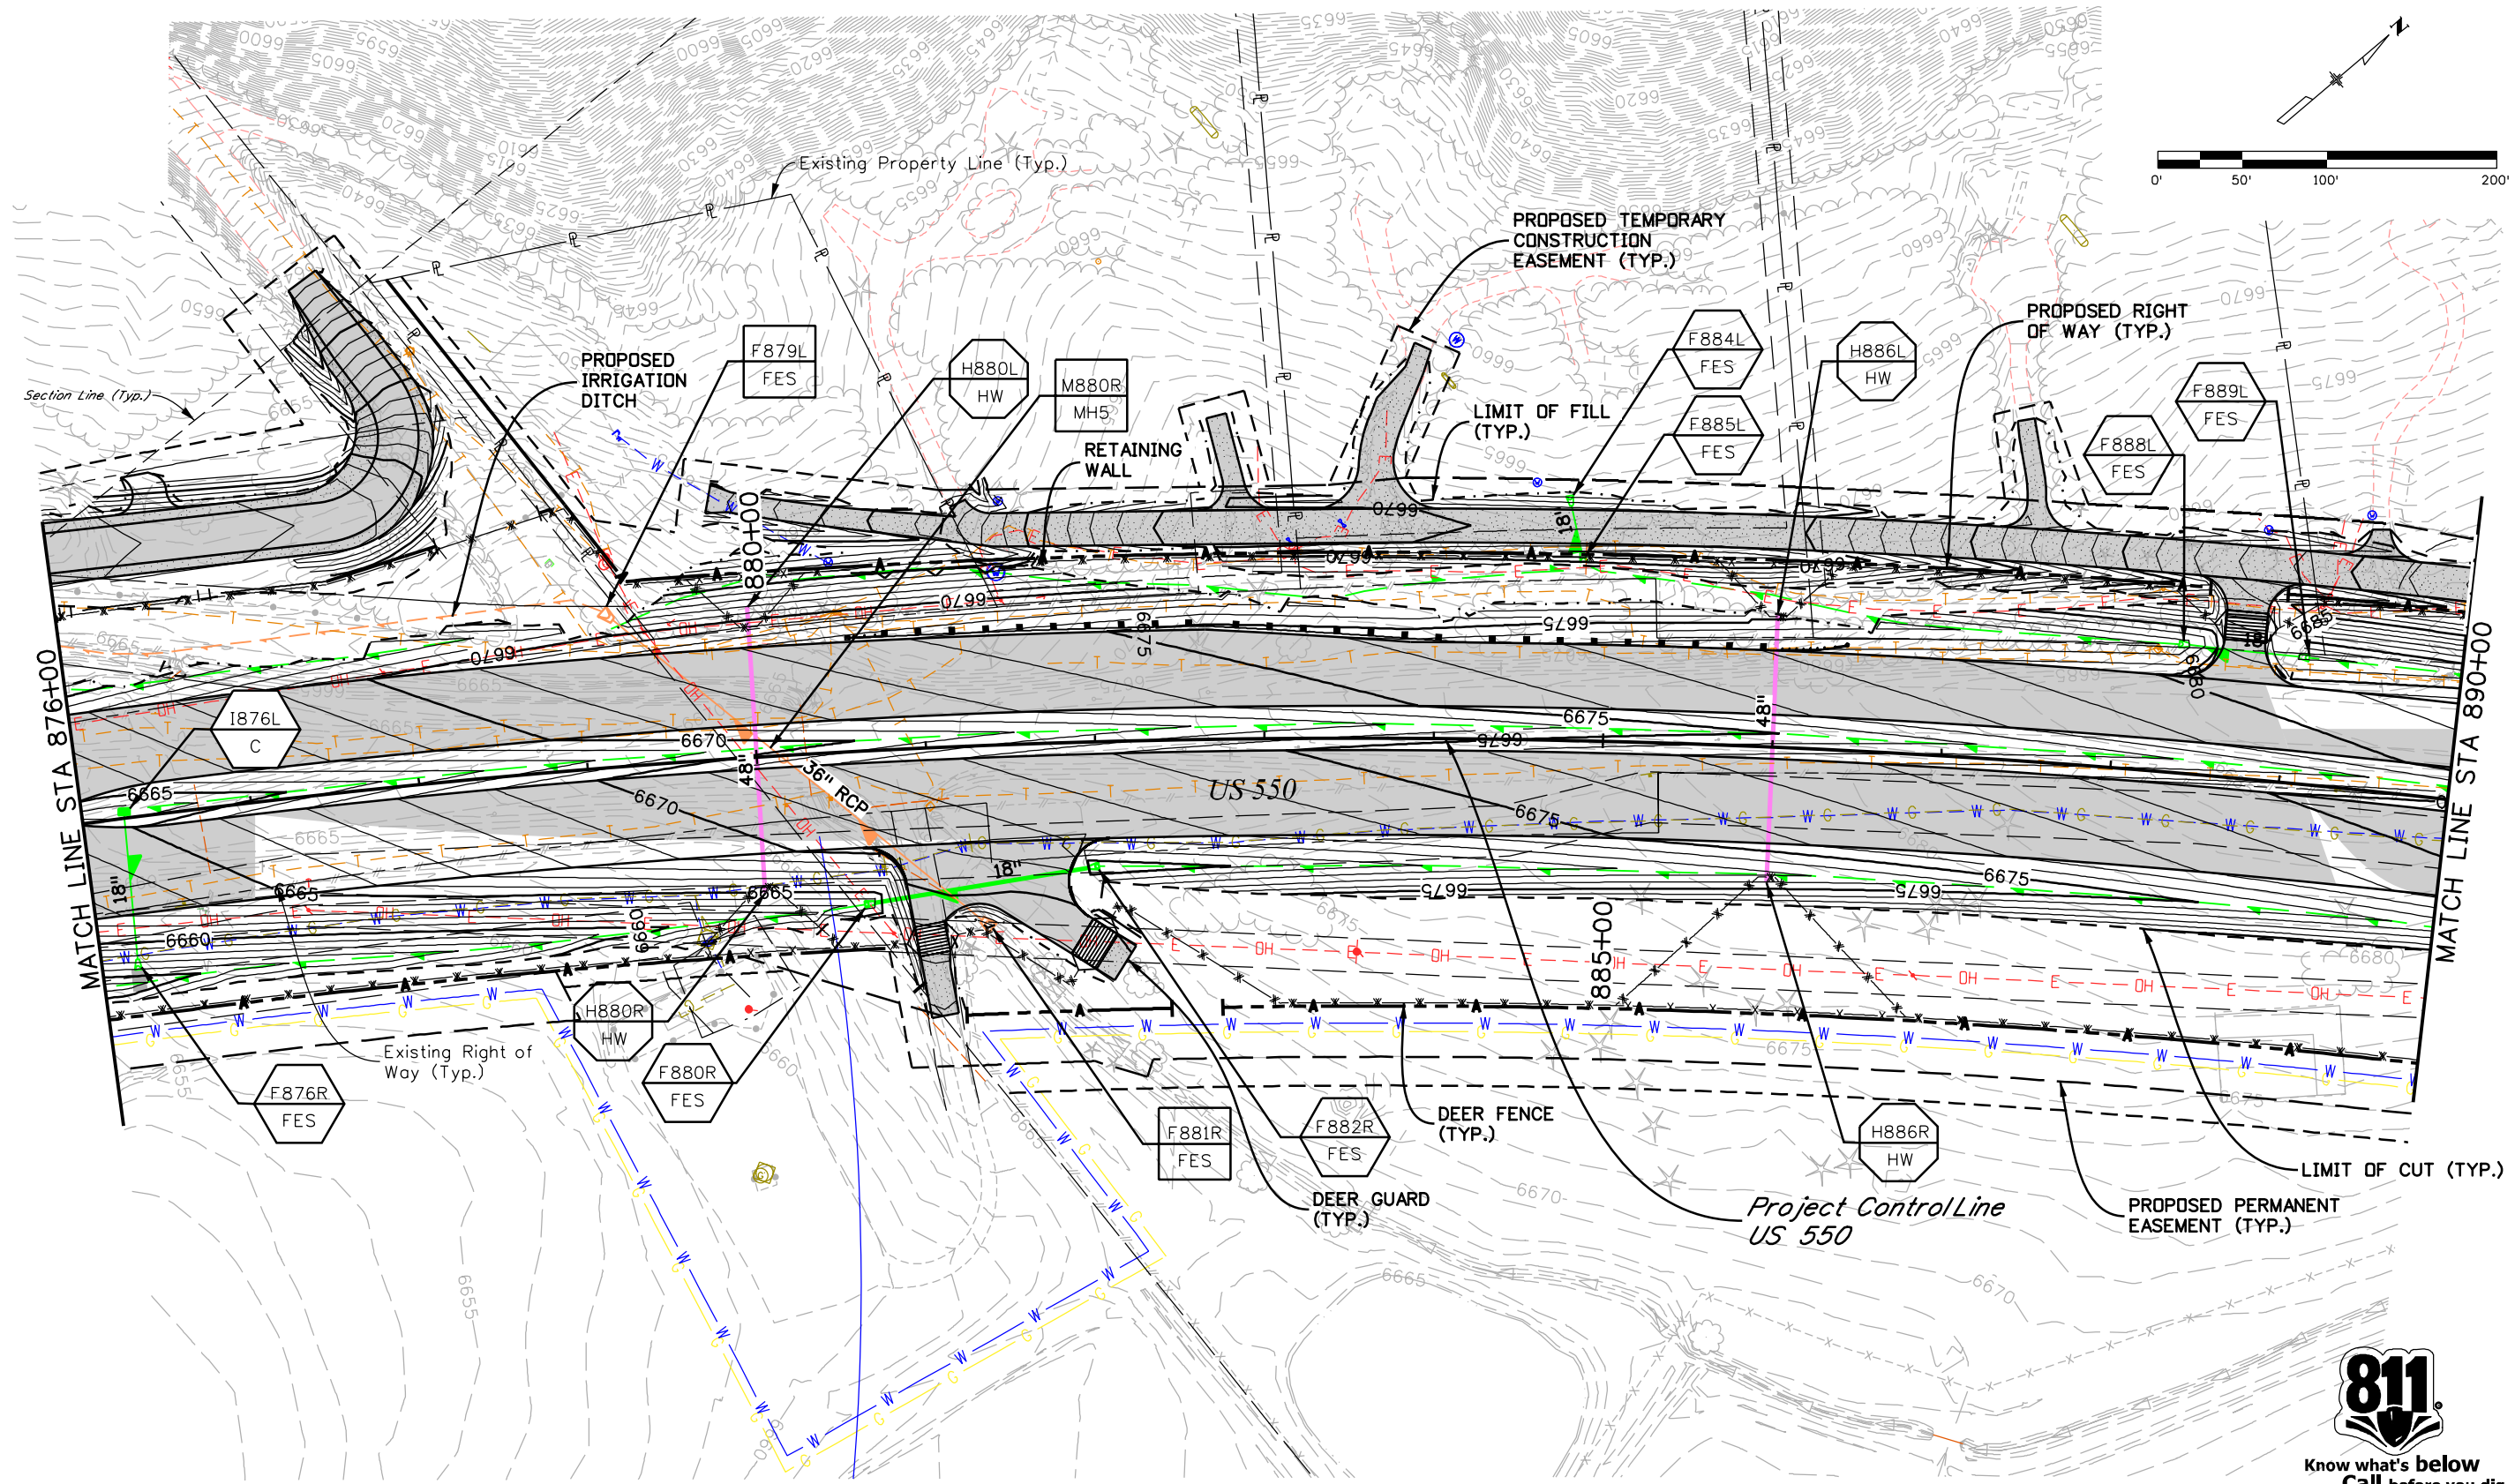

R:\wopous 1:57:57 PM 12/12/2018 Projects\18-018.01 US 550 S Connection D-B - CDDT R-5\22420\Hydraulics Drawings\22420HYDR_Plan07.dgn
 12/12/2018 CDDT-DebraPrinter_V81.plt.ctb CDDT V81 CLR-UTL.tbl



Know what's below
Call before you dig.

Print Date: 12/12/2018	
Drawing File Name: 22420HYDR_Plan07.dgn	
Horiz. Scale: 1:100	Vert. Scale: As Noted
Unit Information	Unit Leader Initials

Sheet Revisions		
Date:	Comments	Init.
0000		

Colorado Department of Transportation
 3803 North Main Avenue
 Suite 200
 Durango, CO 81301
 Phone: 970-385-1440 FAX: 970-385-8365


Region 5 **DRV**

As Constructed
No Revisions:
Revised:
Void:

US 550 DRAINAGE PLAN			
STA. 876+00 TO STA. 890+00			
Designer:	CHH	Structure	
Detailer:	LMR	Numbers	
Sheet Subset:	DRAINAGE	Subset Sheets:	7 of 19

Project No./Code
Project Number
22420
Sheet Number

P:\2018 Projects\18-018.01 US 550 S Connection D-B - CDDT R-5\22420\Hydraulics\Drawings\22420HYDR_Plan08.dgn
 12/12/2018 CDDT-DebraPrinter_V81.pctc CDDT V81 CLR-UTL.tbl

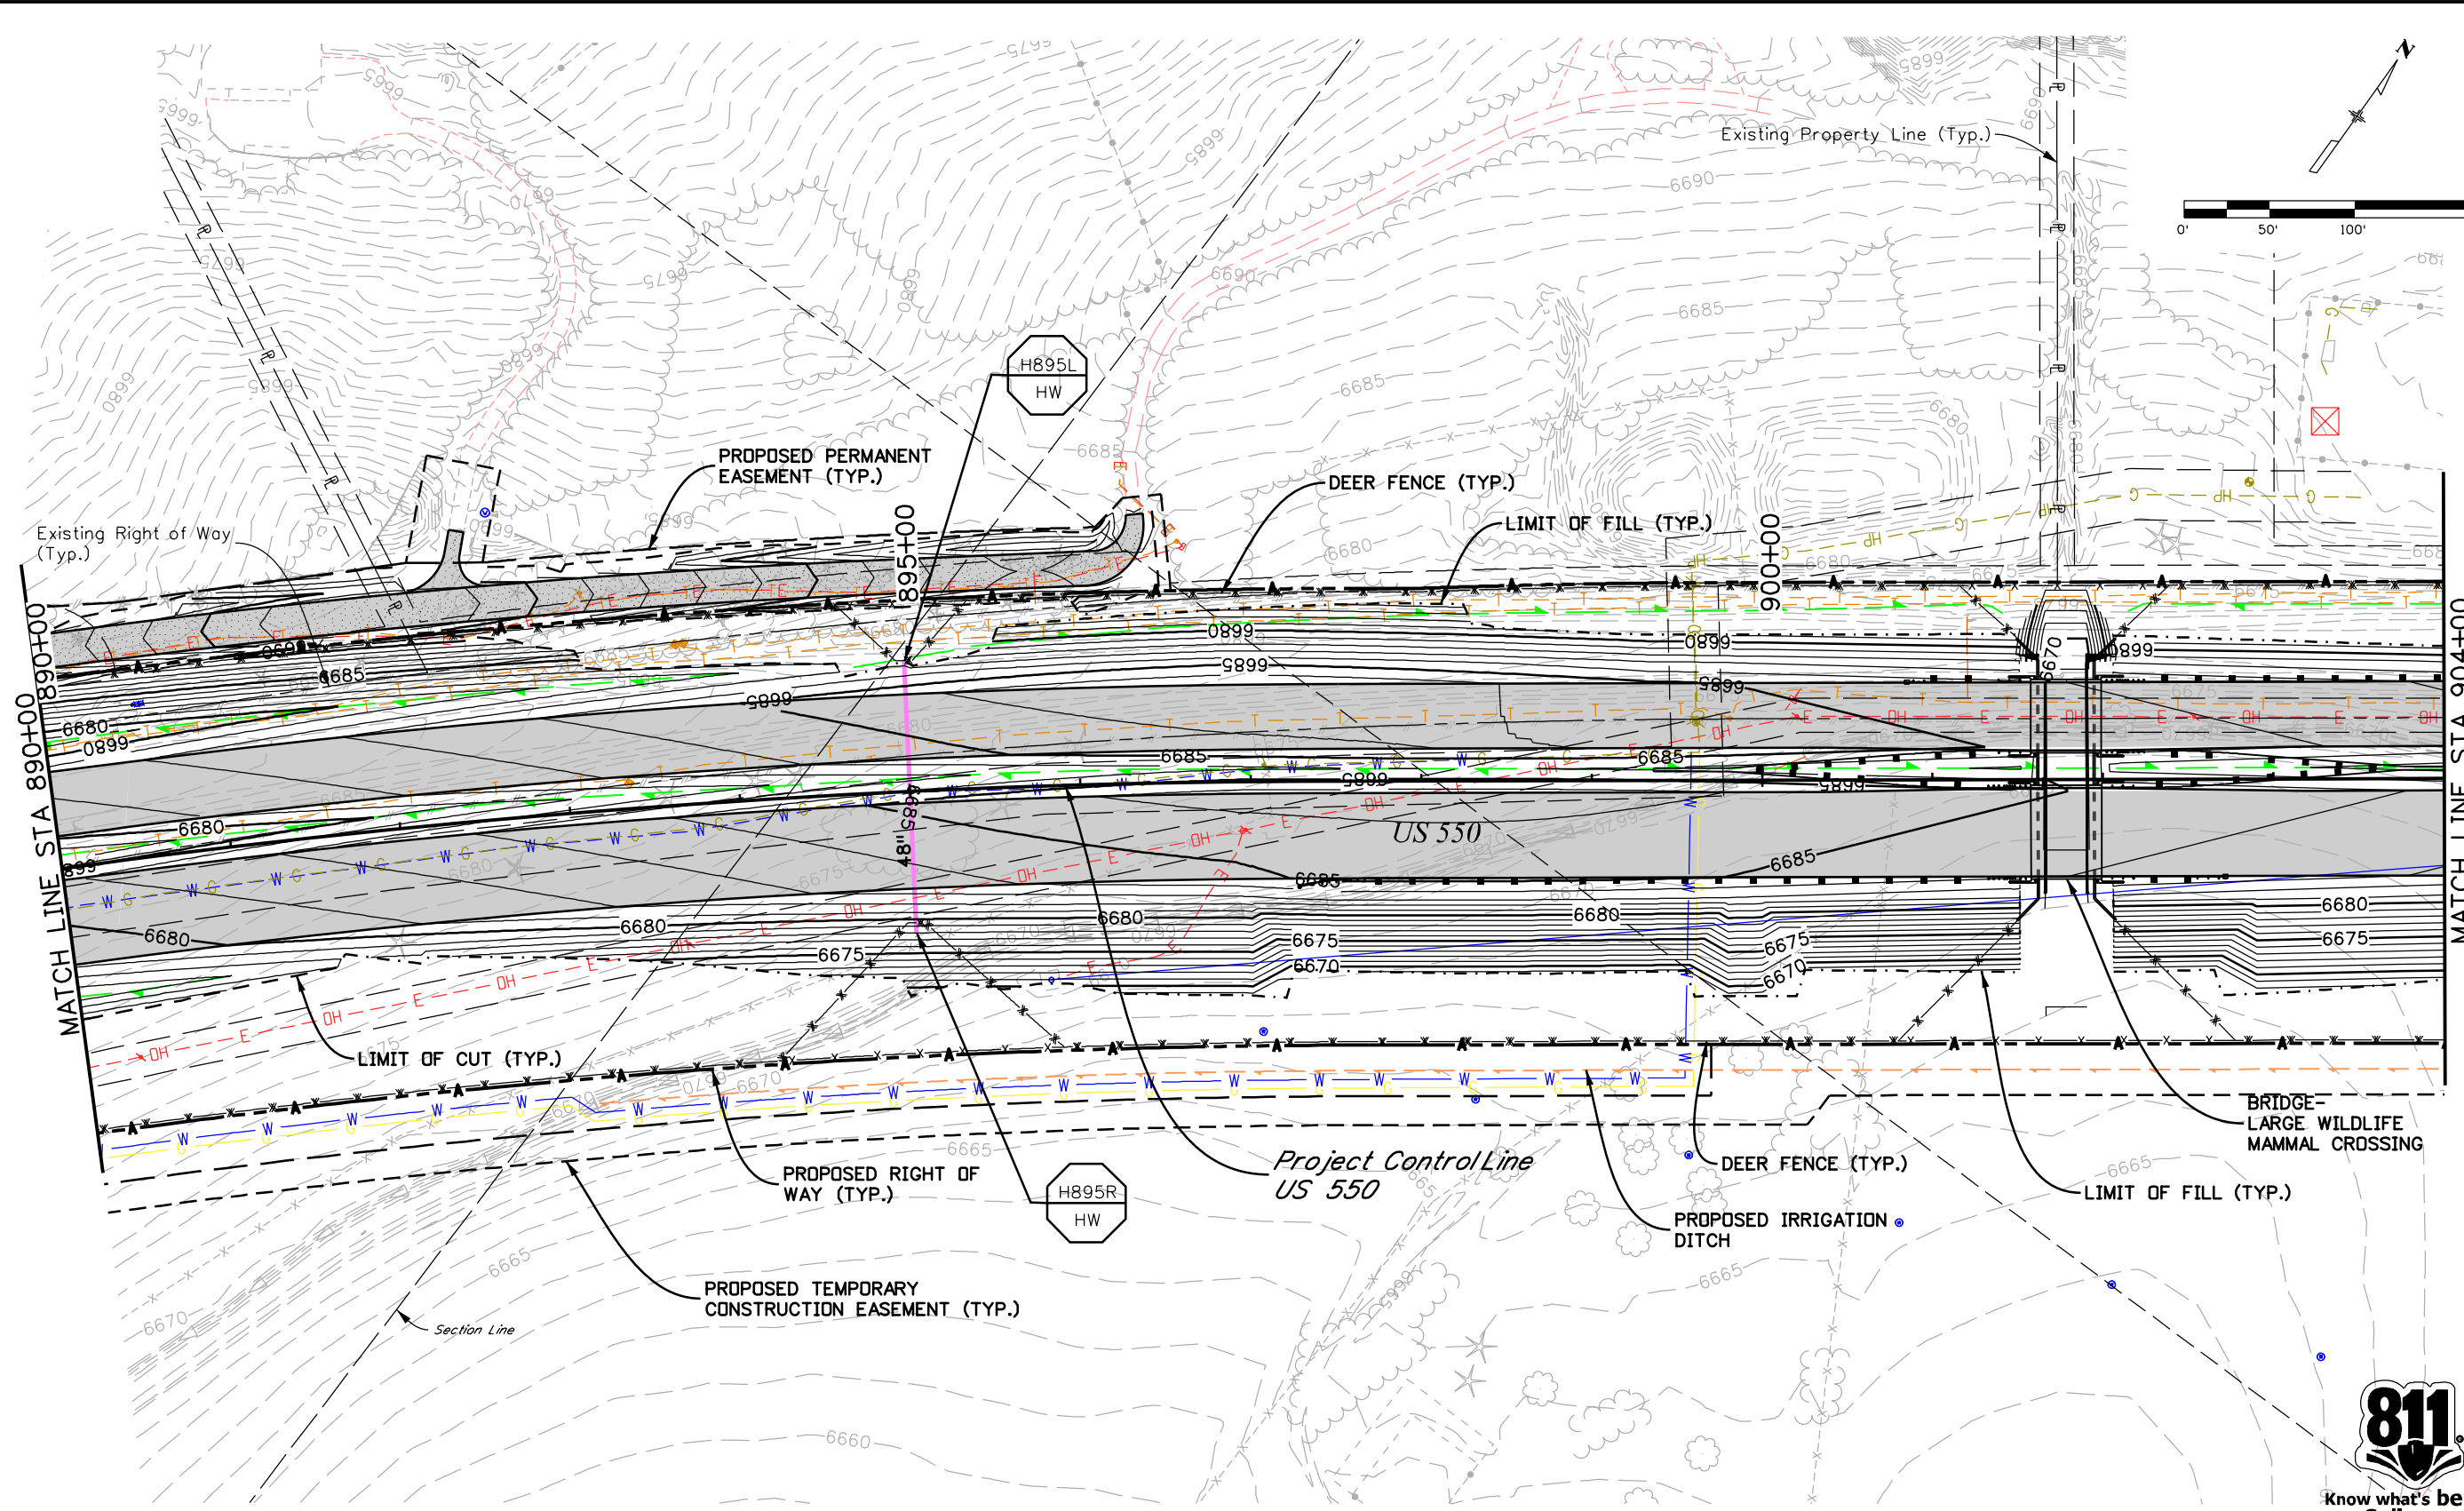

Print Date: 12/12/2018
Drawing File Name: 22420HYDR_Plan08.dgn
Horiz. Scale: 1:100 Vert. Scale: As Noted
Unit Information Unit Leader Initials
MULLER ENGINEERING COMPANY

Sheet Revisions		
Date:	Comments	Init.


Colorado Department of Transportation
 3803 North Main Avenue
 Suite 200
 Durango, CO 81301
 Phone: 970-385-1440 FAX: 970-385-8365
Region 5 **DRV**

As Constructed
No Revisions:
Revised:
Void:

US 550 DRAINAGE PLAN			
STA. 890+00 TO STA. 904+00			
Designer:	CHH	Structure	
Detailer:	LMR	Numbers	
Sheet Subset:	DRAINAGE	Subset Sheets:	8 of 19

Project No./Code
Project Number
22420
Sheet Number

R:\Users\158615_PN\2018\Projects\18-018.01 US 550_S Connection D-B - CDDT R-5\22420\Hydraulics\Drawings\22420HYDR_Plan09.dgn
 12/12/2018 CDDT-Debra\Printer_V8i.plt;cig CDDT V81 CLR-UTIL.tbl

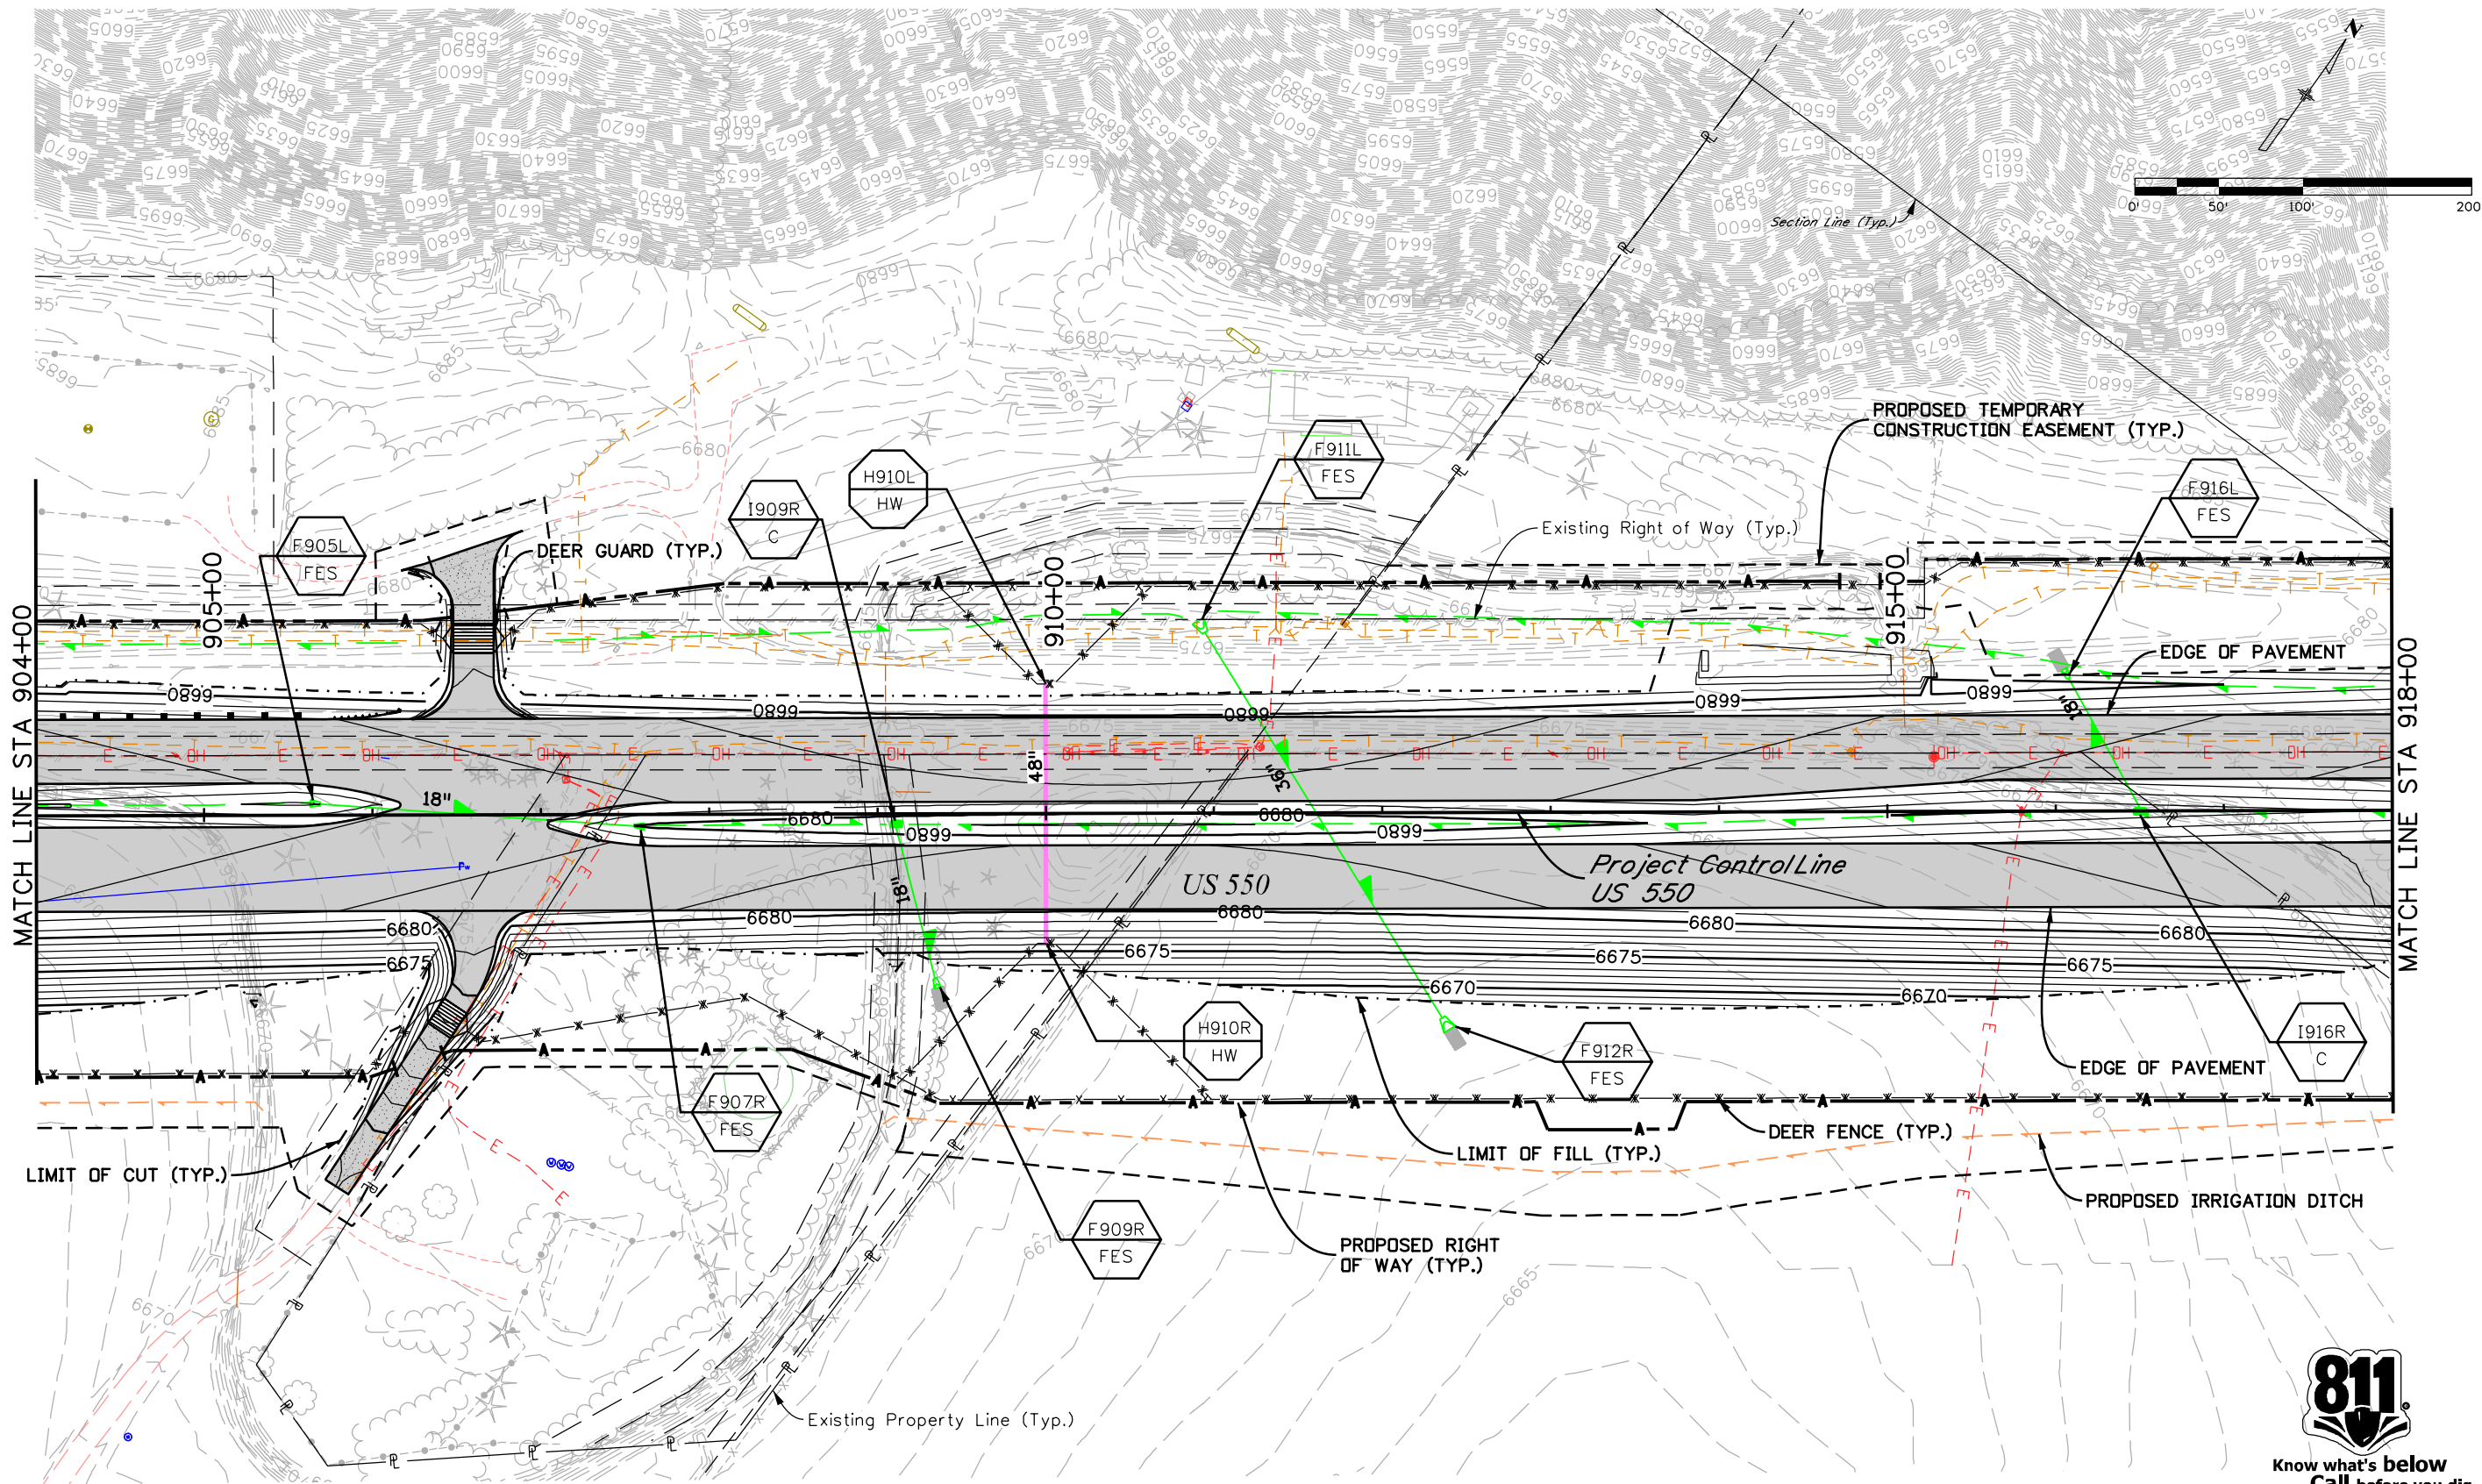

Know what's below
Call before you dig.

Print Date: 12/12/2018	
Drawing File Name: 22420HYDR_Plan09.dgn	
Horiz. Scale: 1:100	Vert. Scale: As Noted
Unit Information	Unit Leader Initials
MULLER ENGINEERING COMPANY	

Sheet Revisions		
Date:	Comments	Init.

Colorado Department of Transportation

3803 North Main Avenue
Suite 200
Durango, CO 81301
Phone: 970-385-1440 FAX: 970-385-8365


Region 5 **DRV**

As Constructed
No Revisions:
Revised:
Void:

US 550 DRAINAGE PLAN STA. 904+00 TO STA. 918+00			
Designer:	CHH	Structure	
Detailer:	LMR	Numbers	
Sheet Subset:	DRAINAGE	Subset Sheets:	9 of 19

Project No./Code
Project Number
22420
Sheet Number

R:\060823 PM P\2018 Projects\18-018.01 US 550 S Connection D-B - CDDT R-5\22420\Hydraulics Drawings\22420HYDR_Plan10.dgn
 12/12/2018 11:58:23 AM P\2018 Projects\18-018.01 US 550 S Connection D-B - CDDT R-5\22420\Hydraulics Drawings\22420HYDR_Plan10.dgn
 CDDT-DePaulPrinter_V81.plt;c1g CDDT V81 CLR-UTL.tbl

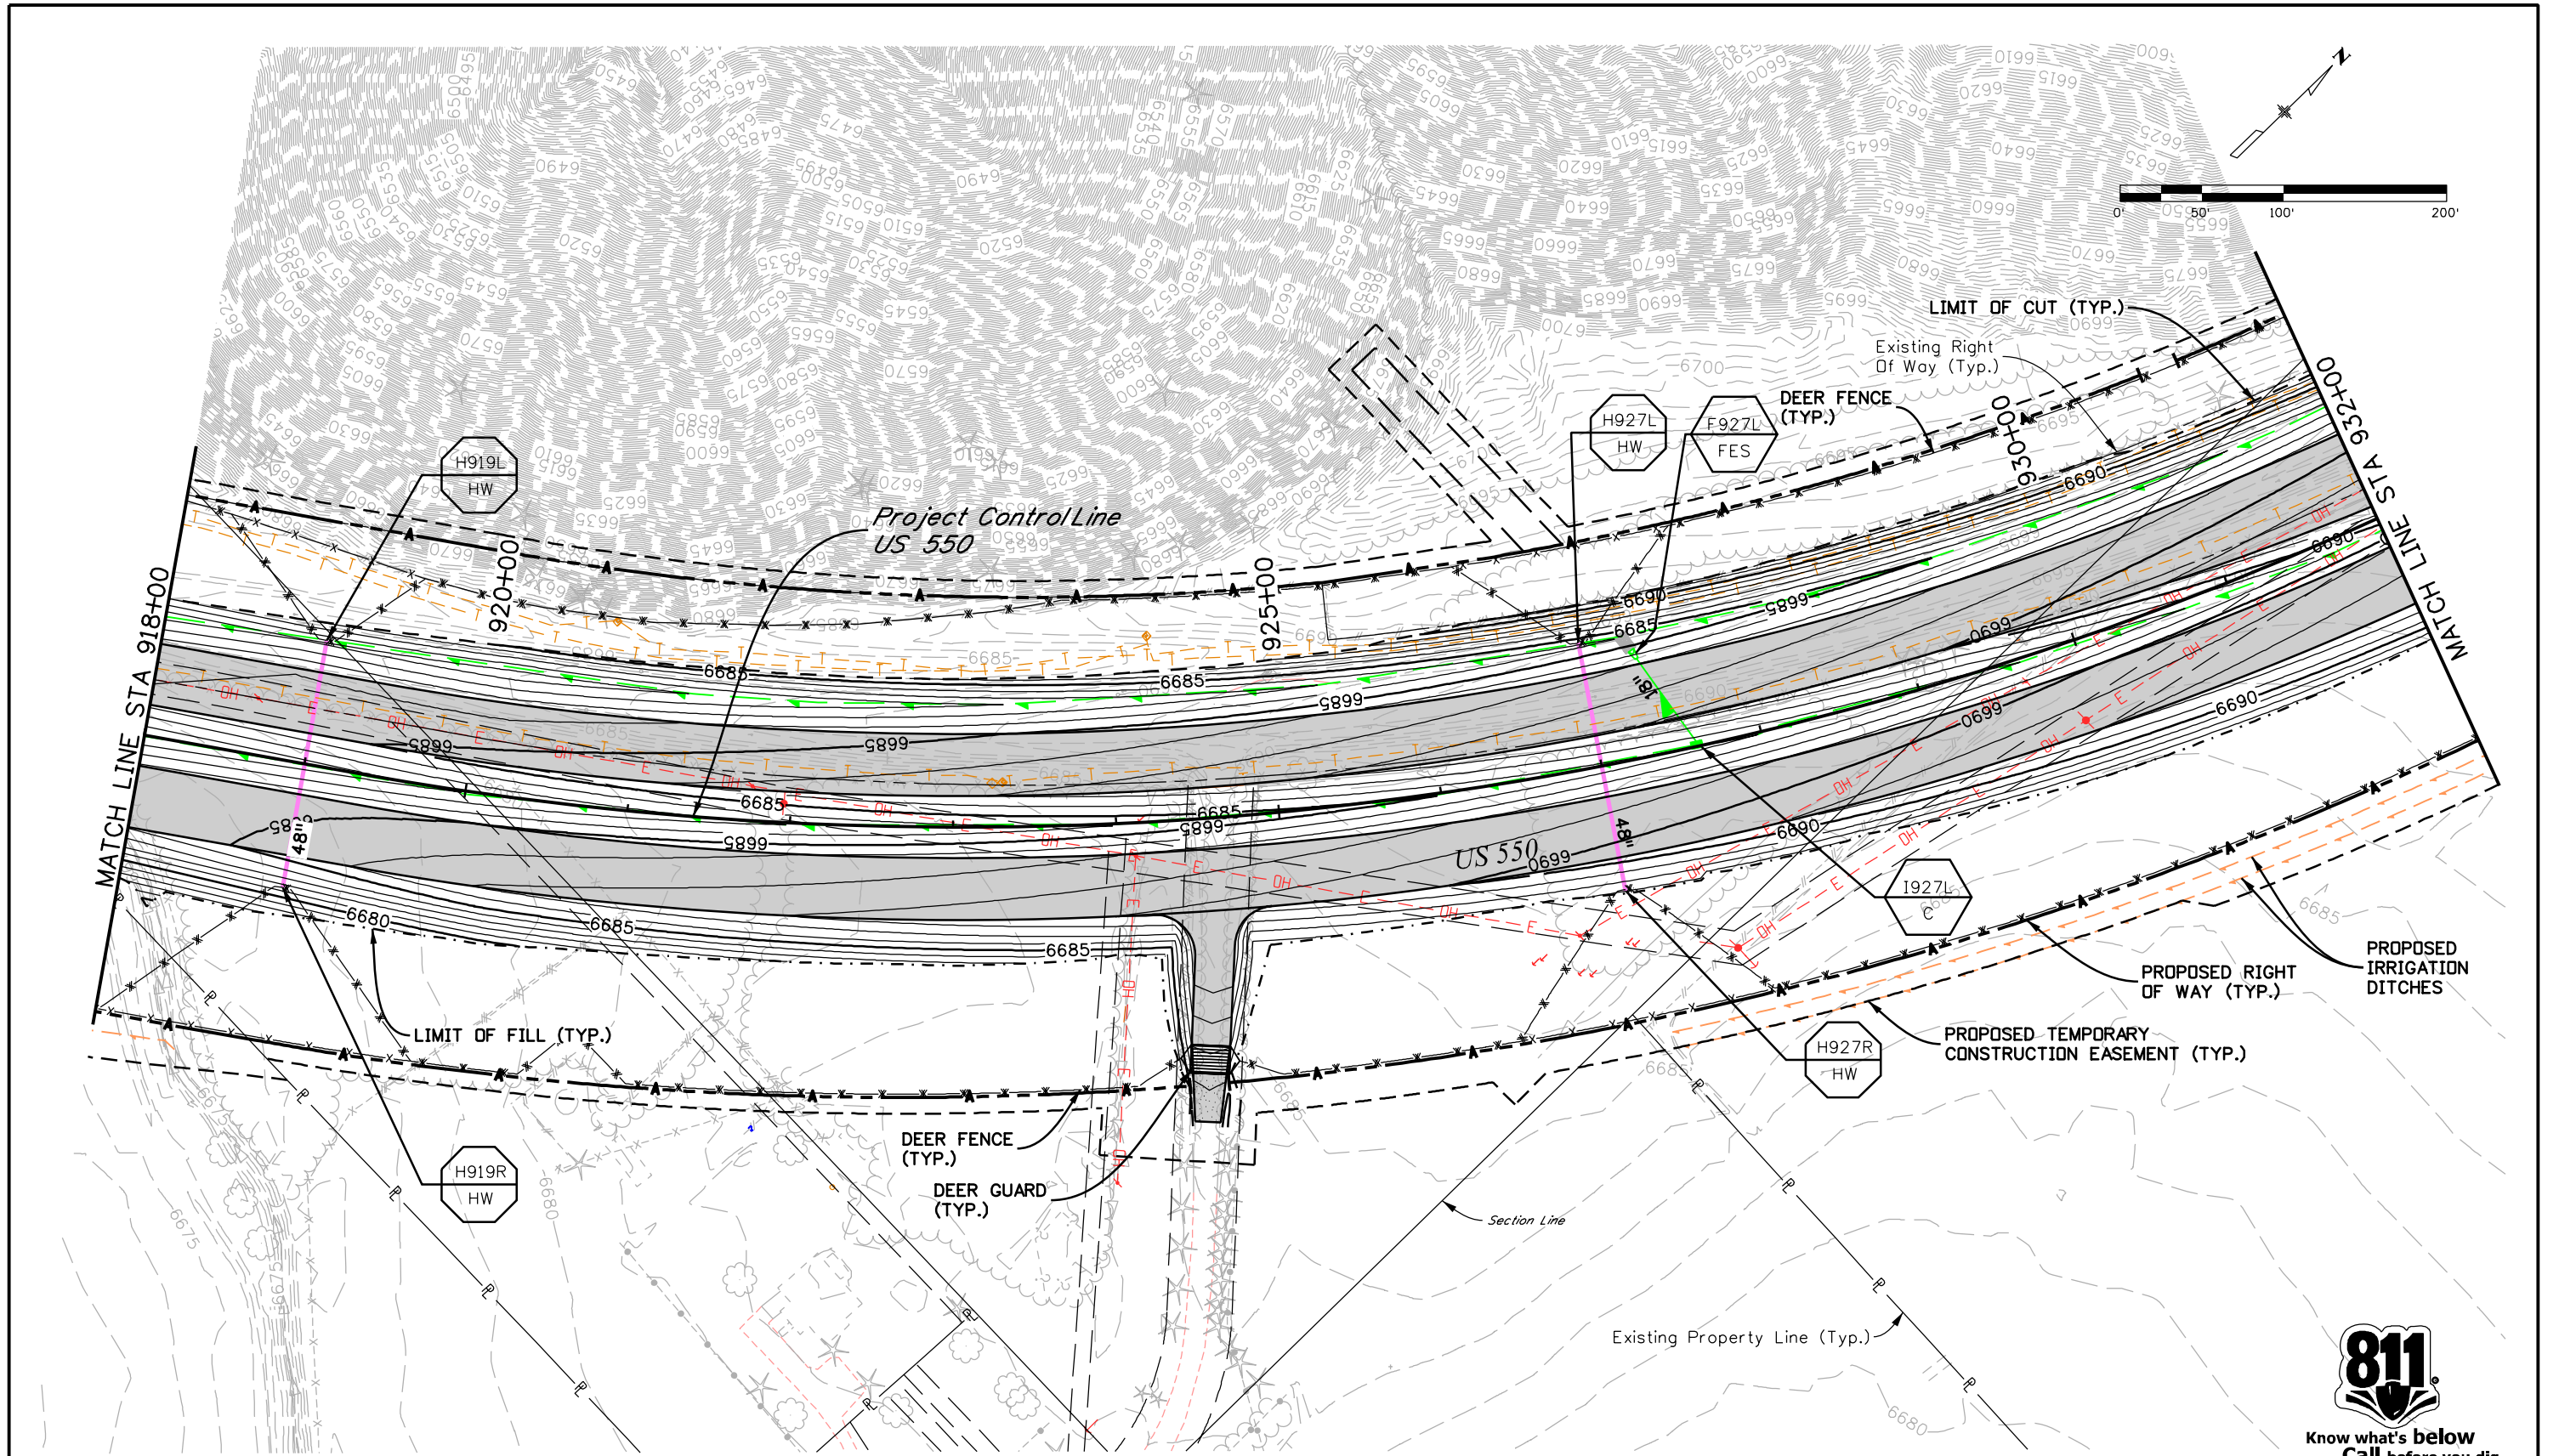

Know what's below
Call before you dig.

Print Date: 12/12/2018
Drawing File Name: 22420HYDR_Plan10.dgn
Horiz. Scale: 1:100 Vert. Scale: As Noted
Unit Information Unit Leader Initials
MULLER ENGINEERING COMPANY

Sheet Revisions		
Date:	Comments	Init.

Colorado Department of Transportation

3803 North Main Avenue
Suite 200
Durango, CO 81301
Phone: 970-385-1440 FAX: 970-385-8365


Region 5 **DRV**

As Constructed
No Revisions:
Revised:
Void:

US 550 DRAINAGE PLAN STA. 918+00 TO STA. 932+00			
Designer:	CHH	Structure	
Detailer:	LMR	Numbers	
Sheet Subset:	DRAINAGE	Subset Sheets:	10 of 19

Project No./Code
Project Number
22420
Sheet Number

R:\060832 PM P\2018 Projects\18-018.01 US 550 S Connection D-B - CDDT R-5\22420\Hydraulics Drawings\22420HYDR_Plan1.dgn
 12/12/2018 CDDT-DebraPrinter_V81.plt.ctb CDDT V81 CLR-UTL.tbl

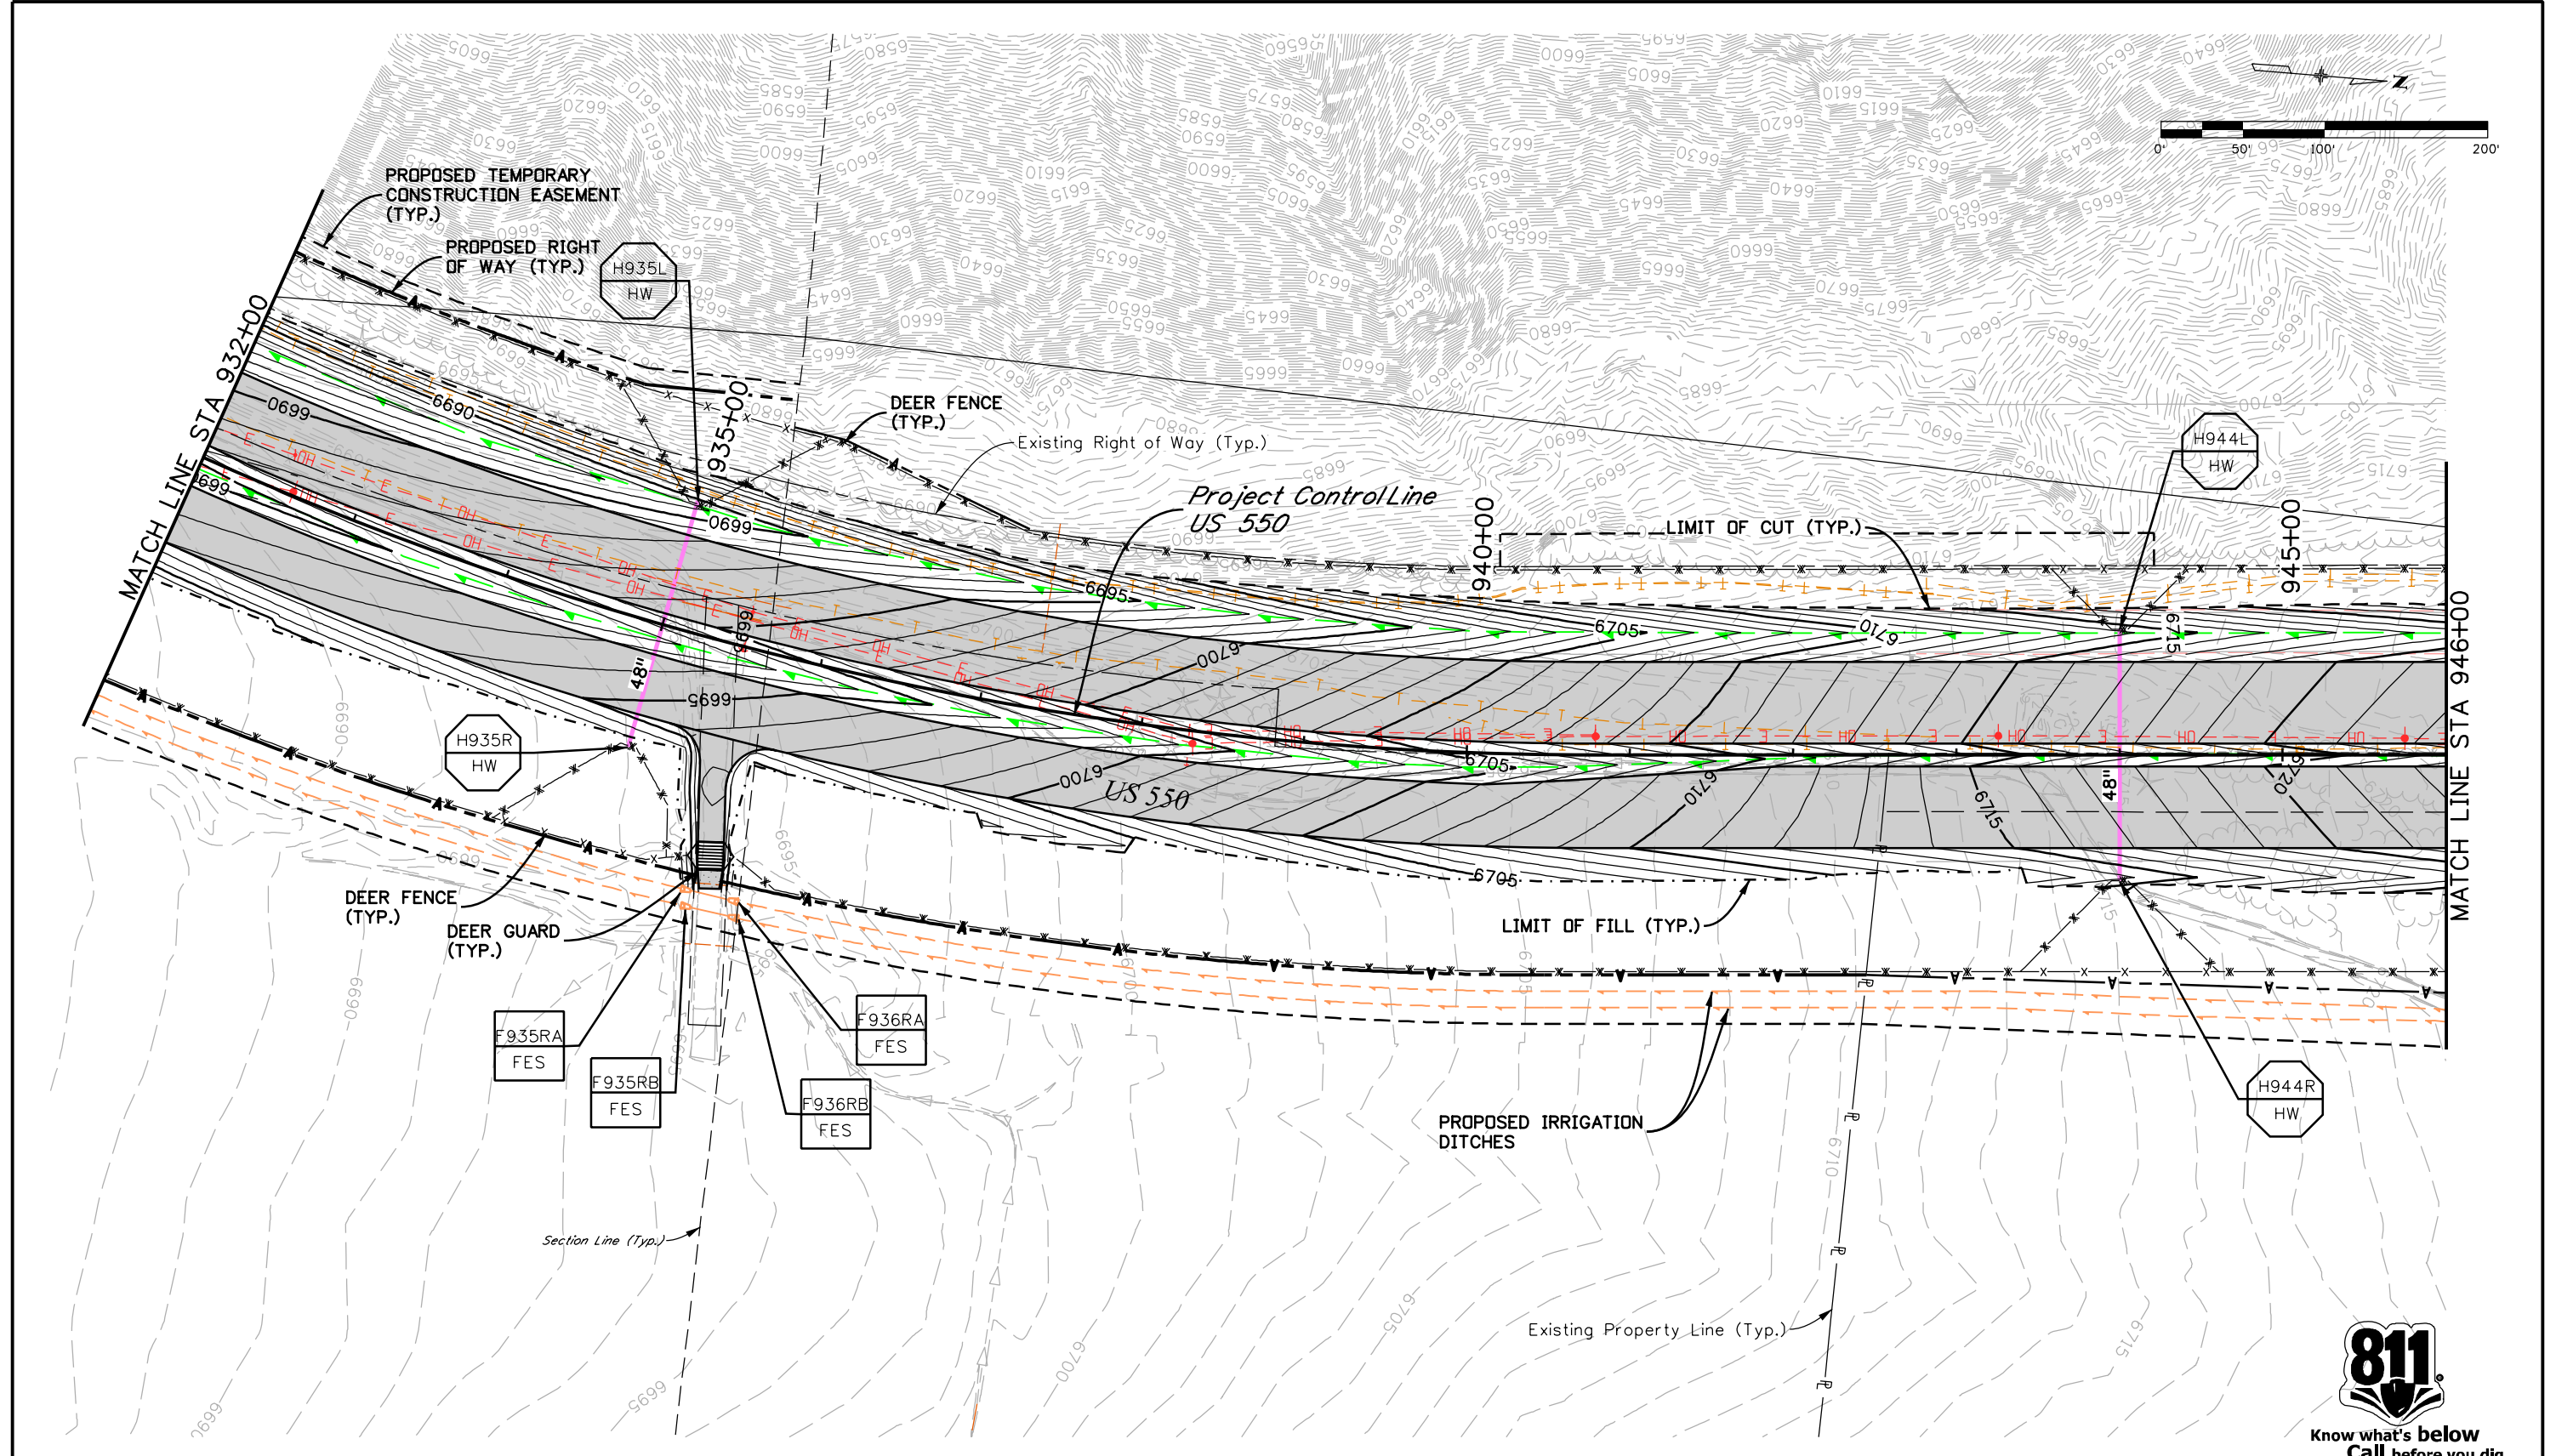

Print Date: 12/12/2018	
Drawing File Name: 22420HYDR_Plan1.dgn	
Horiz. Scale: 1:100	Vert. Scale: As Noted
Unit Information	Unit Leader Initials

Sheet Revisions		
Date:	Comments	Init.


Colorado Department of Transportation
 3803 North Main Avenue
 Suite 200
 Durango, CO 81301
 Phone: 970-385-1440 FAX: 970-385-8365
Region 5 **DRV**

As Constructed
No Revisions:
Revised:
Void:

US 550 DRAINAGE PLAN			
STA. 932+00 TO STA. 946+00			
Designer:	CHH	Structure	
Detailer:	LMR	Numbers	
Sheet Subset:	DRAINAGE	Subset Sheets:	11 of 19

Project No./Code
Project Number
22420
Sheet Number

R:\wopous 1586140 PM P1\2018 Projects\18-018.01 US 550 S Connection D-B - CDDT R-5\22420\Hydraulics\Drawings\22420HYDR_Plan12.dgn
 12/12/2018 11:58:40 AM P1\Printer_V81.pctg CDDT V81 CLR-UTIL.tbl

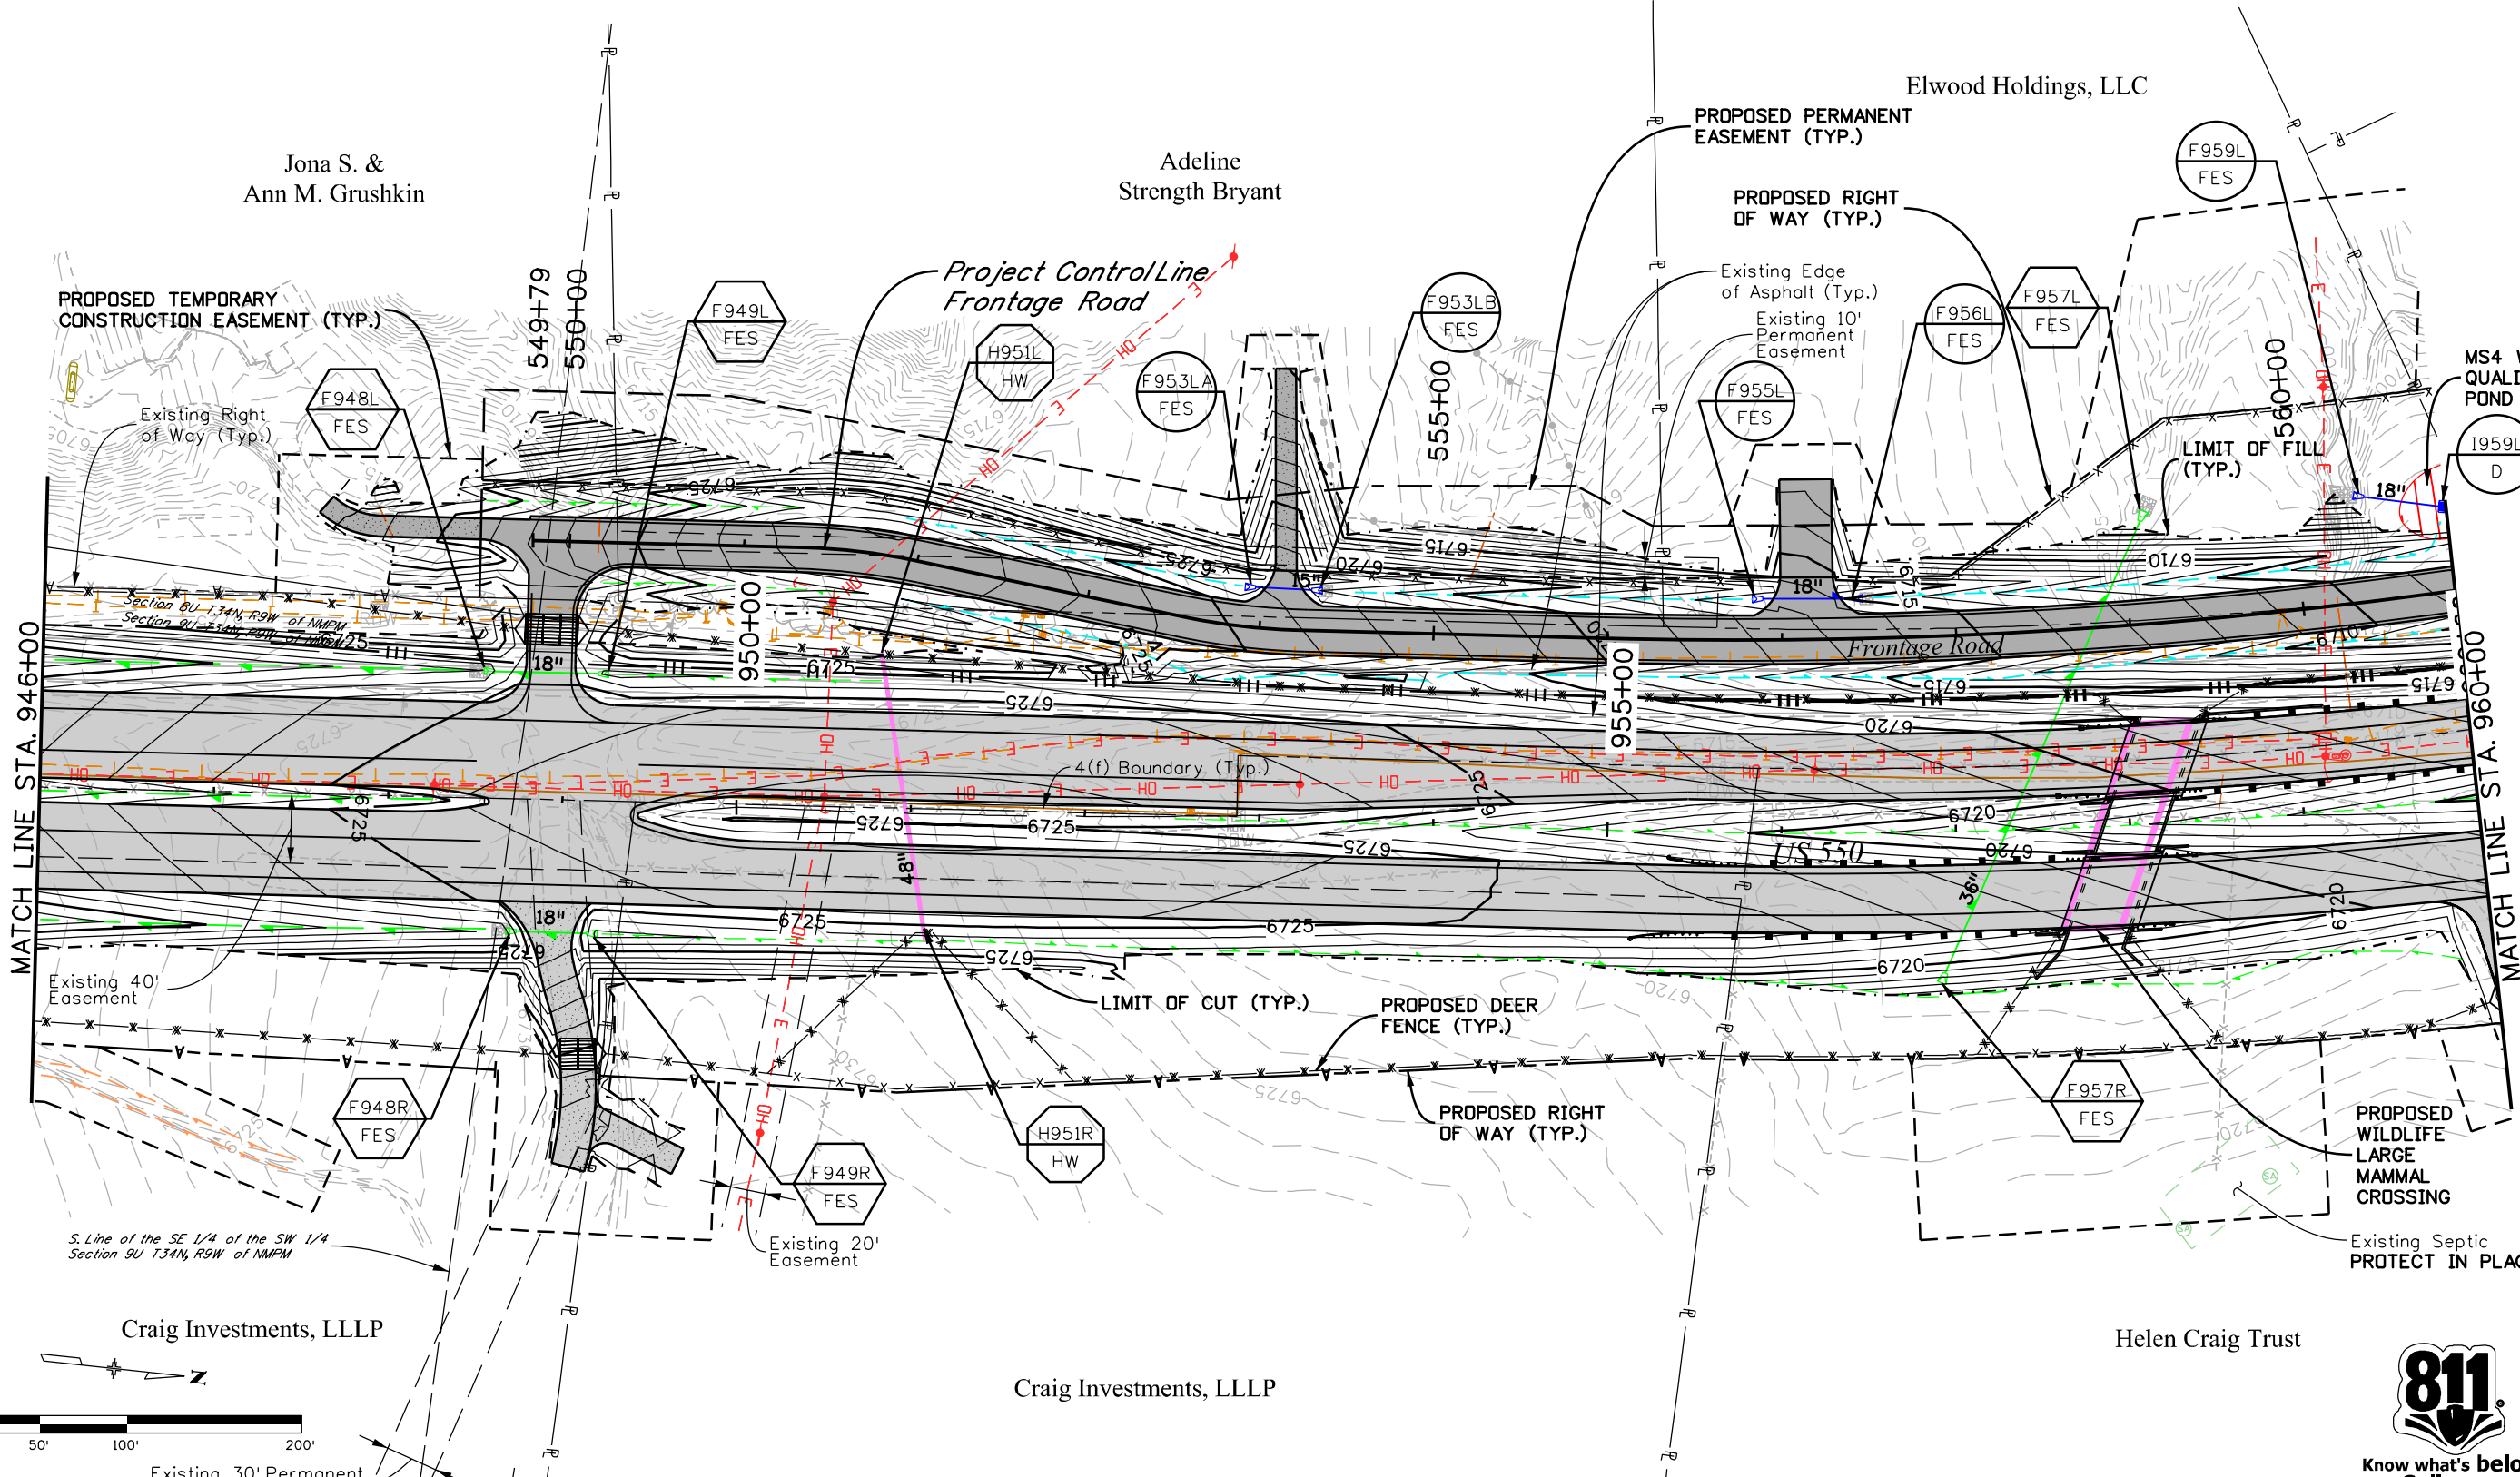

Print Date: 12/12/2018
 Drawing File Name: 22420HYDR_Plan12.dgn
 Horiz. Scale: 1:100 Vert. Scale: As Noted
 Unit Information Unit Leader Initials

Sheet Revisions		
Date:	Comments	Init.

Colorado Department of Transportation
 3803 North Main Avenue
 Suite 200
 Durango, CO 81301
 Phone: 970-385-1440 FAX: 970-385-8365

Region 5 DRV

As Constructed
No Revisions:
Revised:
Void:

US 550 DRAINAGE PLAN
 STA. 946+00 TO STA. 960+00


Designer:	WVW	Structure Numbers
Detailer:	LMR	
Sheet Subset:	DRAINAGE	Subset Sheets: 12 of 19

Project No./Code

Project Number	22420
Sheet Number	



R:\wopous\158649_Plan\12/12/2018\Projects\18-018.01 US 550 S Connection D-B - CDDT R-5\22420\Hydraulics\Drawings\22420HYDR_Plan13.dgn
 12/12/2018 CDDT-Debra\Printer_V8i.plt:crg CDDT V8I CLR-UTL.tbl

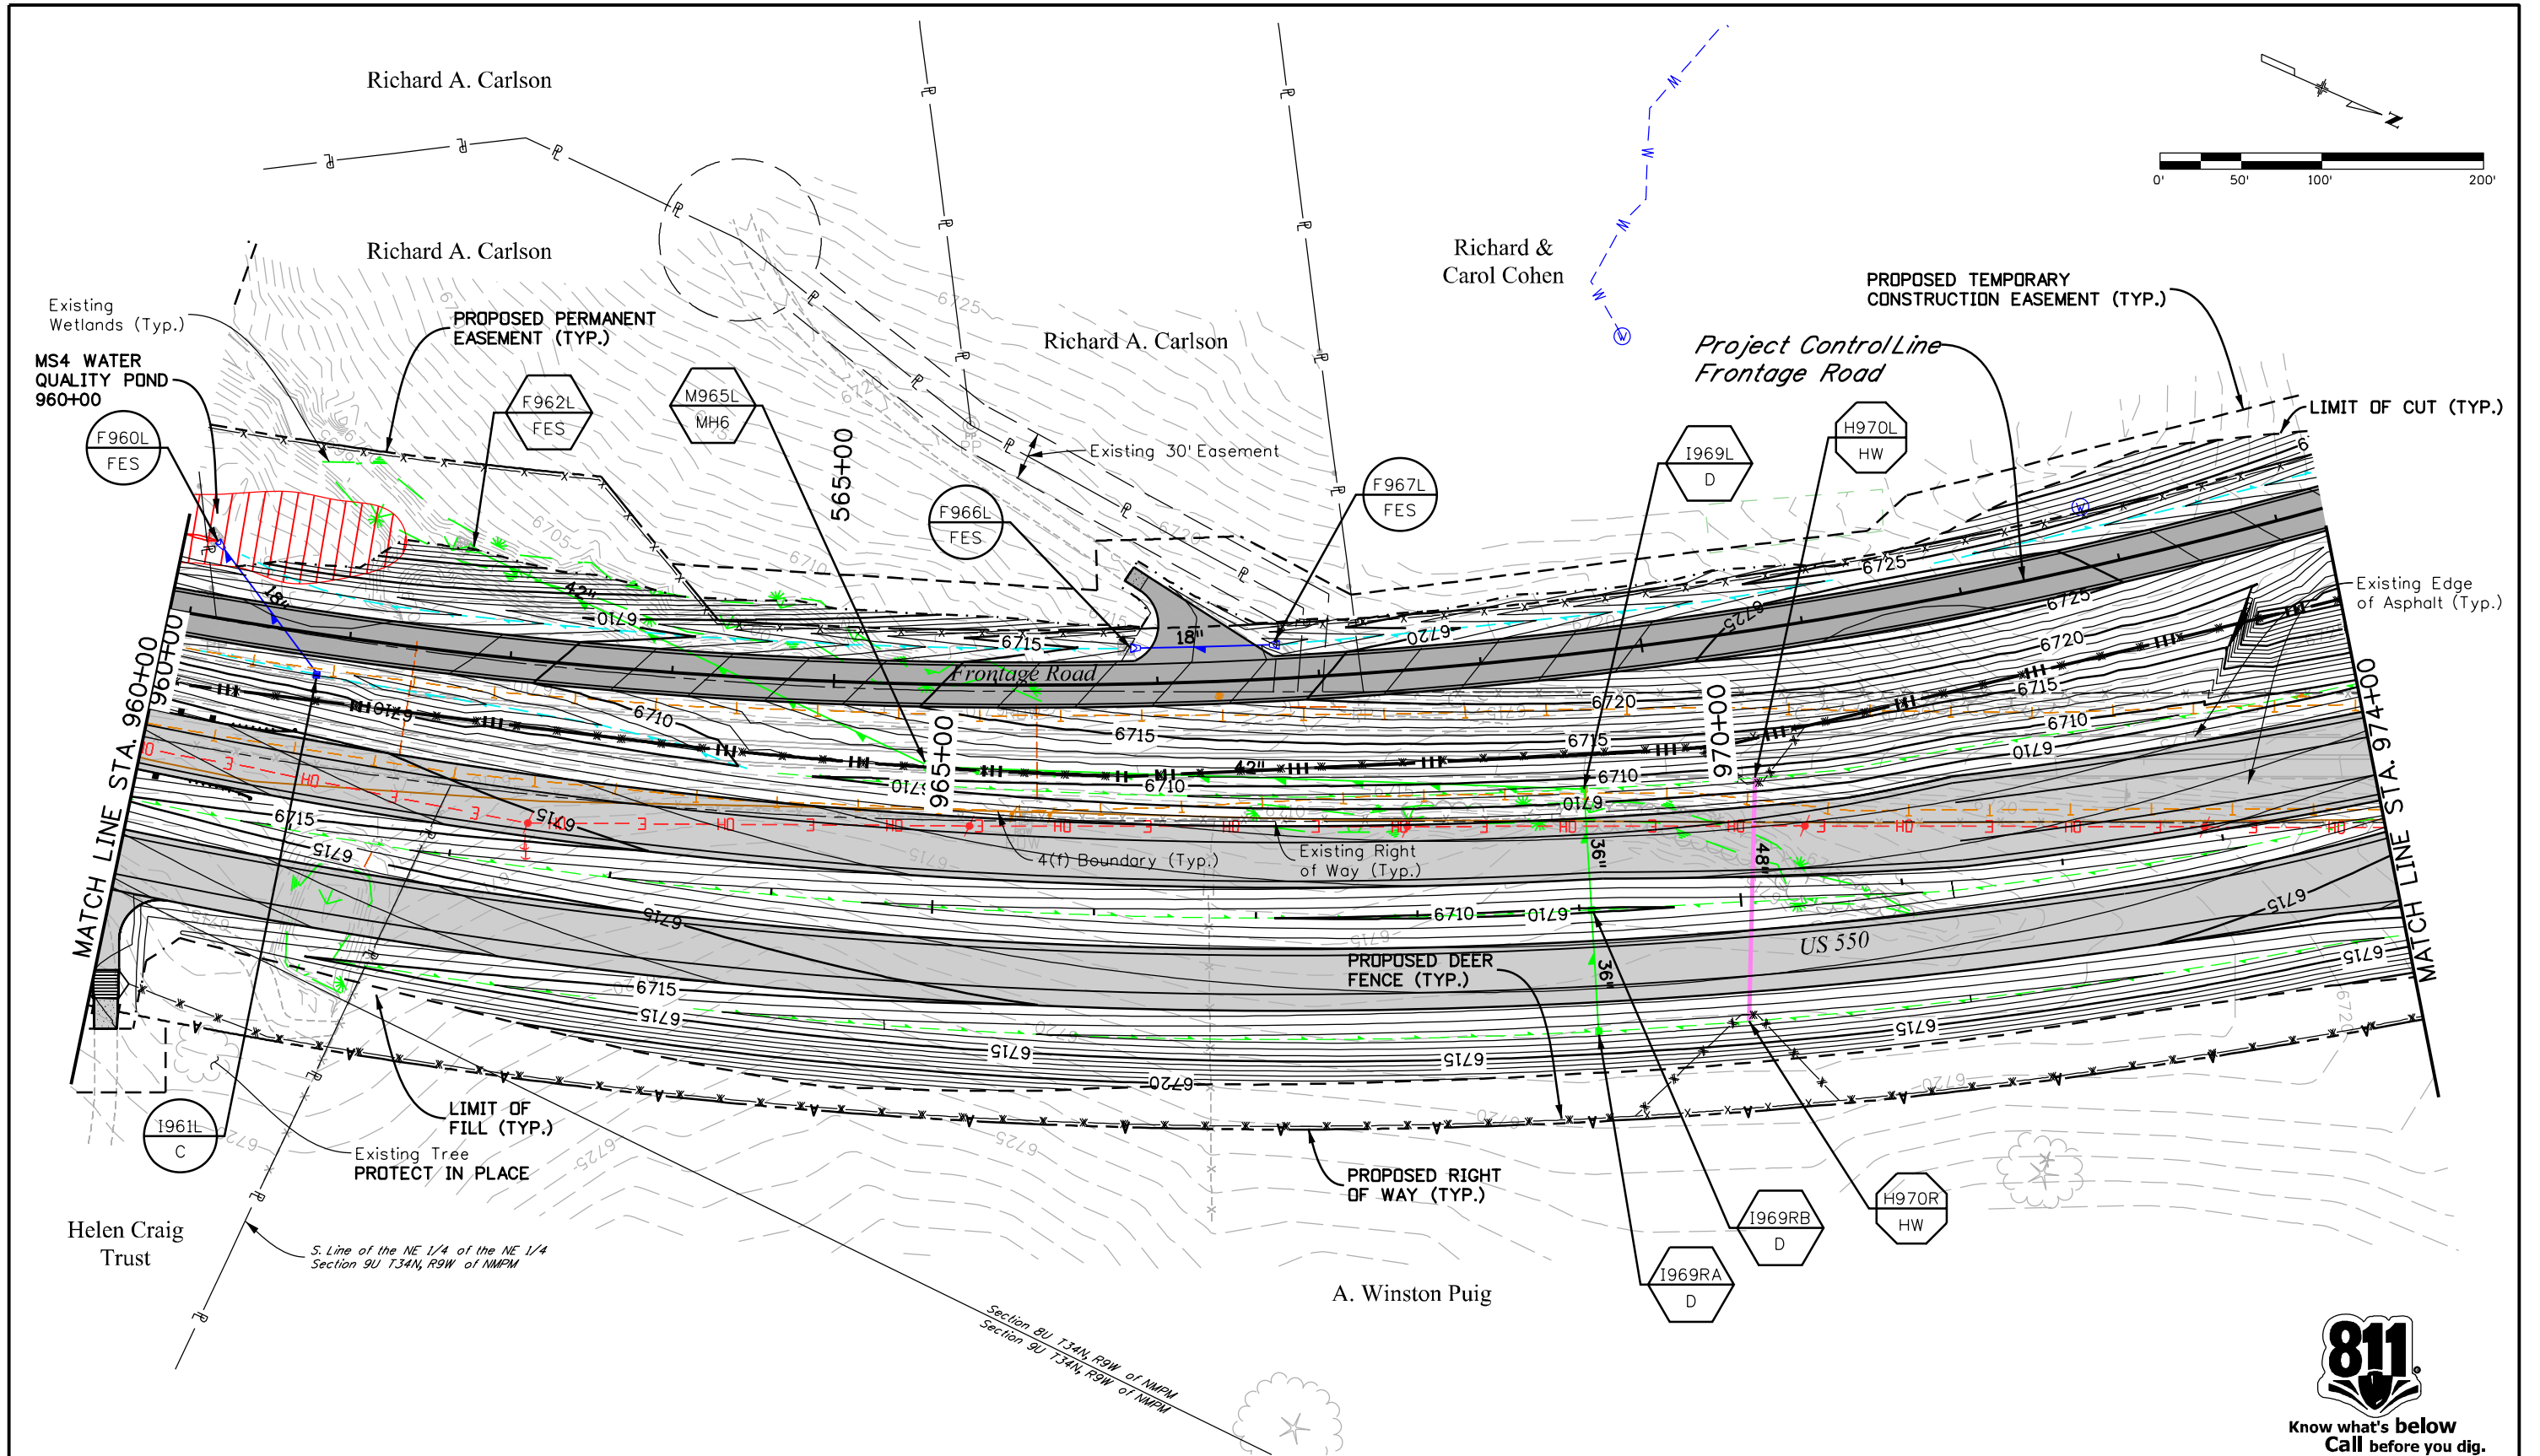

Print Date: 12/12/2018
Drawing File Name: 22420HYDR_Plan13.dgn
Horiz. Scale: 1:100 Vert. Scale: As Noted
Unit Information Unit Leader Initials
MULLER ENGINEERING COMPANY

Sheet Revisions		
Date:	Comments	Init.

Colorado Department of Transportation
 3803 North Main Avenue
 Suite 200
 Durango, CO 81301
 Phone: 970-385-1440 FAX: 970-385-8365
Region 5 **DRV**

As Constructed
No Revisions:
Revised:
Void:


US 550 DRAINAGE PLAN			
STA. 960+00 TO STA. 974+00			
Designer:	WVW	Structure	
Detailer:	LMR	Numbers	
Sheet Subset:	DRAINAGE	Subset Sheets:	13 of 19

Project No./Code
Project Number
22420
Sheet Number



Know what's below
Call before you dig.

Jerry T. Piccoli, et. al.

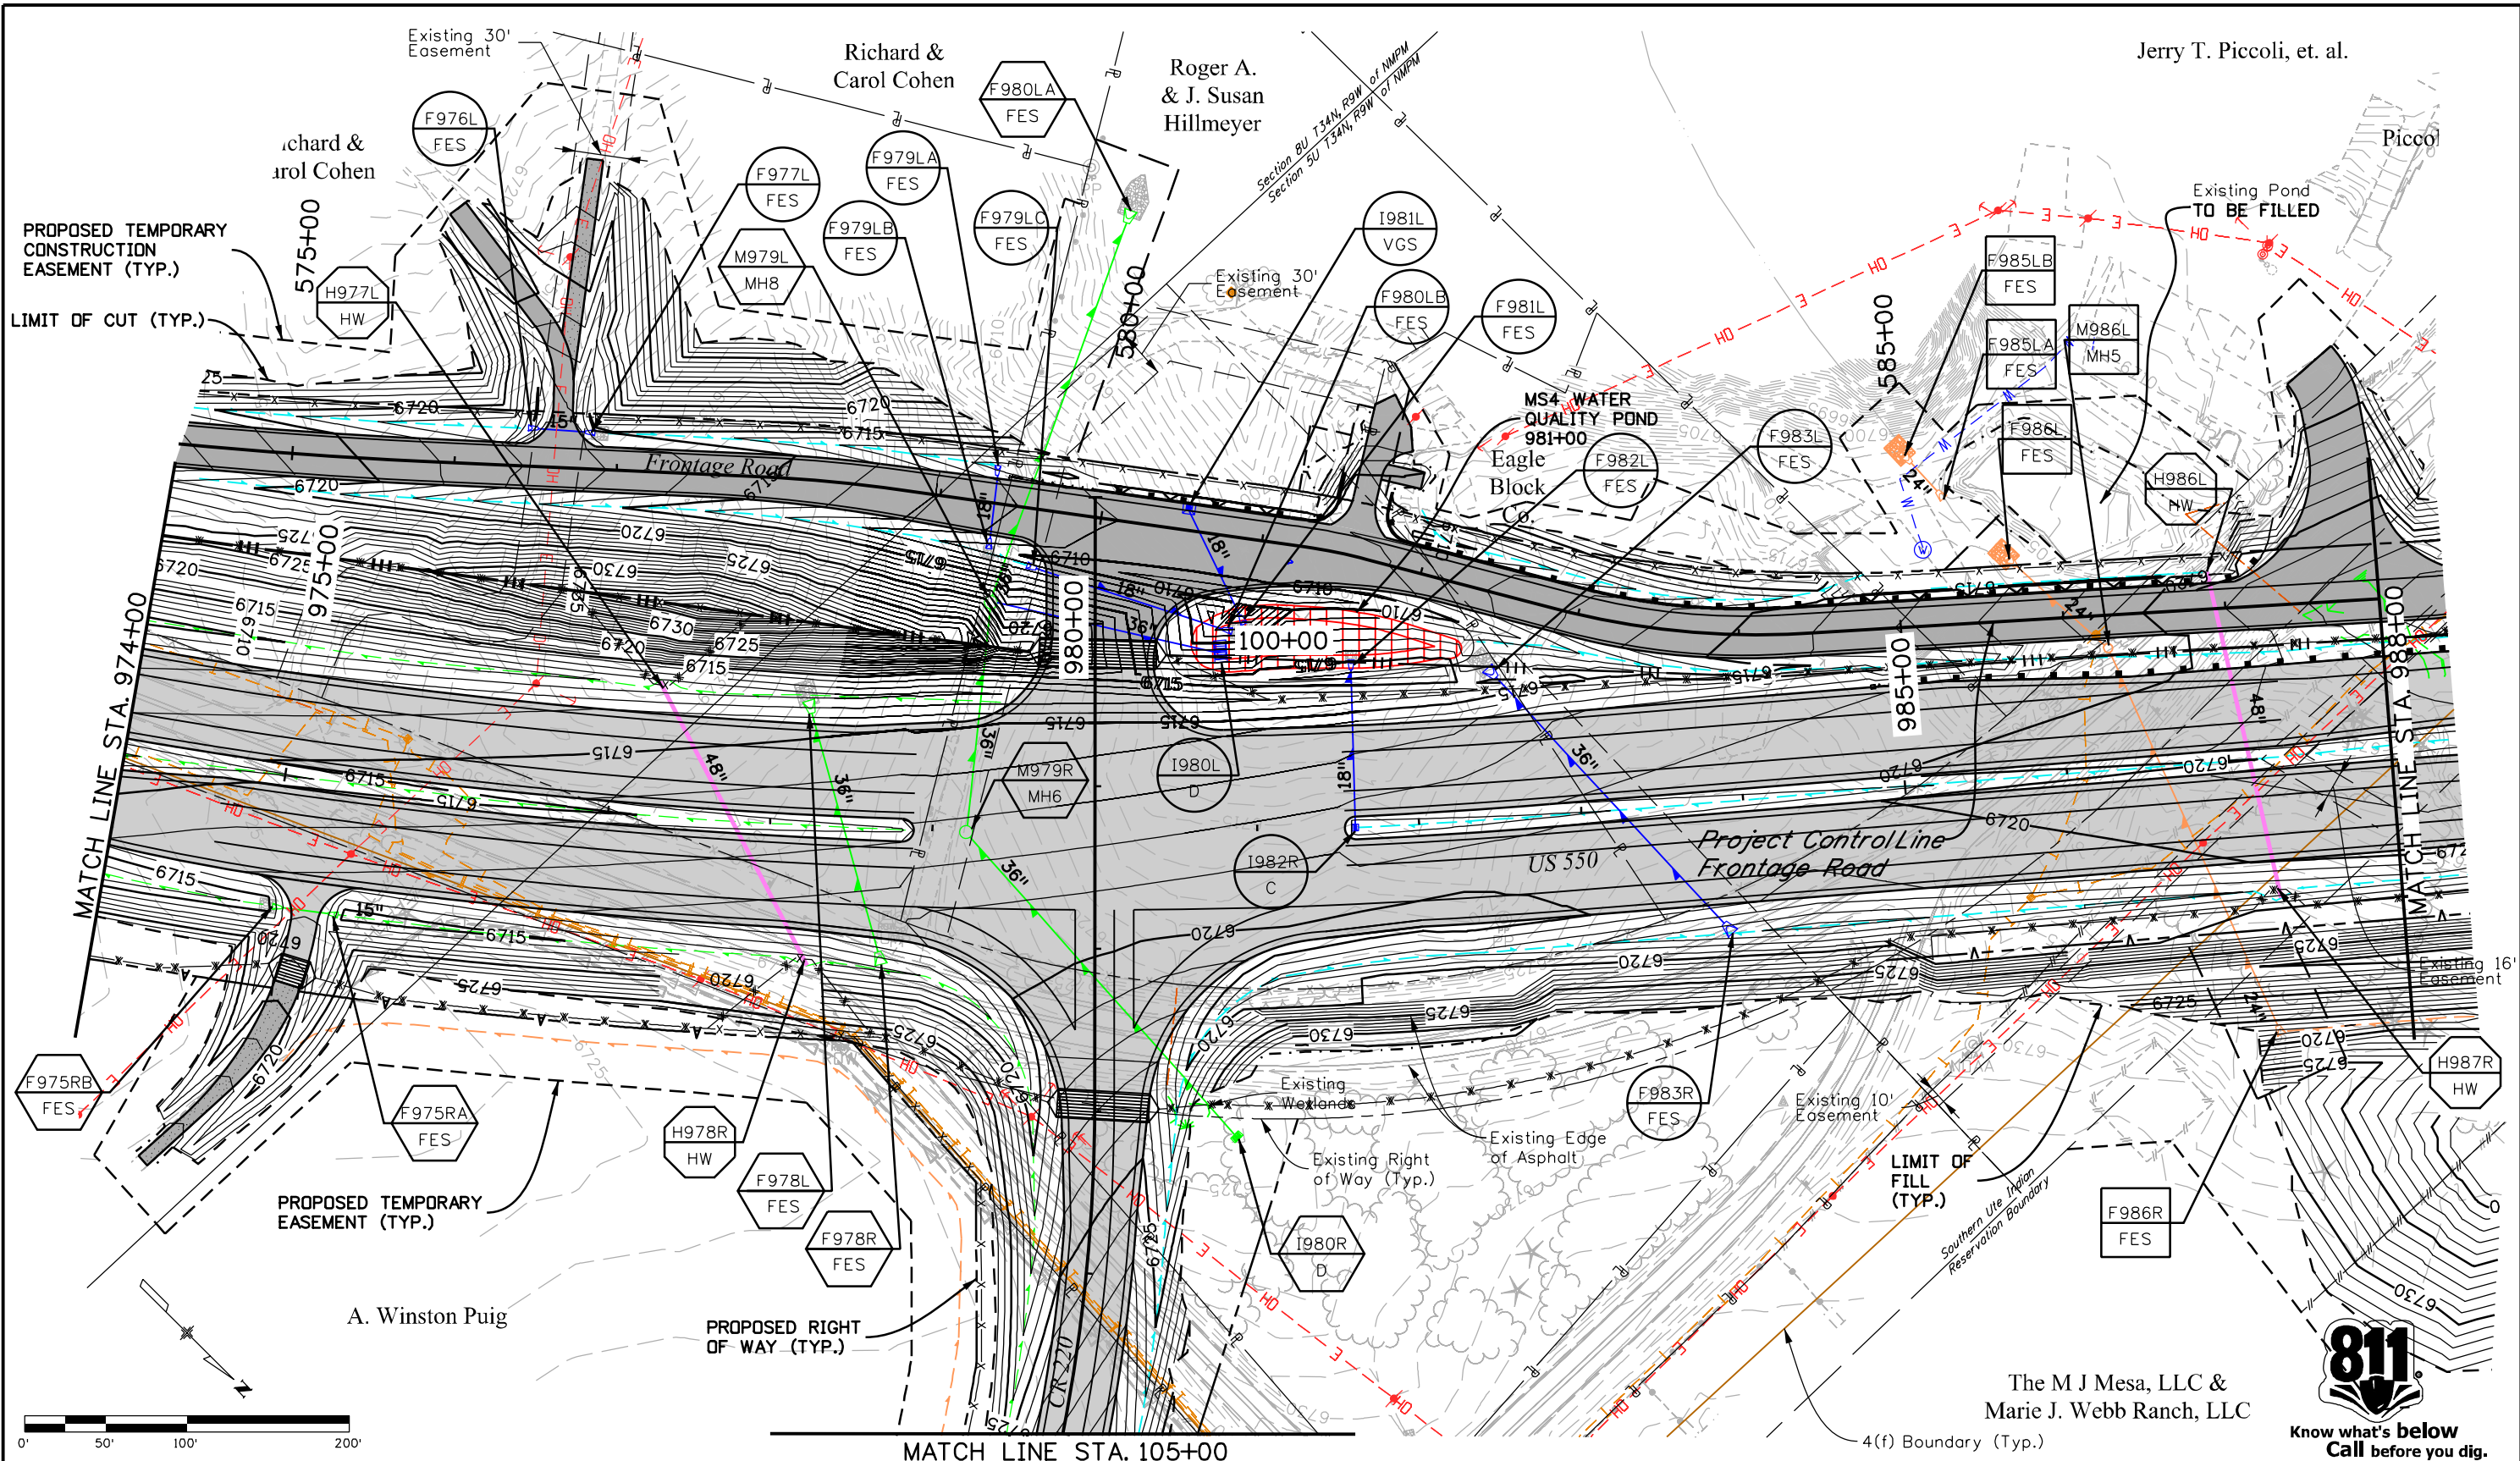

R:\090915\58657_Plan14.dwg 12/12/2018 11:58:57 AM P:\2018 Projects\18-018.01 US 550 S Connection D-B - CDDT R-5\22420\Hydraulics Drawings\22420HYDR_Plan14.dgn

Print Date: 12/12/2018	
Drawing File Name: 22420HYDR_Plan14.dgn	
Horiz. Scale: 1:100	Vert. Scale: As Noted
Unit Information	Unit Leader Initials
MULLER ENGINEERING COMPANY	

Sheet Revisions		
Date:	Comments	Init.

Colorado Department of Transportation
 3803 North Main Avenue
 Suite 200
 Durango, CO 81301
 Phone: 970-385-1440 FAX: 970-385-8365

Region 5 **DRV**

As Constructed	
No Revisions:	
Revised:	
Void:	



US 550 DRAINAGE PLAN STA. 974+00 TO STA. 988+00			
Designer:	WVW	Structure	
Detailer:	LMR	Numbers	
Sheet Subset:	DRAINAGE	Subset Sheets:	14 of 19

Project No./Code	
Project Number	
22420	
Sheet Number	

The M J Mesa, LLC & Marie J. Webb Ranch, LLC



R:\w0906 PM P\2018 Projects\18-018.01 US 550 S Connection D-B - CDDT R-5\22420\Hydraulics\Drawings\22420HYDR_Plan15.dgn
 12/12/2018 CDDT-Debra\Printer_V81.pct.cig CDDT V81 CLR-UTL.tbl

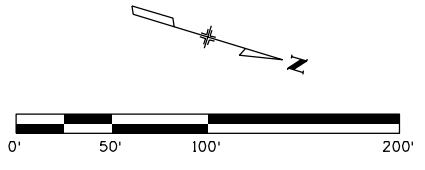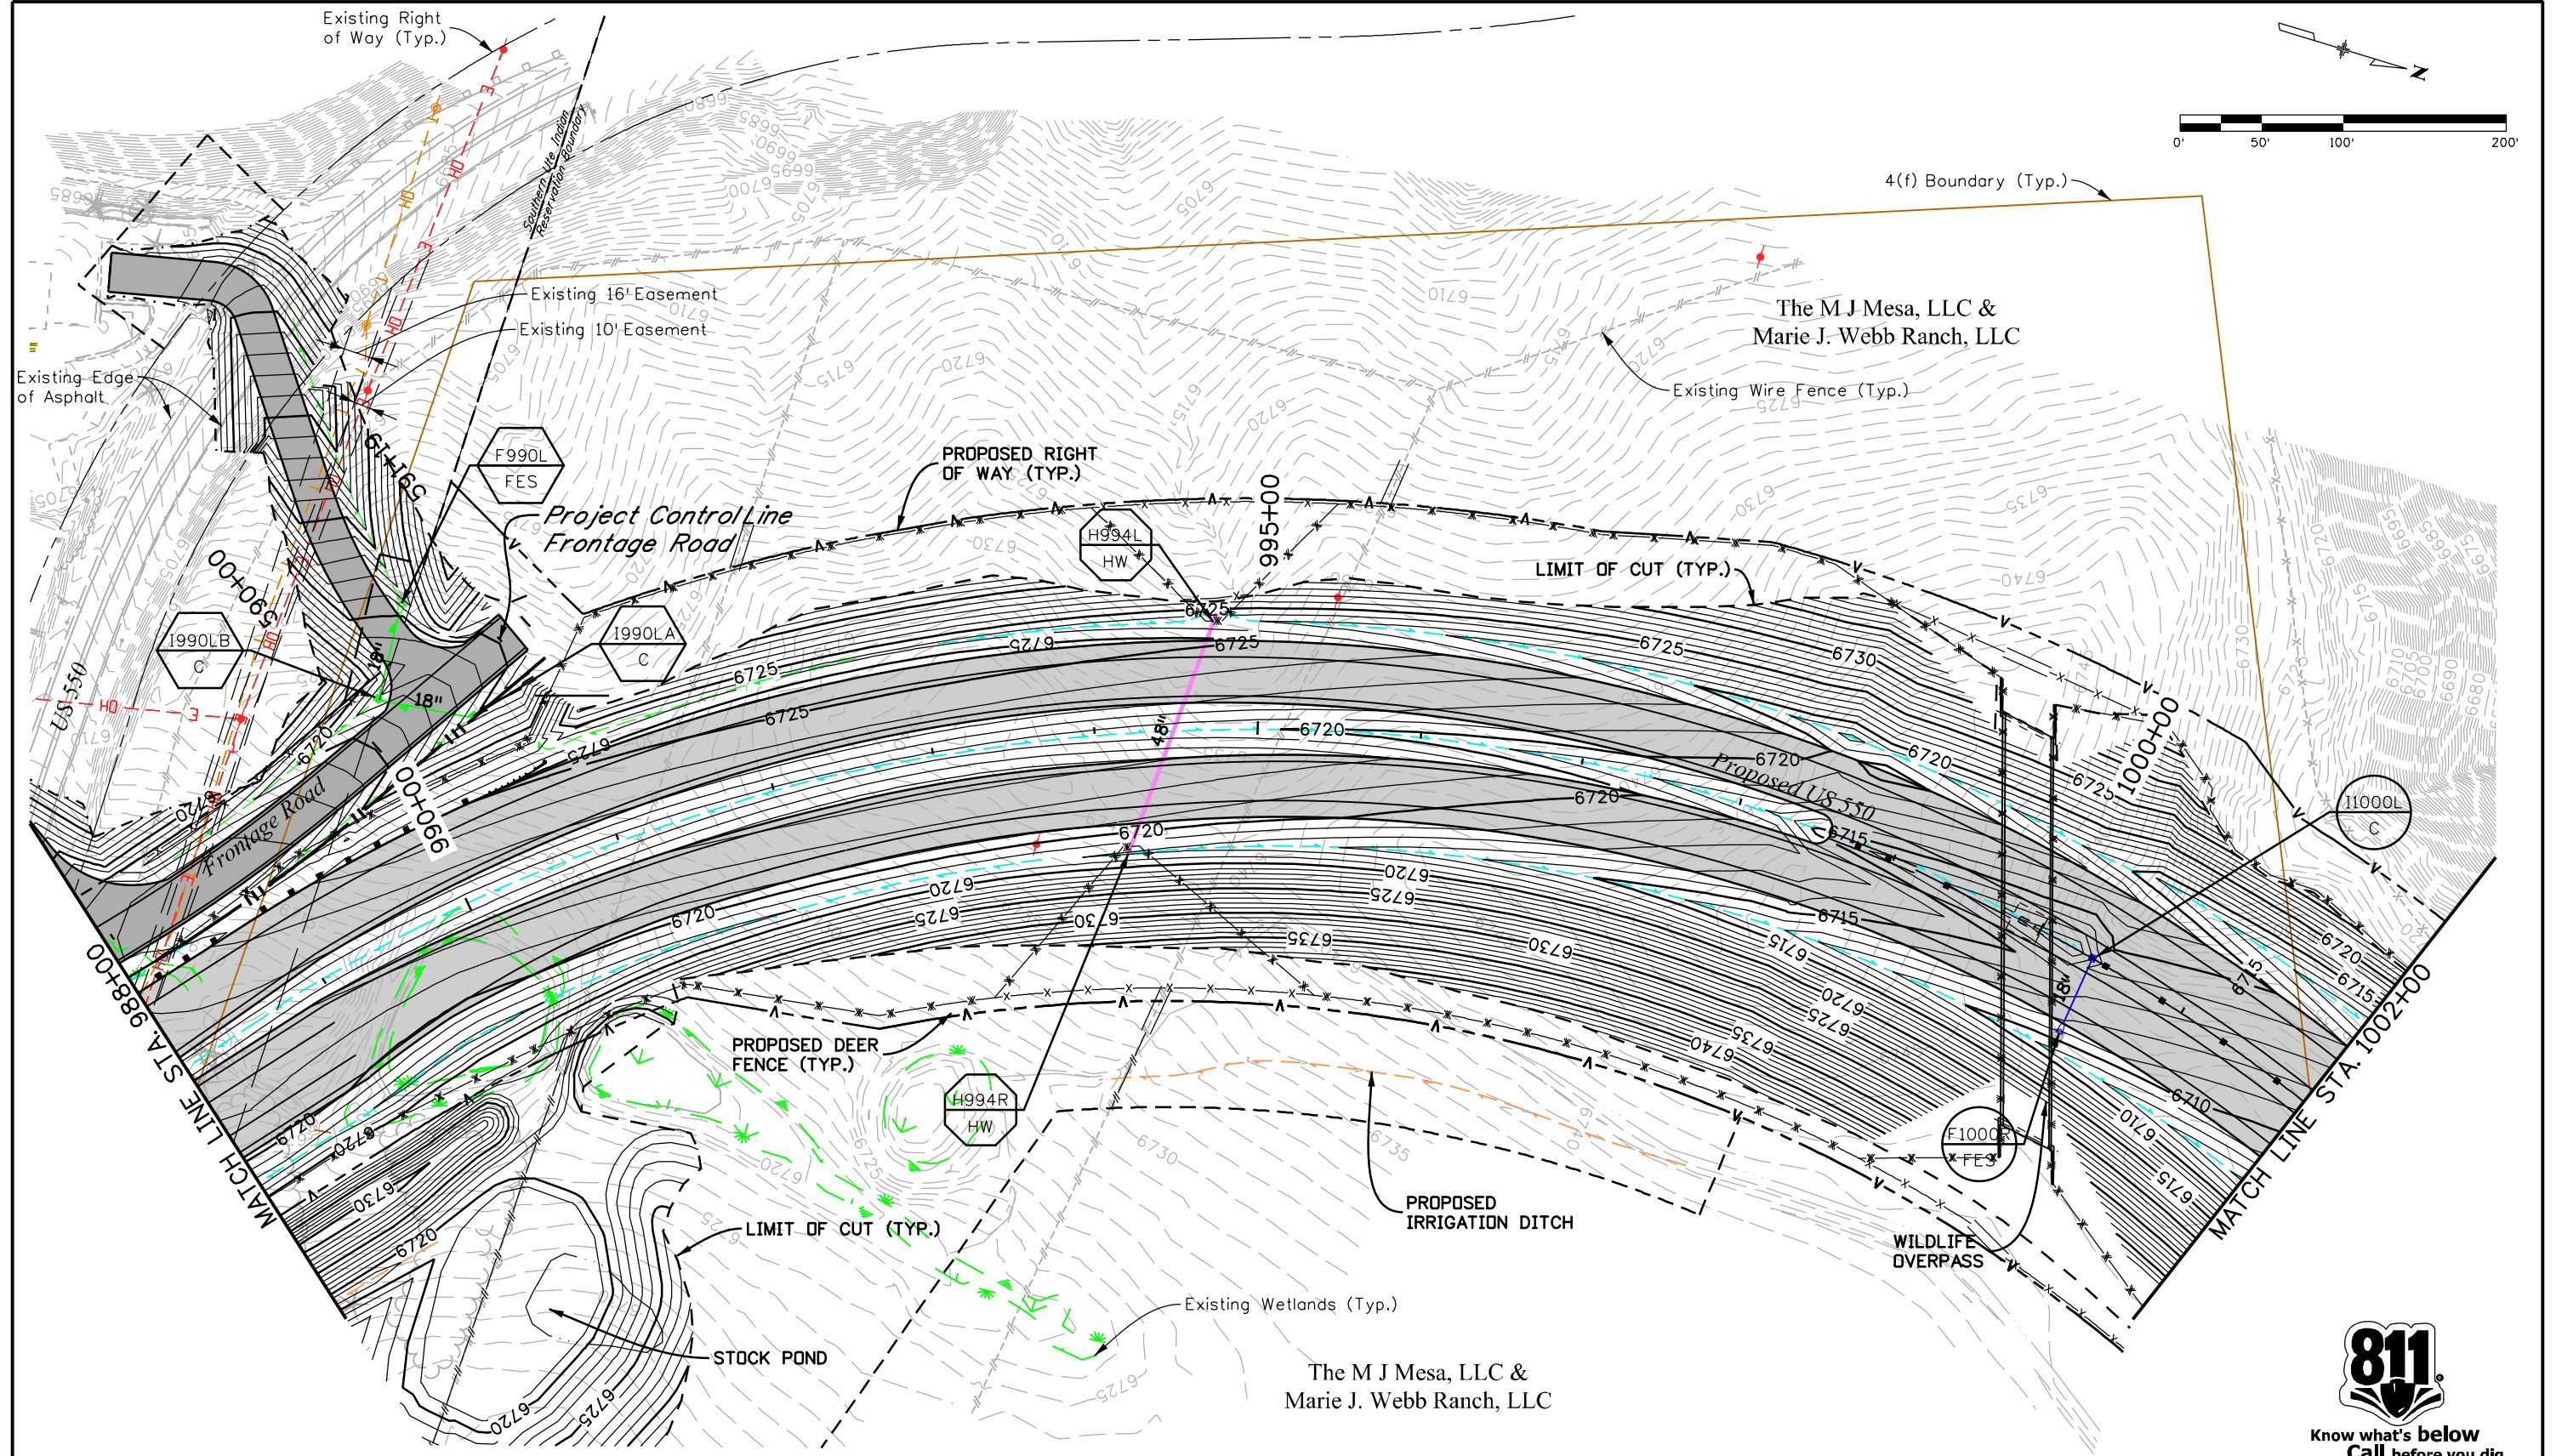

Print Date: 12/12/2018
Drawing File Name: 22420HYDR_Plan15.dgn
Horiz. Scale: 1:100 Vert. Scale: As Noted
Unit Information Unit Leader Initials
MULLER ENGINEERING COMPANY

Sheet Revisions		
Date:	Comments	Init.


Colorado Department of Transportation
 3803 North Main Avenue
 Suite 200
 Durango, CO 81301
 Phone: 970-385-1440 FAX: 970-385-8365
Region 5 **DRV**

As Constructed
No Revisions:
Revised:
Void:

US 550 DRAINAGE PLAN			
STA. 988+00 TO STA. 1002+00			
Designer:	WVW	Structure	
Detailer:	LMR	Numbers	
Sheet Subset:	DRAINAGE	Subset Sheets:	15 of 19

Project No./Code
Project Number
22420
Sheet Number

R:\Users\15914_PN\Projects\18-018.01 US 550, S. Connection D-B - CDDT R-5\22420\Hydraulics\Drawings\22420HYDR_Plan16.dgn
 12/12/2018 11:59:14 AM P:\2018\Projects\18-018.01 US 550, S. Connection D-B - CDDT R-5\22420\Hydraulics\Drawings\22420HYDR_Plan16.dgn
 CDDT-DefaultPrinter_V81.plt; CDDT_V81 CLR-UTL.tbl



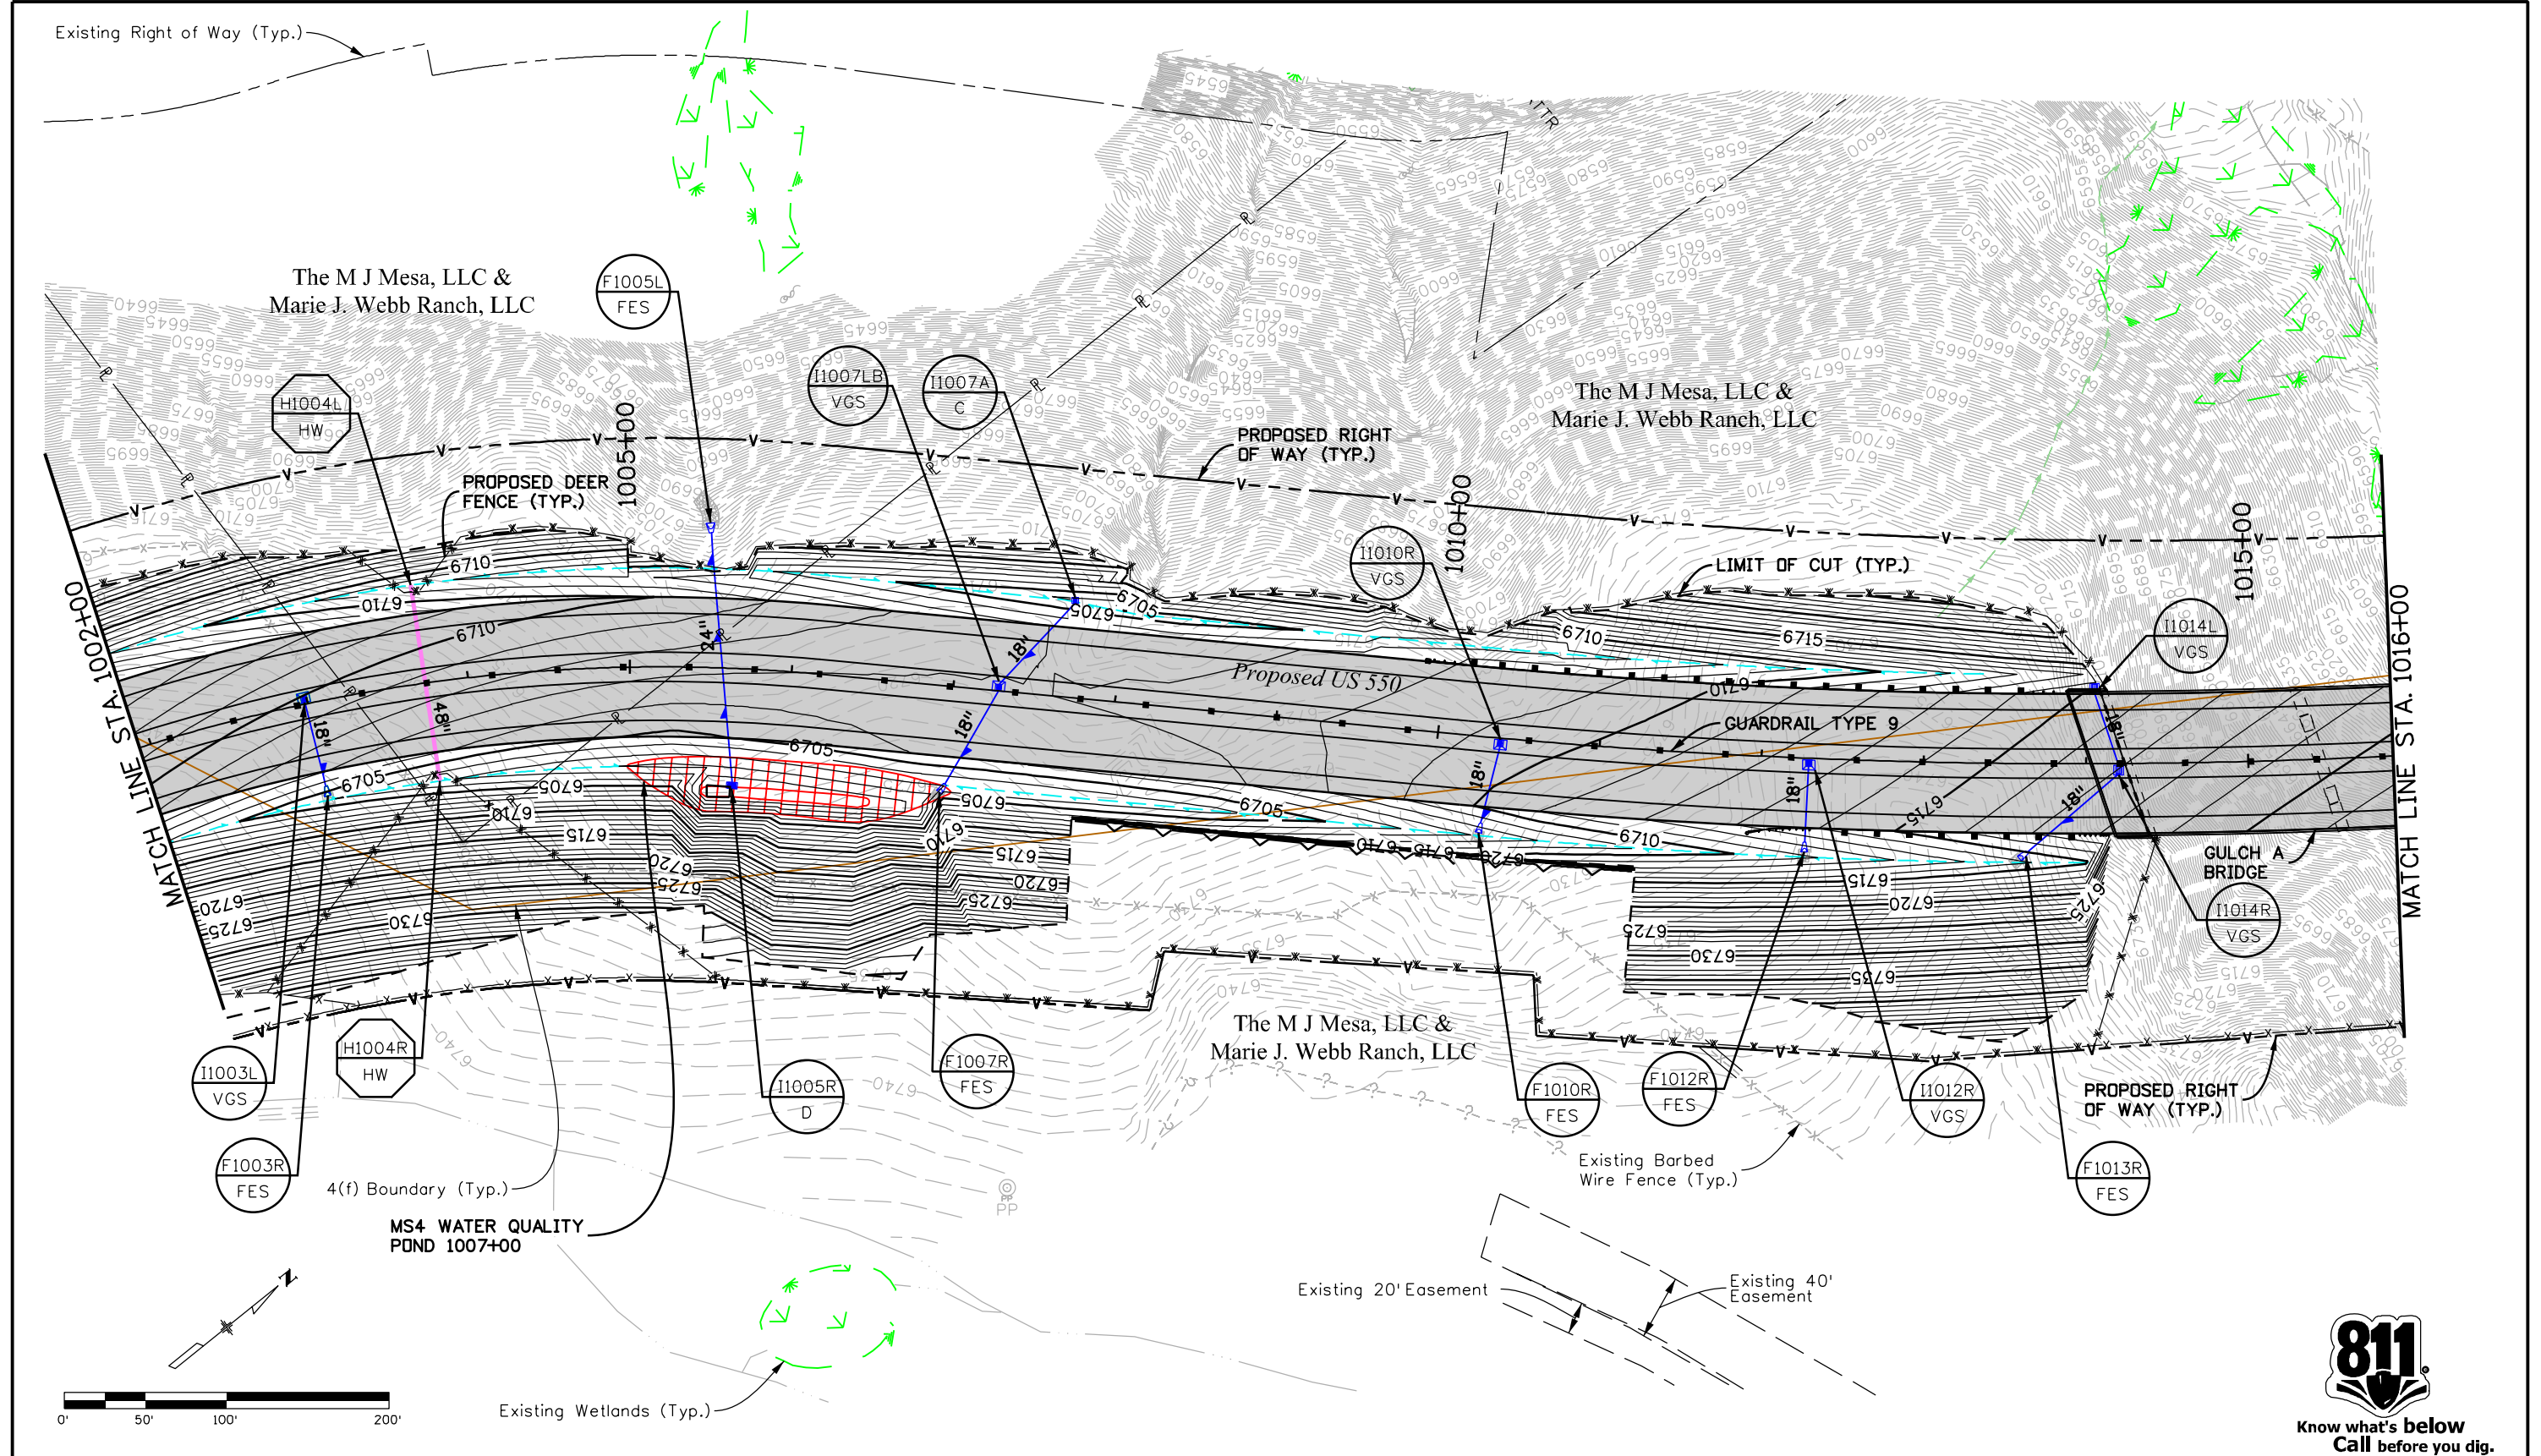


Know what's below
Call before you dig.

Print Date: 12/12/2018 Drawing File Name: 22420HYDR_Plan16.dgn Horiz. Scale: 1:100 Vert. Scale: As Noted Unit Information Unit Leader Initials		Sheet Revisions <table border="1"> <thead> <tr> <th>Date:</th> <th>Comments</th> <th>Init.</th> </tr> </thead> <tbody> <tr><td> </td><td> </td><td> </td></tr> <tr><td> </td><td> </td><td> </td></tr> <tr><td> </td><td> </td><td> </td></tr> </tbody> </table>		Date:	Comments	Init.										Colorado Department of Transportation  3803 North Main Avenue Suite 200 Durango, CO 81301 Phone: 970-385-1440 FAX: 970-385-8365 Region 5 DRV		As Constructed No Revisions: Revised: Void:		US 550 DRAINAGE PLAN STA. 1002+00 TO STA. 1016+00 Designer: WVV Structure Detailer: LMR Numbers Sheet Subset: DRAINAGE Subset Sheets: 16 of 19		Project No./Code Project Number 22420 Sheet Number	
Date:	Comments	Init.																					



  R:\wopous\159\22 PM P\2018 Projects\18-018.01 US 550 S Connection D-B - CDDT R-5\22420\Hydraulics\Drawings\22420HYDR_Plan17.dgn
 12/12/2018 11:59:22 AM P:\2018 Projects\18-018.01 US 550 S Connection D-B - CDDT R-5\22420\Hydraulics\Drawings\22420HYDR_Plan17.dgn
 CDDT-DevaulPrinter_V81.pctc CDDT V81 CLR-UTL.tbl

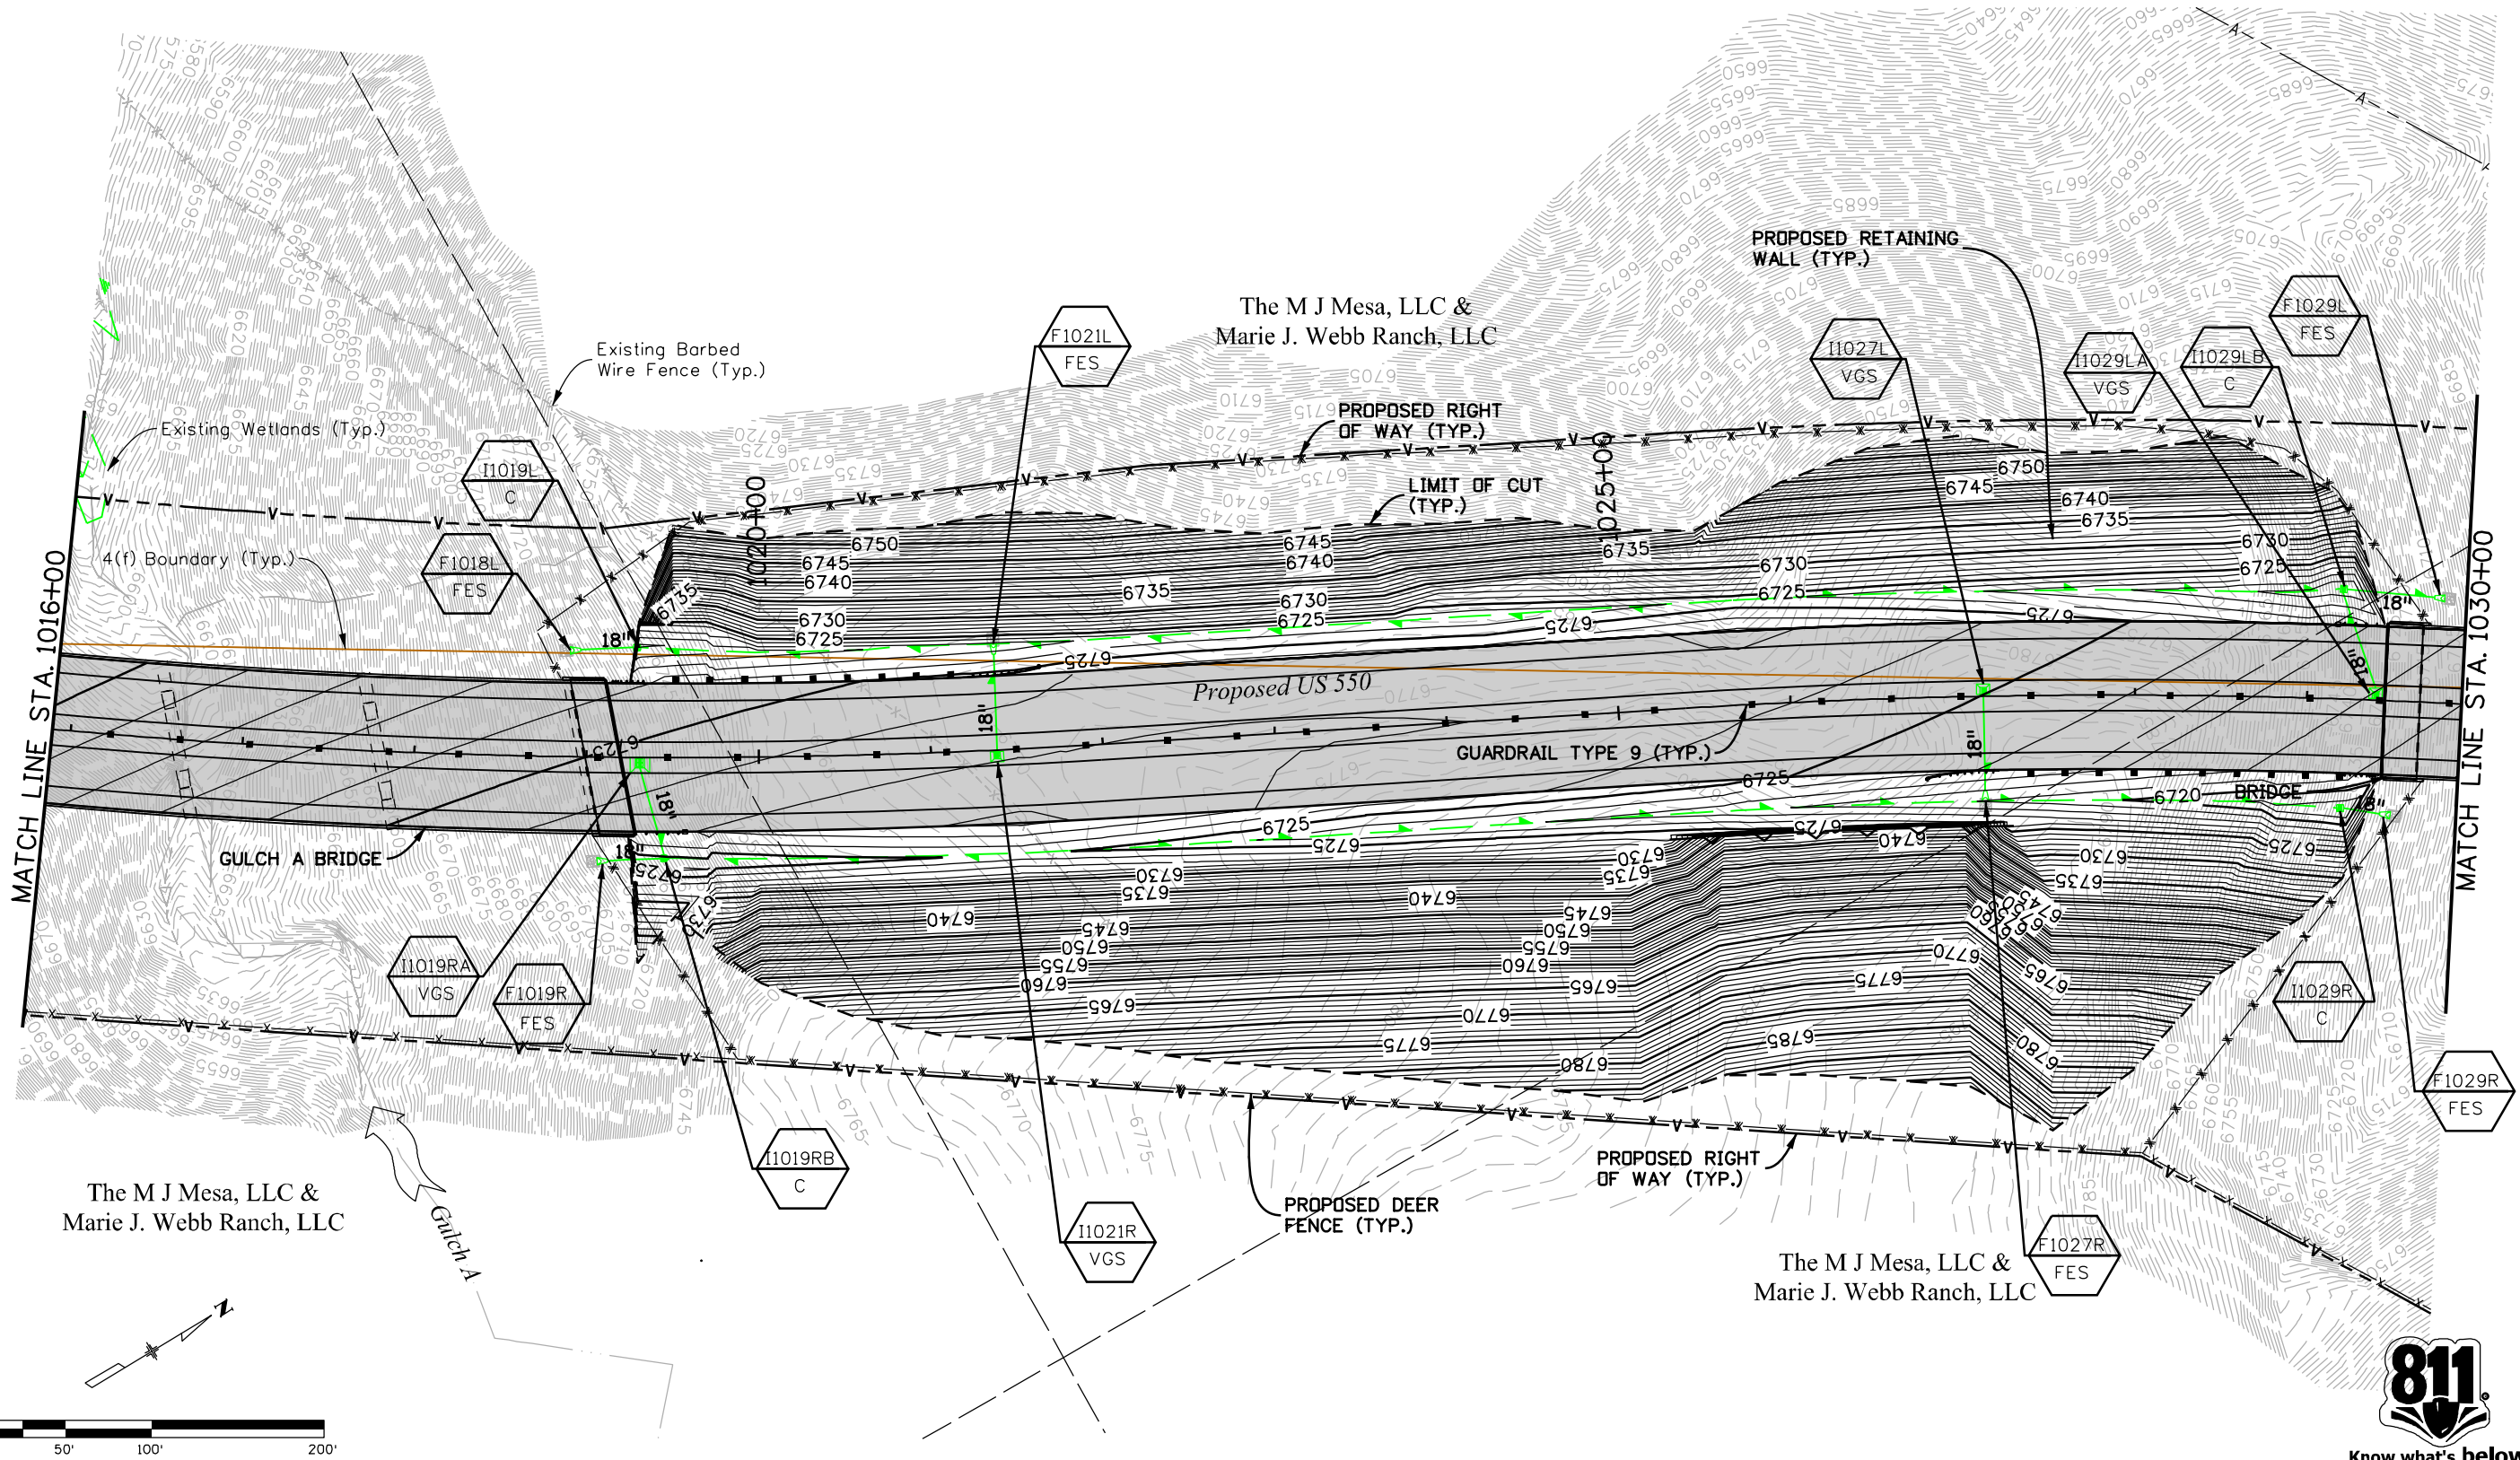

Print Date: 12/12/2018
Drawing File Name: 22420HYDR_Plan17.dgn
Horiz. Scale: 1:100 Vert. Scale: As Noted
Unit Information Unit Leader Initials
MULLER ENGINEERING COMPANY

Sheet Revisions		
Date:	Comments	Init.


Colorado Department of Transportation
 3803 North Main Avenue
 Suite 200
 Durango, CO 81301
 Phone: 970-385-1440 FAX: 970-385-8365
Region 5 **DRV**

As Constructed
No Revisions:
Revised:
Void:

US 550 DRAINAGE PLAN			
STA. 1016+00 TO STA. 1030+00			
Designer:	WVW	Structure	
Detailer:	LMR	Numbers	
Sheet Subset:	DRAINAGE	Subset Sheets:	17 of 19

Project No./Code
Project Number
22420
Sheet Number

R:\wopous 159930 PM P1\2018 Projects\18-018.01 US 550 S Connection D-B - CDOT R-5\22420\Hydraulics\Drawings\22420HYDR_Plan18.dgn
 12/12/2018 11:59:30 AM P1\2018 Projects\18-018.01 US 550 S Connection D-B - CDOT R-5\22420\Hydraulics\Drawings\22420HYDR_Plan18.dgn
 CDOT-DefaultPrinter_V81.plt:cdt V81 CLR-UTL.ttl

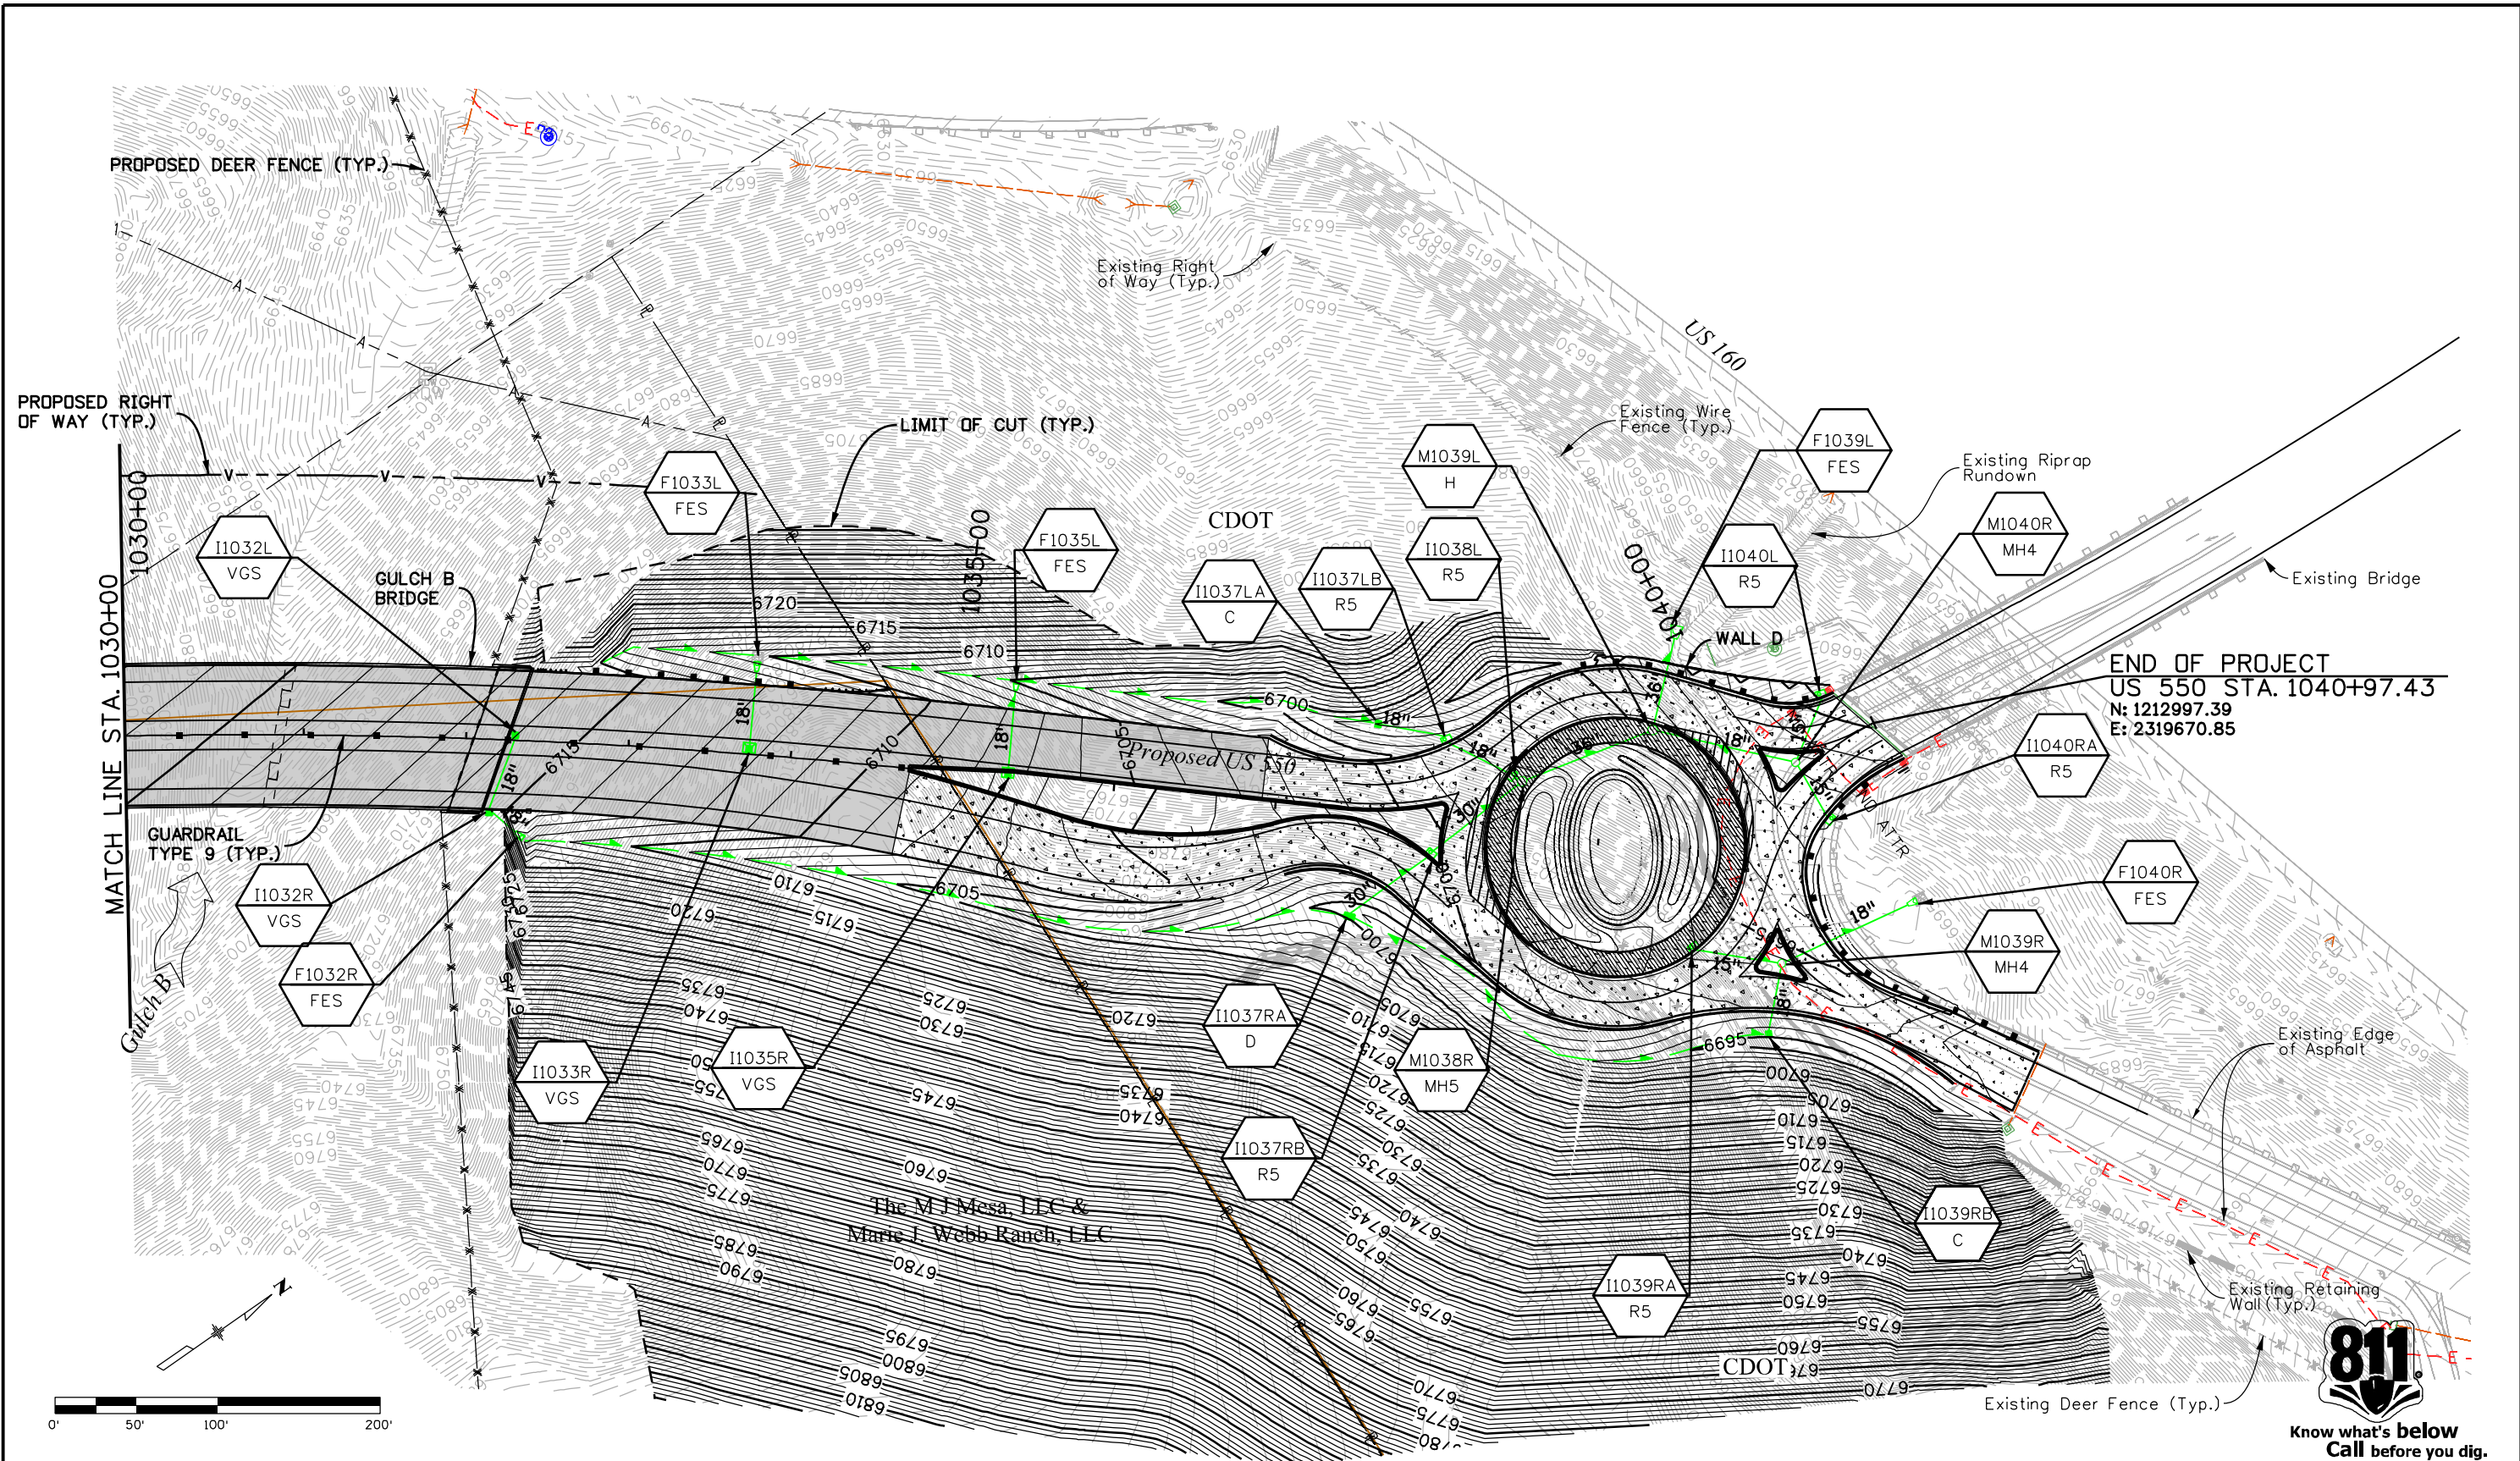


END OF PROJECT
 US 550 STA. 1040+97.43
 N: 1212997.39
 E: 2319670.85



Know what's below
 Call before you dig.

Print Date: 12/12/2018 Drawing File Name: 22420HYDR_Plan18.dgn		Sheet Revisions Date: Comments Init.		Colorado Department of Transportation 3803 North Main Avenue Suite 200 Durango, CO 81301 Phone: 970-385-1440 FAX: 970-385-8365		As Constructed No Revisions: Revised: Void:		US 550 DRAINAGE PLAN STA. 1030+00 TO STA. 1040+97.43		Project No./Code Project Number 22420	
Horiz. Scale: 1:100 Vert. Scale: As Noted Unit Information Unit Leader Initials				Region 5		DRV		Designer: WVV Structure Detailer: LMR Numbers		Sheet Subset: DRAINAGE Subset Sheets: 18 of 18 Sheet Number	

R:\2018 Projects\18-018.01 US 550 S Connection D-B - CDDT R-5\22420\Hydraulics Drawings\22420HYDR_Plan19 CR 220.dgn
 12/12/2018 2:00:42 PM P:\2018 Projects\18-018.01 US 550 S Connection D-B - CDDT R-5\22420\Hydraulics Drawings\22420HYDR_Plan19 CR 220.dgn
 CDDT-DefaultPrinter_V8i.pptcig CDDT V8I CLR-UTL.tbl

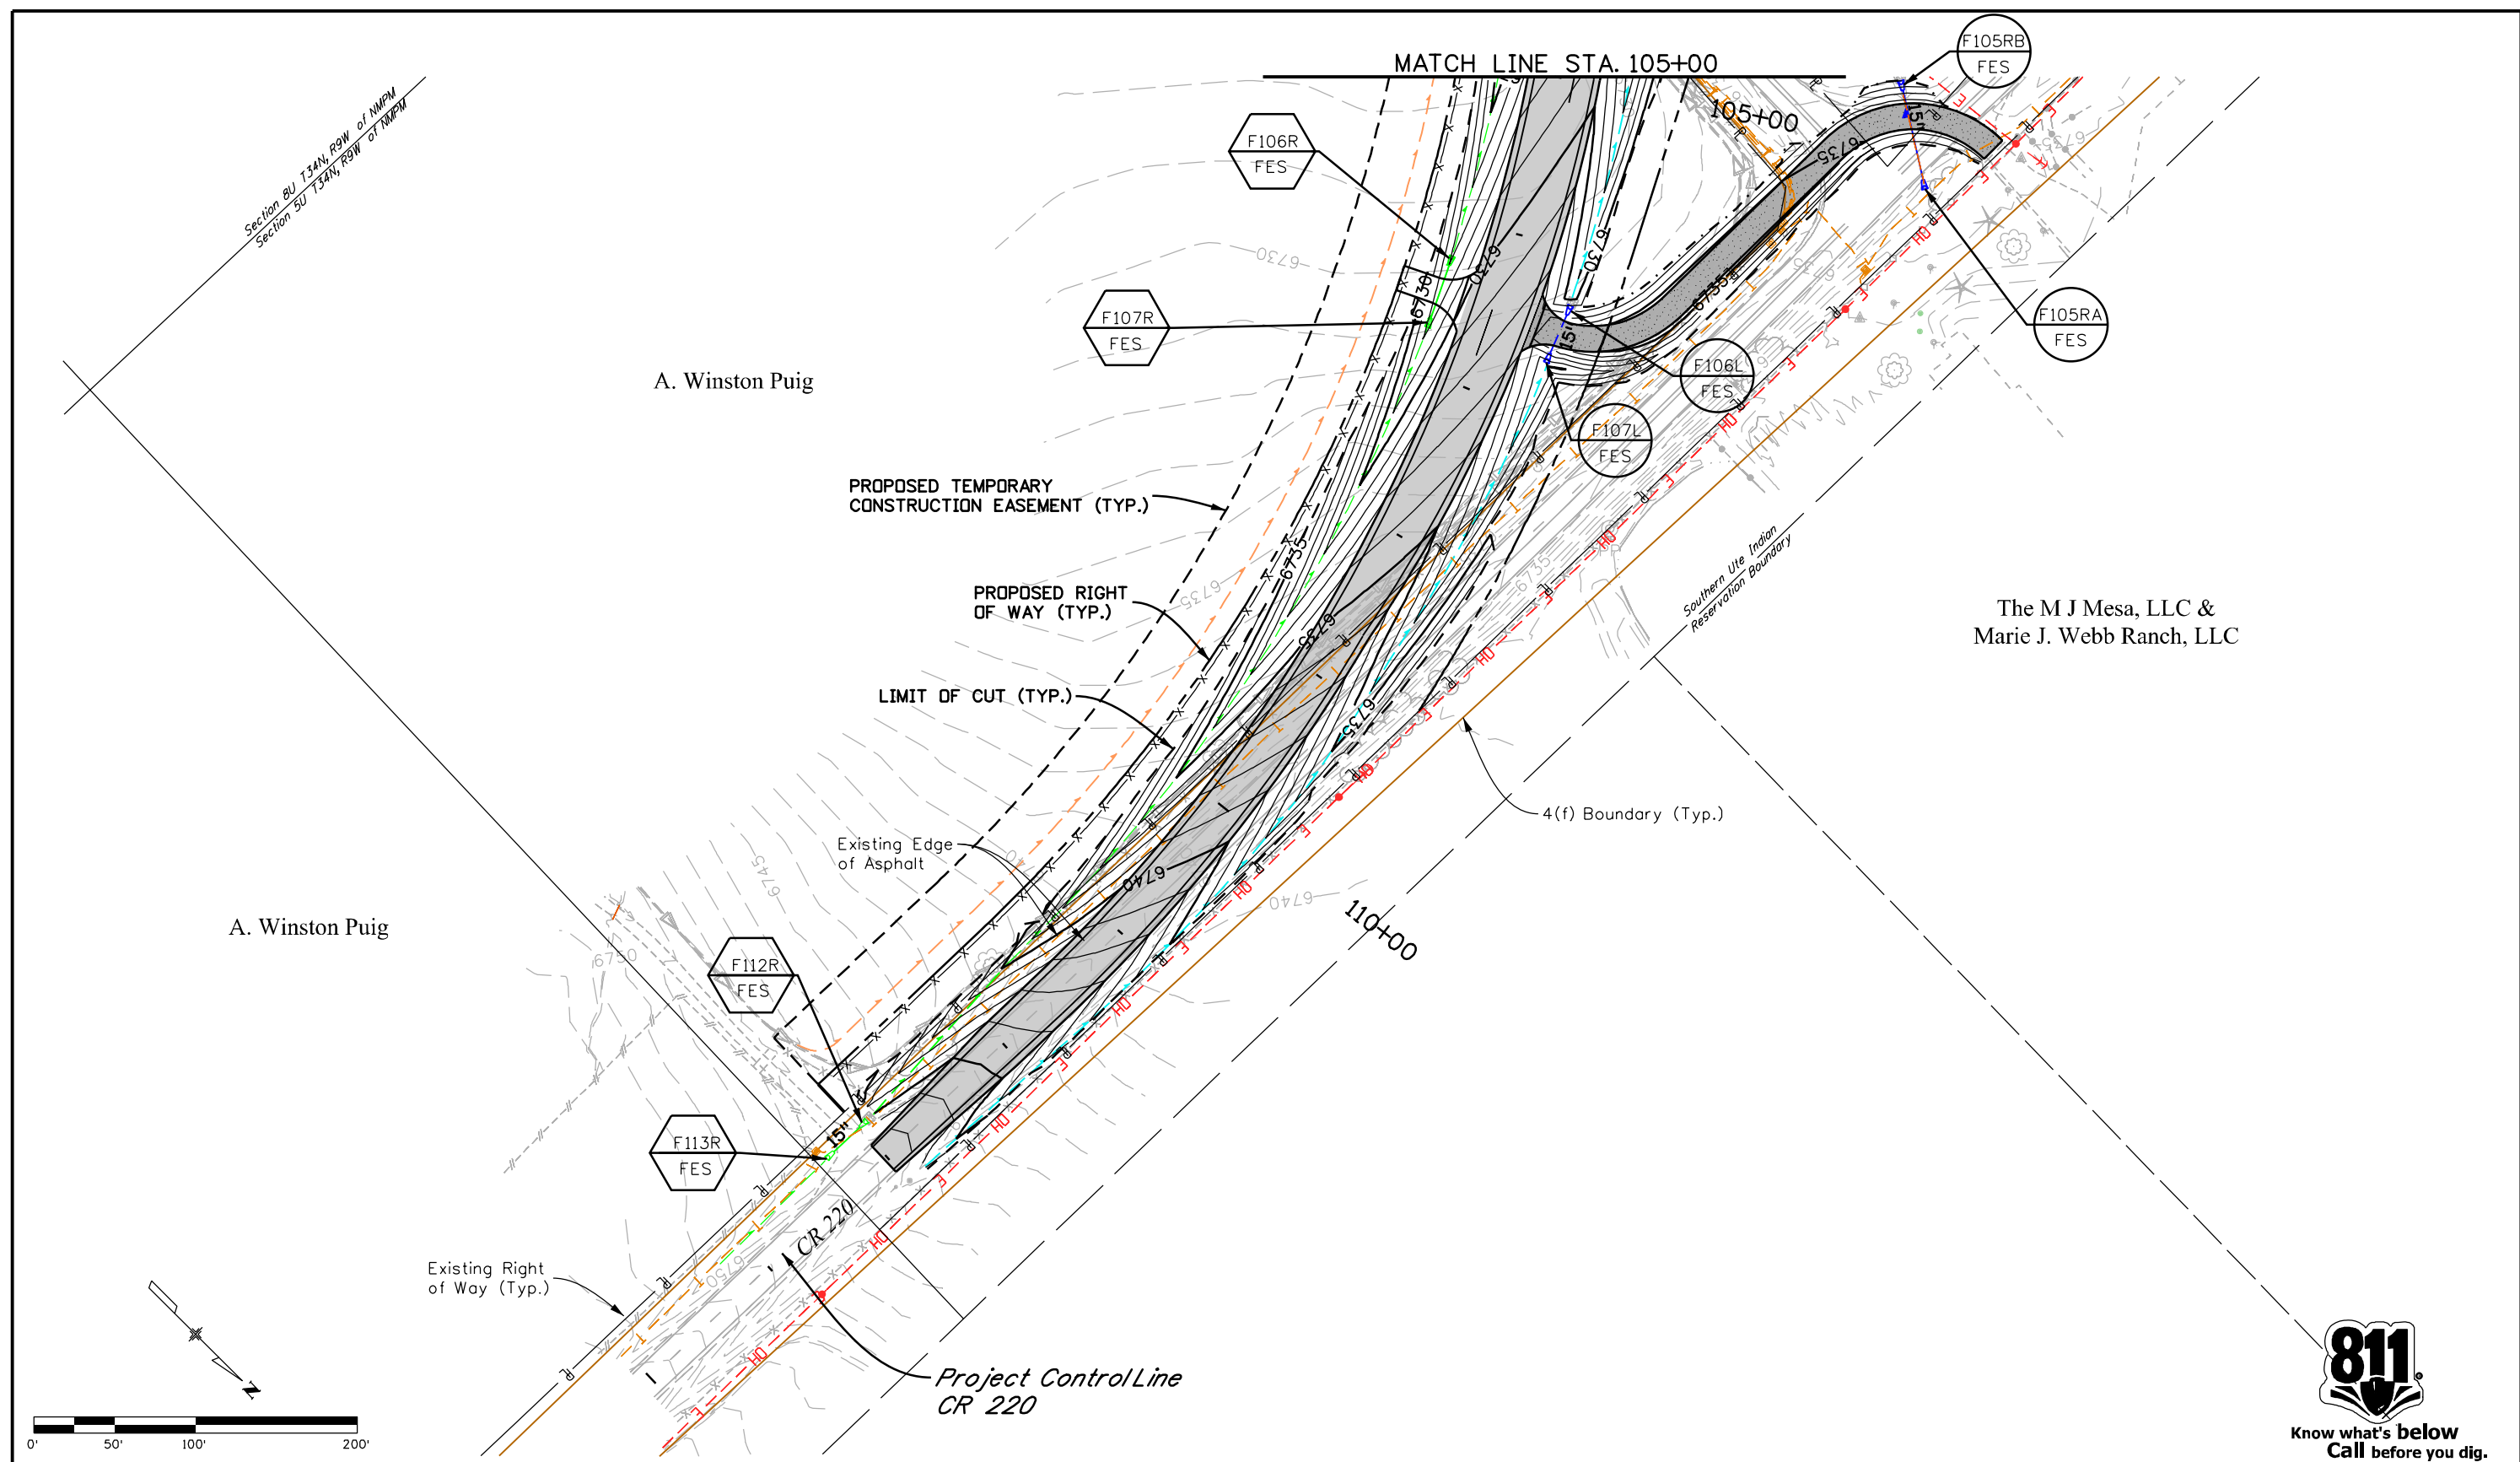

The M J Mesa, LLC &
Marie J. Webb Ranch, LLC



Know what's below
Call before you dig.

Print Date: 12/12/2018
Drawing File Name: 22420HYDR_Plan19 CR 220.dgn
Horiz. Scale: 1:100 Vert. Scale: As Noted
Unit Information Unit Leader Initials

Sheet Revisions		
Date:	Comments	Init.

Colorado Department of Transportation

 3803 North Main Avenue
 Suite 200
 Durango, CO 81301
 Phone: 970-385-1440 FAX: 970-385-8365
Region 5 **DRV**

As Constructed
No Revisions:
Revised:
Void:

DRAINAGE PLAN - CR 220			
STA. 105+00 TO STA. 115+00			
Designer:	WVW	Structure	
Detailer:	LMR	Numbers	
Sheet Subset:	DRAINAGE	Subset Sheets:	19 of 19

Project No./Code
Project Number
22420
Sheet Number