

DEPARTMENT OF TRANSPORTATION  
Region 6 Utilities Unit  
2000 South Holly Street  
Denver, Colorado 80222  
(303) 757-9910



### Utility Information Sheet (UIS)

PE Project No.: STA 1281-011; WBS #: 15782  
CN Project No.: ~~STU 1281-012~~ WBS #: 16501  
STA C800-001

**Project Description: 120<sup>th</sup> Avenue Connection- Phase I**  
Construct new 120<sup>th</sup> Avenue Connection alignment from Wadsworth Pkwy (SH 121) to Old Wadsworth Blvd. Construct new Commerce Street from Park Street to 118<sup>th</sup> Avenue. Also, minor realignment of Old Wadsworth Blvd.

**UIS #:** 03-002  
**Utility Company:** City and County of Broomfield (Public)

**Work Performed by:** Contractor

**Location:** 120th Sta. 62+00 to 62+30



**Existing Utility:** 16" Water Line

**Expected Impact:** The Contractor shall design and construct waterline relocation. The line will be realigned by intercepting the 16" water line in Allison north of 120<sup>th</sup> Connection, run west along the north toe of fill and proceed south in proposed Commerce Street. The water line in proposed Commerce St. under the 120<sup>th</sup> Connection Bridge shall be sleeved to protect the bridge and retaining walls, the length of the sleeve shall be finalized by the Design Build Contactor. Once the new 16" water line has been completed and operational, the abandoned water line shall be removed.

**Attached:** Plan Sheet

CDOT Representative: Ron Dickey 7-3-2008  
Ron Dickey – Region 6 Utility Manager Date

Utility Representative: Burt Knight 7/2/08  
(Print name): Burt Knight Date

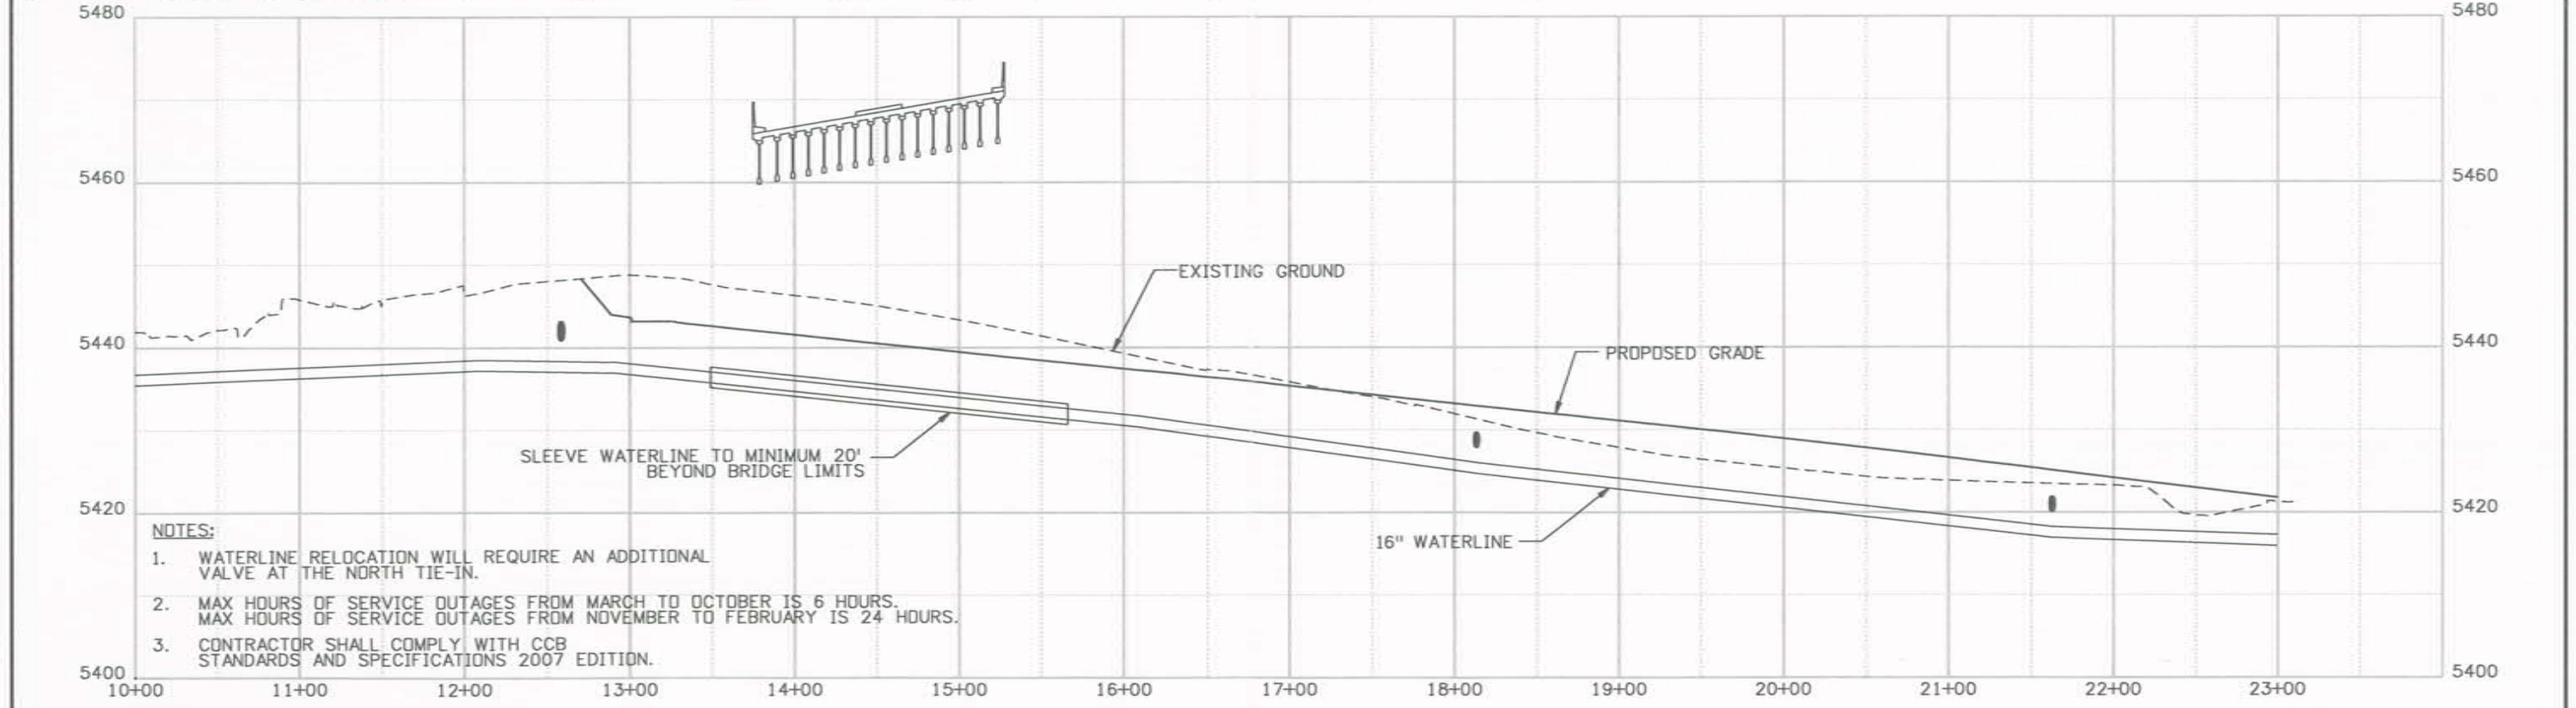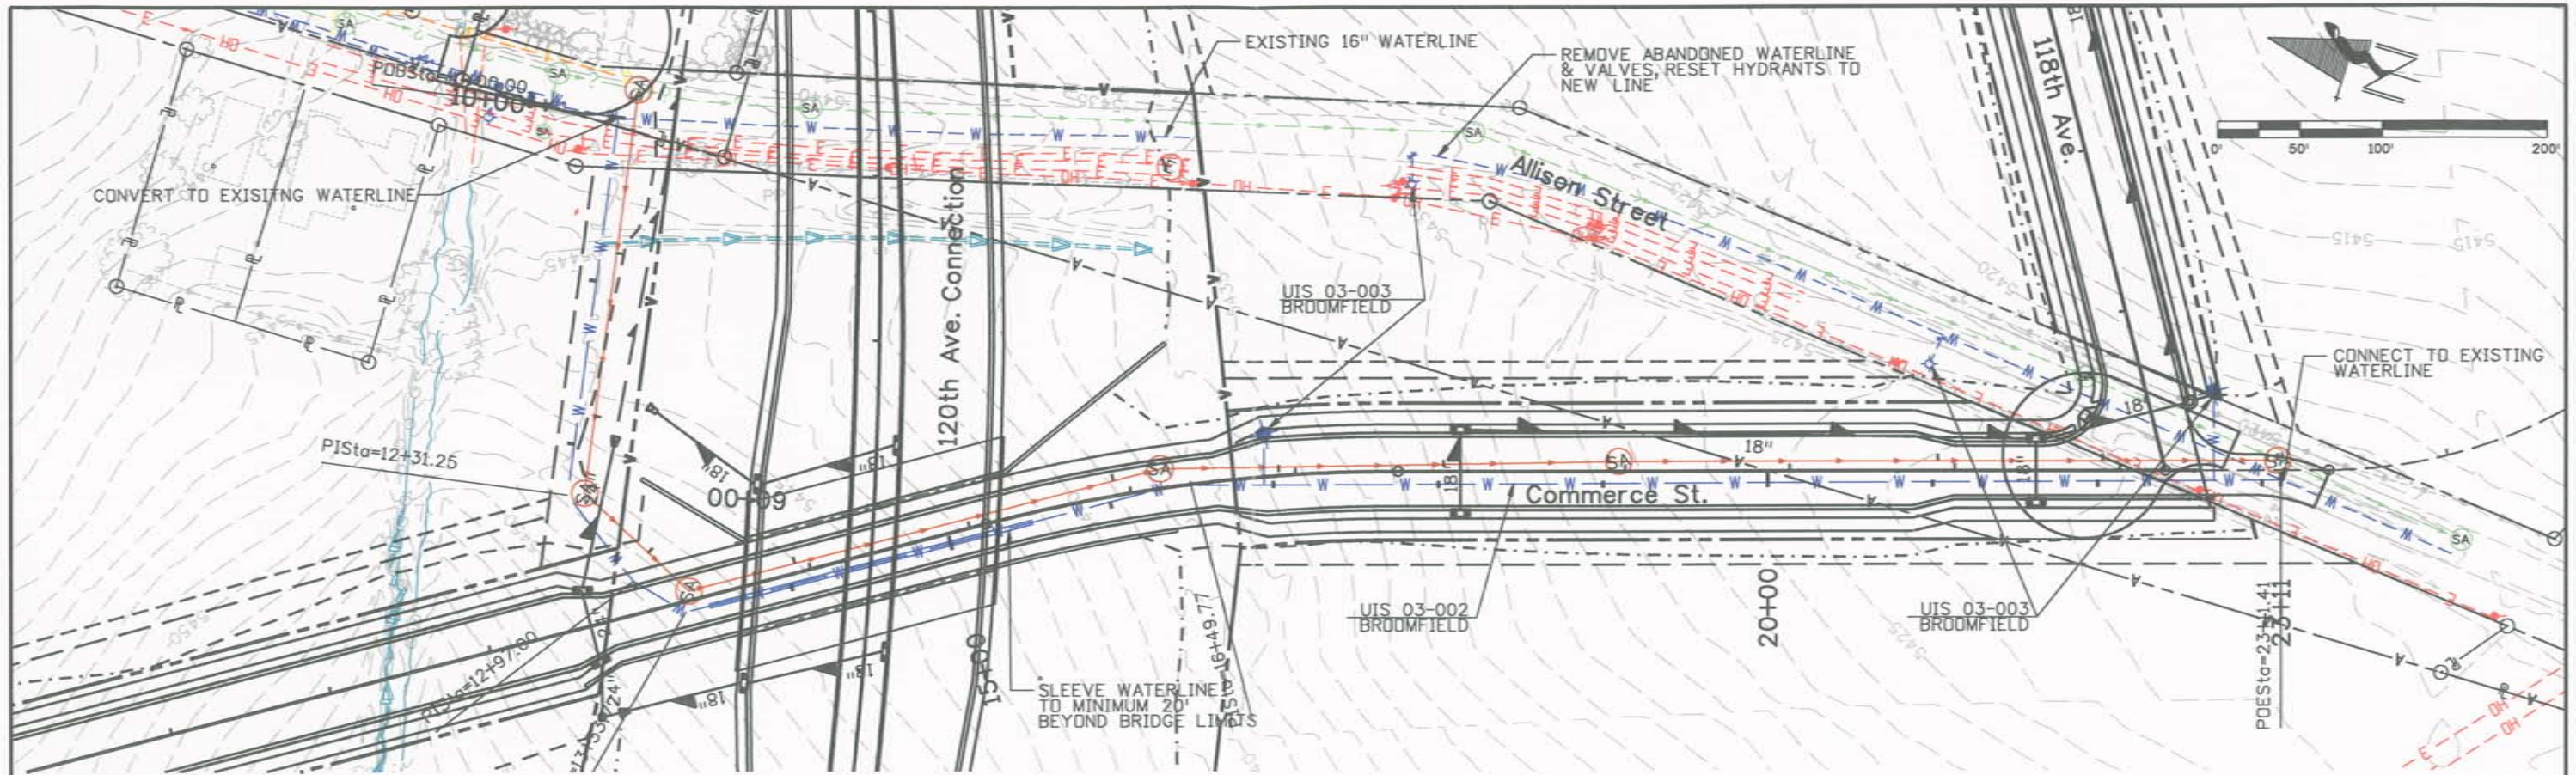

- NOTES:**
1. WATERLINE RELOCATION WILL REQUIRE AN ADDITIONAL VALVE AT THE NORTH TIE-IN.
  2. MAX HOURS OF SERVICE OUTAGES FROM MARCH TO OCTOBER IS 6 HOURS.  
MAX HOURS OF SERVICE OUTAGES FROM NOVEMBER TO FEBRUARY IS 24 HOURS.
  3. CONTRACTOR SHALL COMPLY WITH CCB STANDARDS AND SPECIFICATIONS 2007 EDITION.

Print Date: 10/9/2008		<b>Sheet Revisions</b>			<b>Colorado Department of Transportation</b>  4670 Holly Street Denver, CO 80216-6408 Phone: 303-398-6765 FAX: 303-398-6781 <b>Region 6</b>	<b>As Constructed</b>		<b>WATER LINE - COMMERCE ST</b>		<b>Project No./Code</b>		
File Name: 15782WaterLine01.dgn		Date:	Comments:	Init.		No Revisions:		PLAN AND PROFILE		STA C800-001		
Horiz. Scale: 1:100						Revised:	Designer: EN	Structure Numbers: X-XX-XX	16501		Sheet Number	
Unit Information		Vert. Scale: As Noted				Void:	Detailer: EN	Subset Sheets: 08 of 10	40			

15782WaterLine01.dgn 10/9/2008 10:00:00 AM J:\15782WaterLine01.dgn 15782WaterLine01.dgn 10/9/2008 10:00:00 AM