

M.P. 286.25

M.P. 286.45

M.P. 286.50

Print Date: 4/30/2014
File Name: 19191 Proposed Roadway Sheet01-01.dgn
Horiz. Scale: 1:100 Vert. Scale: As Noted
Unit Information Unit Leader Initials

Sheet Revisions		
Date:	Comments	Init.

Colorado Department of Transportation



2000 South Holly Street
 Denver, CO 80222
 Phone: 303-757-9511 FAX: 303-757-9907

Region 1 Traffic and Safety LR

As Constructed
No Revisions:
Revised:
Void:


PROPOSED ROADWAY PLAN			
Designer:	Guy Norris	Structure Numbers	X-XX-XX
Detailer:	BMc	Structure Numbers	X-XX-XX
Sheet Subset:	Roadway	Subset Sheets:	01 of 08

Project No./Code
SHE 2873-167
19191
Sheet Number 16

mcghyhb 2:01:26 PM c:\projectwise\pwrz\working\0375043\19191 Proposed Roadway Sheet01-01.dgn



Know what's below.
Call before you dig.

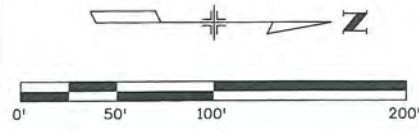

mcghghyb 2:03:43 PM c:\projectwise\pwworking\0375043\19191 Proposed Roadway Sheet01-02.dgn

Print Date: 4/30/2014	
File Name: 19191 Proposed Roadway Sheet01-02.dgn	
Horiz. Scale: 1:100	Vert. Scale: As Noted
Unit Information	Unit Leader Initials

0000

Sheet Revisions		
Date:	Comments	Init.

Colorado Department of Transportation
 2000 South Holly Street
 Denver, CO 80222
 Phone: 303-757-9511 FAX: 303-757-9907
 Region 1 Traffic and Safety LR



As Constructed	
No Revisions:	
Revised:	
Void:	

PROPOSED ROADWAY PLAN			
Designer:	Guy Norris	Structure Numbers	X-XX-XX
Detailer:	BMc	Structure Numbers	X-XX-XX
Sheet Subset:	Roadway	Subset Sheets:	02 of 08

Project No./Code	
SHE 2873-167	
19191	
Sheet Number	17



Know what's below.
Call before you dig.

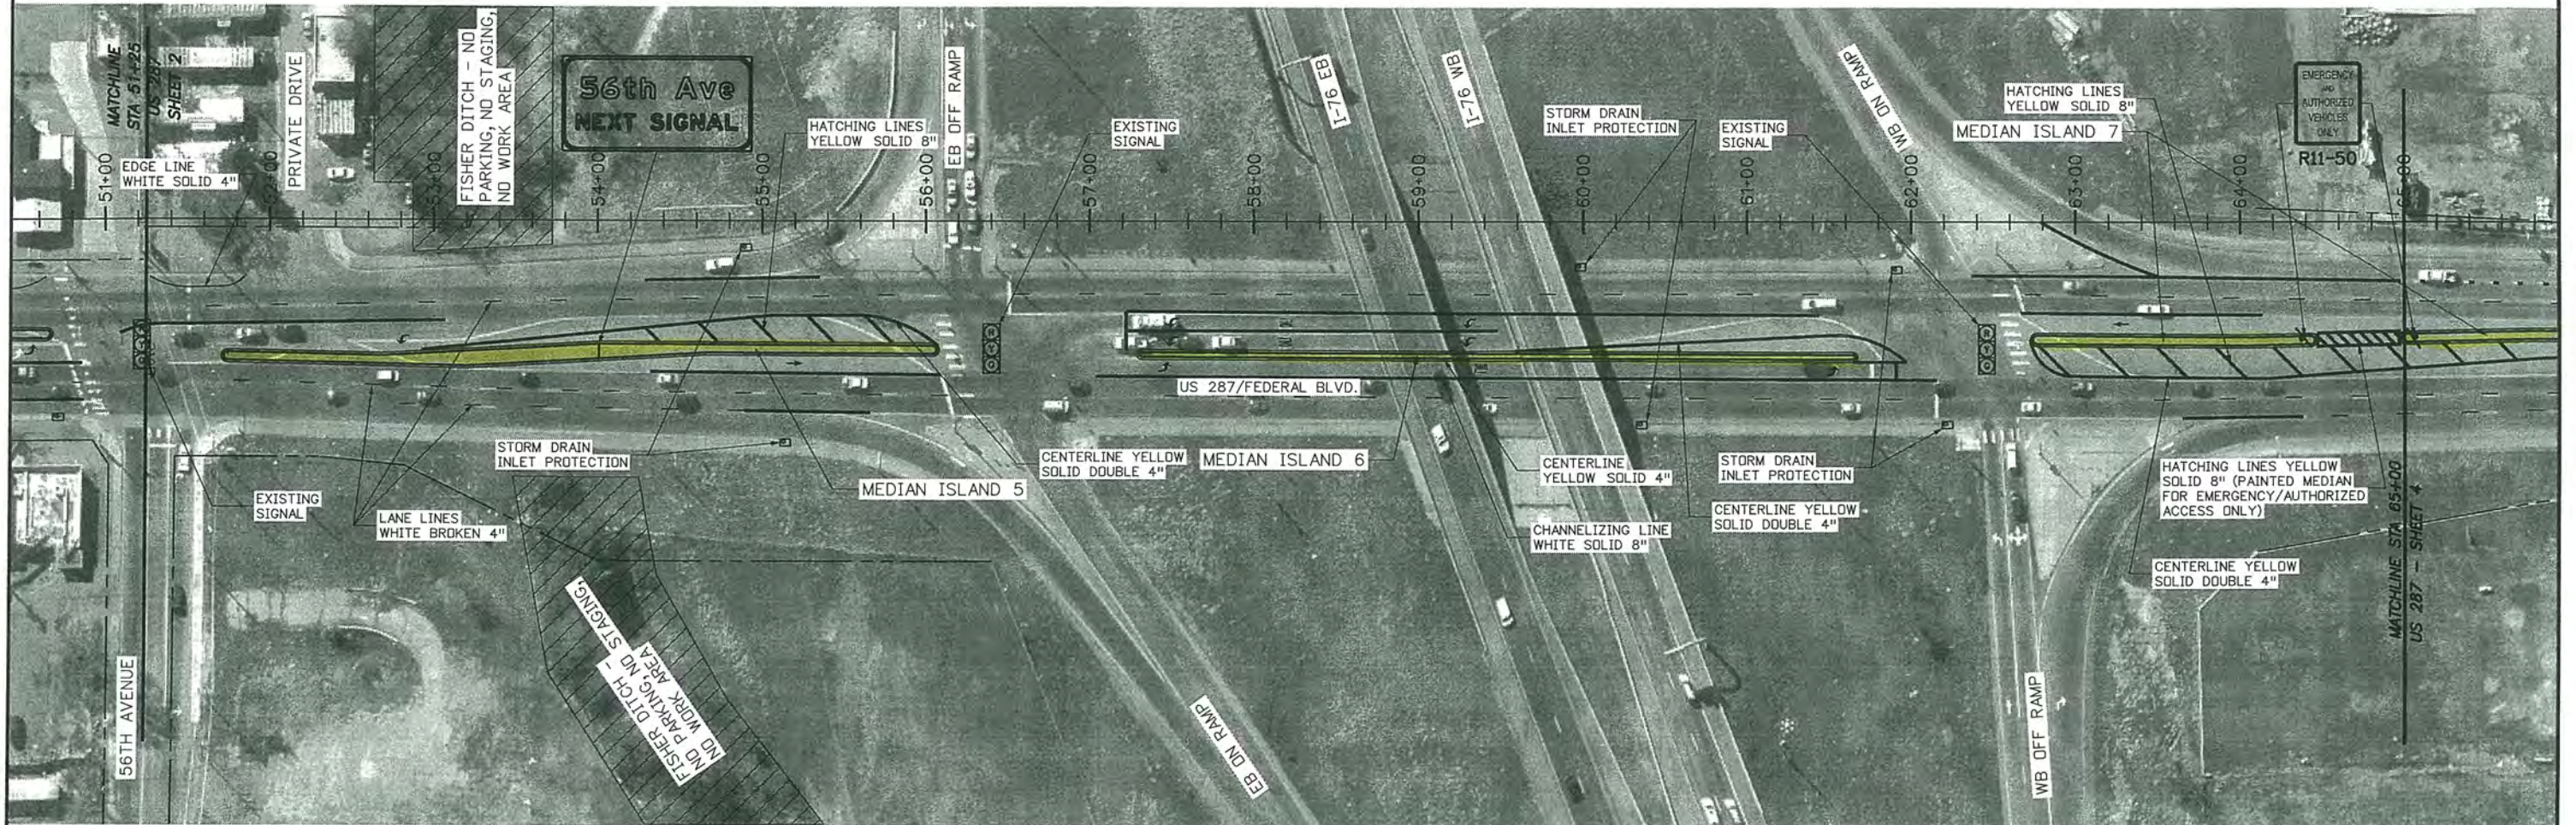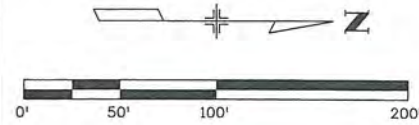

M.P. 286.76

M.P. 286.84

M.P. 286.91

M.P. 287.03

Print Date: 4/30/2014

File Name: 19191 Proposed Roadway Sheet01-03.dgn

Horiz. Scale: 1:100 Vert. Scale: As Noted

Unit Information Unit Leader Initials

0000

Sheet Revisions

Date:	Comments	Init.

Colorado Department of Transportation



2000 South Holly Street
Denver, CO 80222
Phone: 303-757-9511 FAX: 303-757-9907

Region 1 Traffic and Safety LR

As Constructed

No Revisions:

Revised:

Void:

PROPOSED ROADWAY PLAN

Designer:	Guy Norris	Structure	X-XX-XX
Detailer:	BMc	Numbers	X-XX-XX
Sheet Subset:	Roadway	Subset Sheets:	03 of 08

Project No./Code

SHE 2873-167

19191

Sheet Number 18

mcgahyhb 2:05:05 PM c:\projectwise\pwz\working\037504\3\19191 Proposed Roadway Sheet01-03.dgn




Know what's below.
Call before you dig.



M.P. 287.13

M.P. 287.17

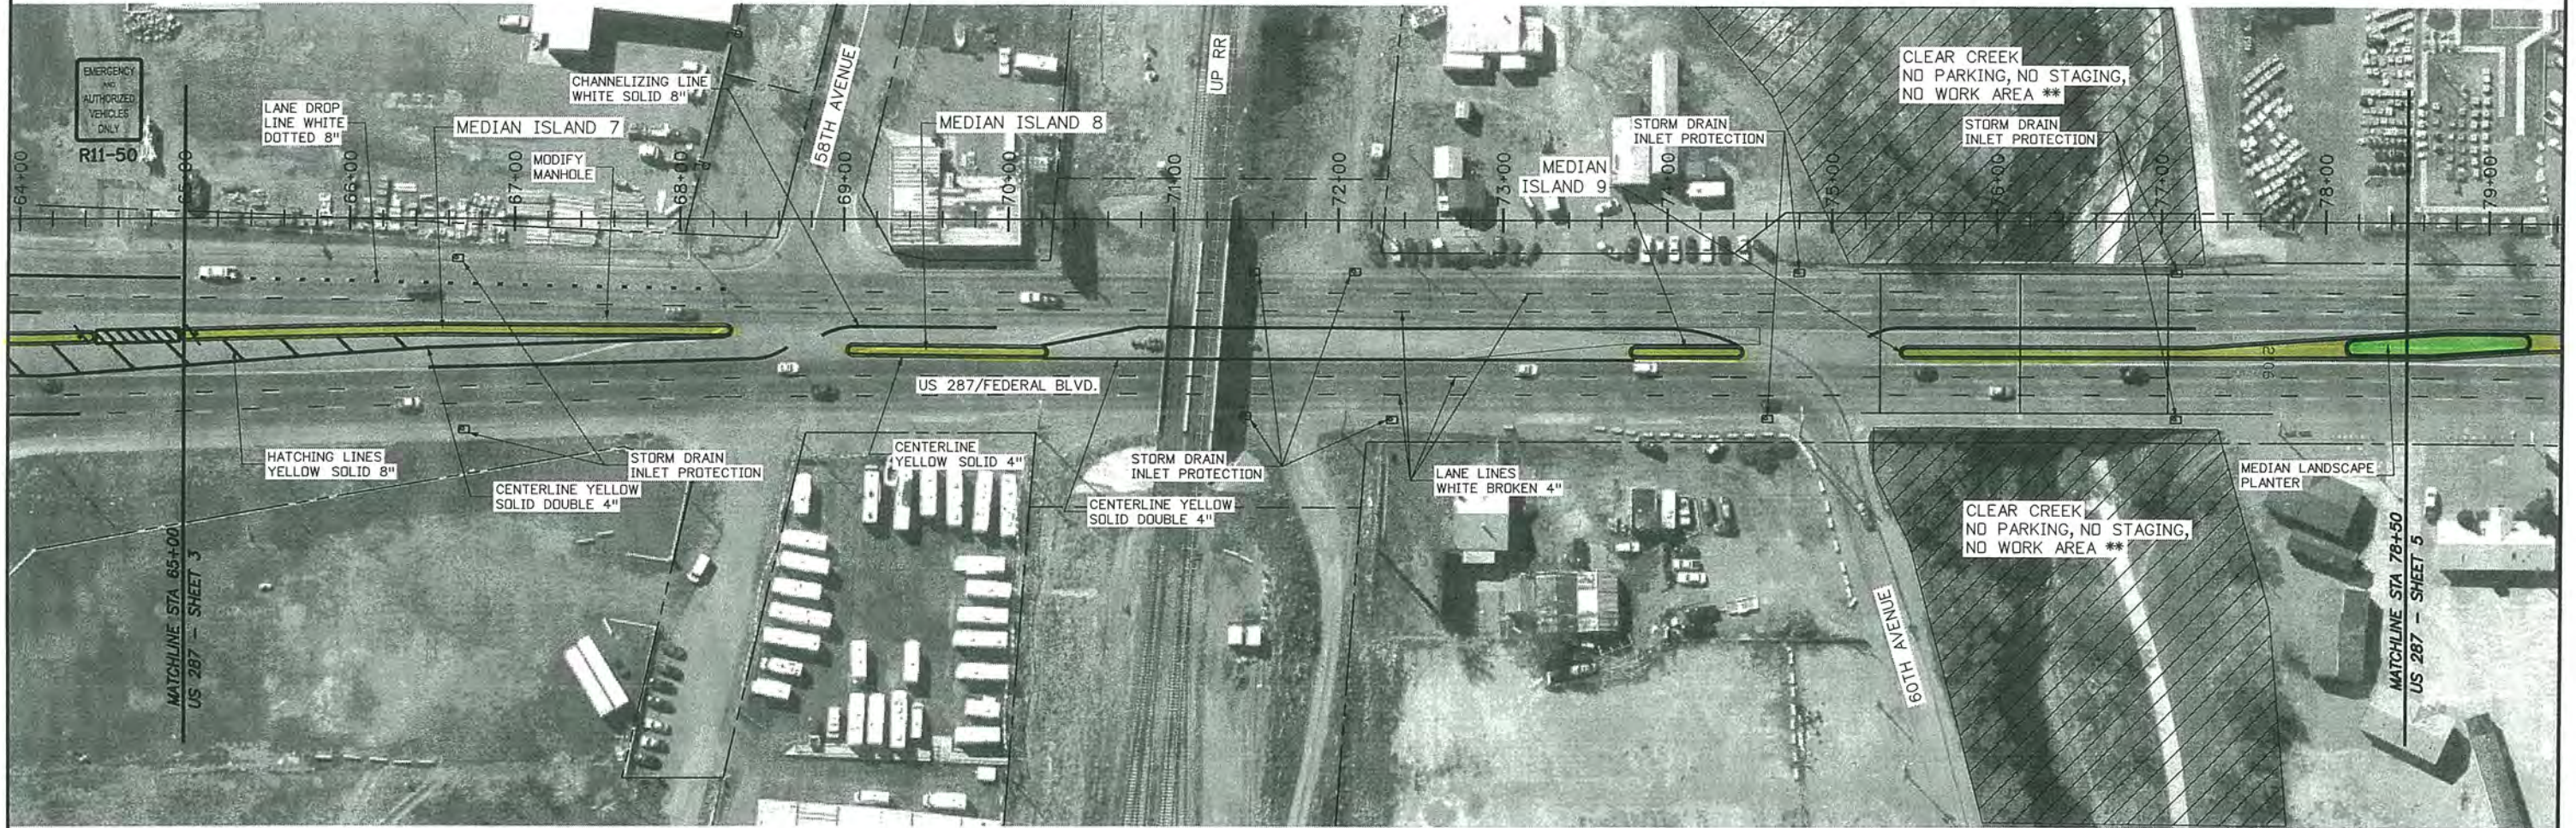

M.P. 287.25

M.P. 287.27

**** NOTE:**
WORK IN THIS AREA TO BE ALLOWED ONLY FOR INSTALLATION OF UNDER-DECK TRAIL LIGHTING, AS DIRECTED BY THE ENGINEER. TRAIL ACCESS TO BE MAINTAINED AT ALL TIMES. SEE STRUCTURE AND LIGHTING PLANS FOR ADDITIONAL INFORMATION.

mcnghyhb 2:29:07 PM c:\projects\wise\pwworking\0375043\19191 Proposed Roadway Sheet01-04.dgn

Print Date: 4/30/2014
File Name: 19191 Proposed Roadway Sheet01-04.dgn
Horiz. Scale: 1:100 Vert. Scale: As Noted
Unit Information Unit Leader Initials

0000

Sheet Revisions		
Date:	Comments	Init.

Colorado Department of Transportation



2000 South Holly Street
Denver, CO 80222
Phone: 303-757-9511 FAX: 303-757-9907

Region 1 Traffic and Safety LR


As Constructed
No Revisions:
Revised:
Void:

PROPOSED ROADWAY PLAN			
Designer:	Guy Norris	Structure	X-XX-XX
Detailer:	BMc	Numbers	X-XX-XX
Sheet Subset:	Roadway	Subset Sheets:	04 of 08

Project No./Code
SHE 2873-167
19191
Sheet Number 19



 Know what's below.
Call before you dig.



mcghghyb 2:31:27 PM c:\projectwise\pwz_working\0375043\19191 Proposed Roadway Sheet01-05.dgn

Print Date: 4/30/2014
File Name: 19191 Proposed Roadway Sheet01-05.dgn
Horiz. Scale: 1:100 Vert. Scale: As Noted
Unit Information Unit Leader Initials



Sheet Revisions		
Date:	Comments	Init.

Colorado Department of Transportation



2000 South Holly Street
Denver, CO 80222
Phone: 303-757-9511 FAX: 303-757-9907

Region 1 Traffic and Safety LR

As Constructed
No Revisions:
Revised:
Void:

PROPOSED ROADWAY PLAN			
Designer:	Guy Norris	Structure	X-XX-XX
Detailer:	BMc	Numbers	X-XX-XX
Sheet Subset:	Roadway	Subset Sheets:	05 of 08


Project No./Code
SHE 2873-167
19191
Sheet Number 20



Know what's below.
Call before you dig.



M.P. 287.64

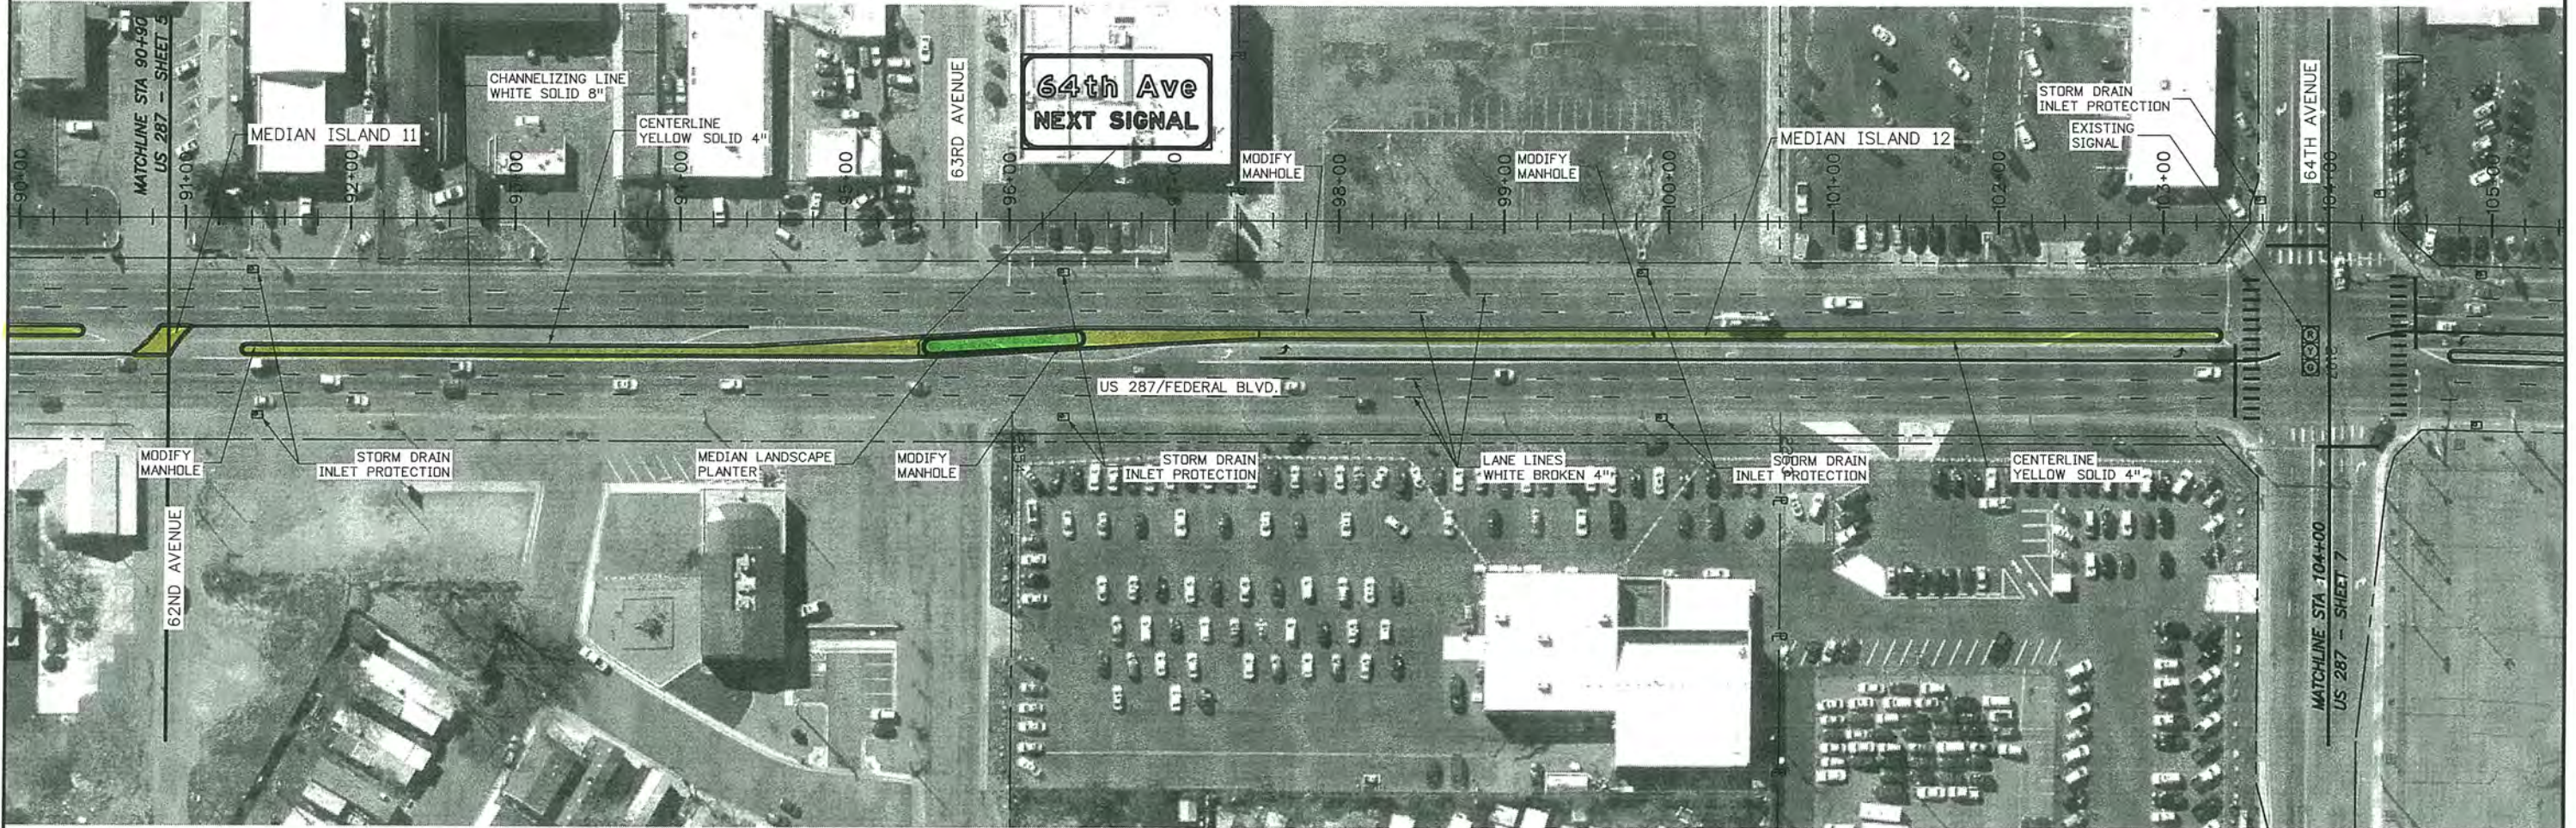

M.P. 287.54

M.P. 287.80

Print Date: 4/30/2014
File Name: 19191 Proposed Roadway Sheet01-06.dgn
Horiz. Scale: 1:100 Vert. Scale: As Noted
Unit Information Unit Leader Initials

Sheet Revisions		
Date:	Comments	Init.

Colorado Department of Transportation



2000 South Holly Street
Denver, CO 80222
Phone: 303-757-9511 FAX: 303-757-9907

Region 1 Traffic and Safety LR

As Constructed
No Revisions:
Revised:
Void:


PROPOSED ROADWAY PLAN			
Designer:	Guy Norris	Structure	X-XX-XX
Detailer:	BMc	Numbers	X-XX-XX
Sheet Subset:	Roadway	Subset Sheets:	06 of 08

Project No./Code
SHE 2873-167
19191
Sheet Number 21

mcghyjb 2:34:32 PM c:\projects\wise\pwrz\working\0375043\19191 Proposed Roadway Sheet01-06.dgn



Know what's below.
Call before you dig.

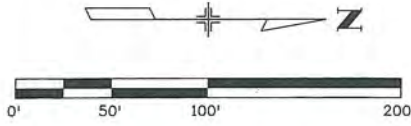

mcghghyb 2:41:58 PM c:\projectwise\pwz-working\d0375043\19191 Proposed Roadway Sheet01-07.dgn

Print Date: 4/30/2014
File Name: 19191 Proposed Roadway Sheet01-07.dgn
Horiz. Scale: 1:100 Vert. Scale: As Noted
Unit Information Unit Leader Initials

Sheet Revisions		
Date:	Comments	Init.

Colorado Department of Transportation



2000 South Holly Street
Denver, CO 80222
Phone: 303-757-9511 FAX: 303-757-9907

Region 1 Traffic and Safety LR

As Constructed
No Revisions:
Revised:
Void:

PROPOSED ROADWAY PLAN			
Designer:	Guy Norris	Structure	X-XX-XX
Detailer:	BMc	Numbers	X-XX-XX
Sheet Subset:	Roadway	Subset Sheets:	07 of 08

Project No./Code
SHE 2873-167
19191
Sheet Number 22




Know what's below.
Call before you dig.



M.P. 288.05

M.P. 288.18

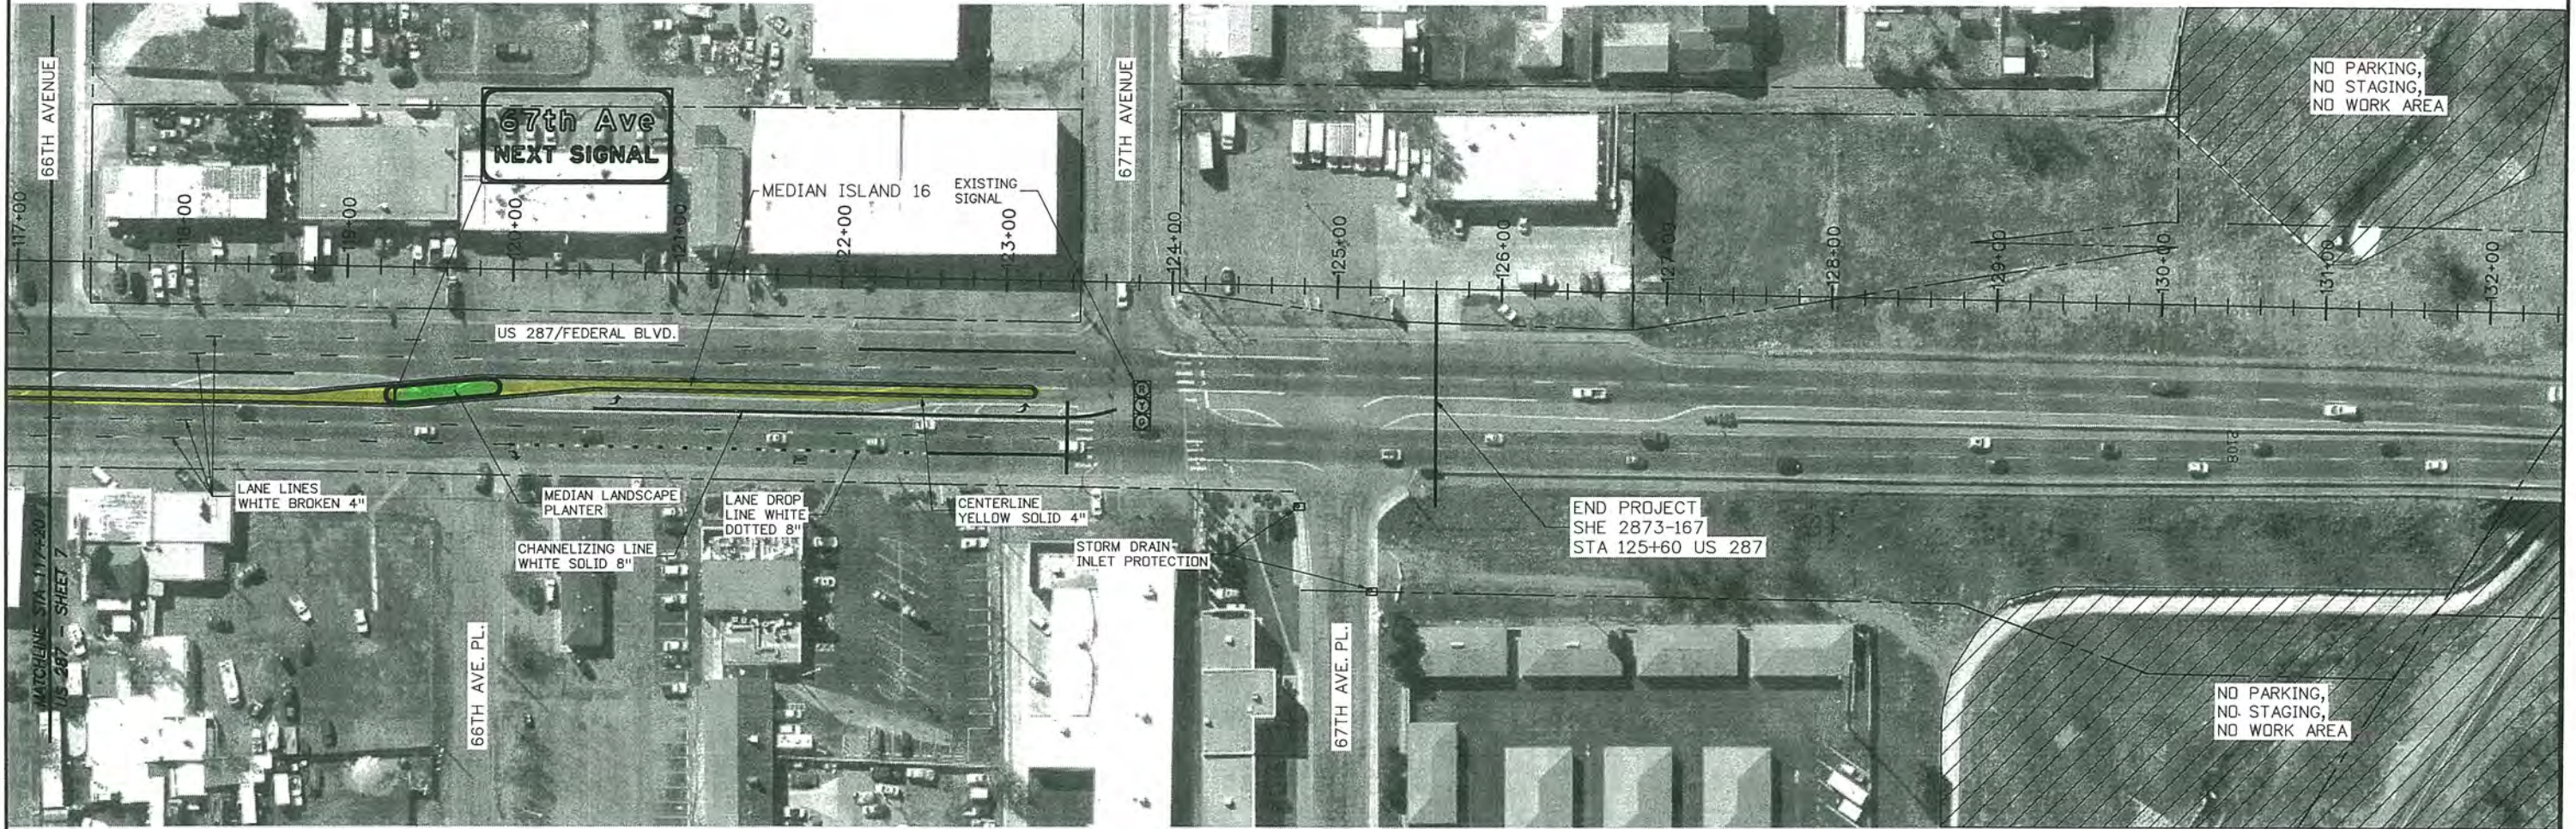

M.P. 288.11

M.P. 288.21

Print Date: 4/30/2014	
File Name: 19191 Proposed Roadway Sheet01-08.dgn	
Horiz. Scale: 1:100	Vert. Scale: As Noted
Unit Information	Unit Leader Initials

Sheet Revisions		
Date:	Comments	Init.

Colorado Department of Transportation



2000 South Holly Street
Denver, CO 80222
Phone: 303-757-9511 FAX: 303-757-9907

Region 1 Traffic and Safety LR

As Constructed
No Revisions:
Revised:
Void:

PROPOSED ROADWAY PLAN			
Designer:	Guy Norris	Structure	X-XX-XX
Detailer:	BMc	Numbers	X-XX-XX
Sheet Subset:	Roadway	Subset Sheets:	08 of 08

Project No./Code
SHE 2873-167
19191
Sheet Number 23

mcghghyb 2:44:52 PM c:\projectwise\pwworking\0375043\19191 Proposed Roadway Sheet01-08.dgn