

LEGEND

WATER	
GAS	
ELECTRIC	
FIBER OPTIC	
SANITARY SEWER	


GENERAL NOTES:

1. UTILITIES WERE PLOTTED FROM THE BEST AVAILABLE INFORMATION OBTAINED FROM UTILITY OWNERS AND SURVEYED LOCATES, HOWEVER PARSONS BRINCKERHOFF MAKES NO GUARANTEES AS TO THE ACCURACY AND COMPLETENESS OF THE UTILITIES SHOWN. IT IS THE CONTRACTORS RESPONSIBILITY TO FIELD VERIFY THE LOCATION OF ALL UTILITIES PRIOR TO THE START OF DESIGN OR CONSTRUCTION.

Print Date: 2/25/2014		Sheet Revisions Date: Comments Init. 			As Constructed No Revisions: Revised: Void:		UTILITY MATRIX SITE PLAN Designer: XXXXXXXX Structure Numbers Detailer: XXXXXXXX Subset: _SG Subset Sheets: _SN of _SO			Project No./Code	
File Name: Utility Matrix Site Plan										XXXX-XXXX-XXX	
Horiz. Scale: 1:500 Vert. Scale:				1480 Quail Lake Loop, Suite A Colorado Springs, CO 80906 Phone: 719-634-2323 FAX: 719-227-3298		Region 2 DMW		XXXX		Sheet Number	
Unit Information Unit Leader Initials				555 17th Street Suite 500 Denver, CO 80202				_ON			

Padlak 11:03:57 AM p:\ABOP\WINT01.wilsonco.com\Projects\Documents\8100-TRN\CDDT\1.3-100-312-01-125-Cimarron-Interch\19039 Utilities\Drawings\Exhibit Drawings\Utility Matrix Site Plan

PadillaK 10:07:14 AM pw:\ABQP\WINT01_wilsonco.com\Projects\Documents\8100-TRN\CDDT\1.3-100-312-01-125-Cimarron_Interch\19039_Utillies\Drawings\Matrix Sheet 1

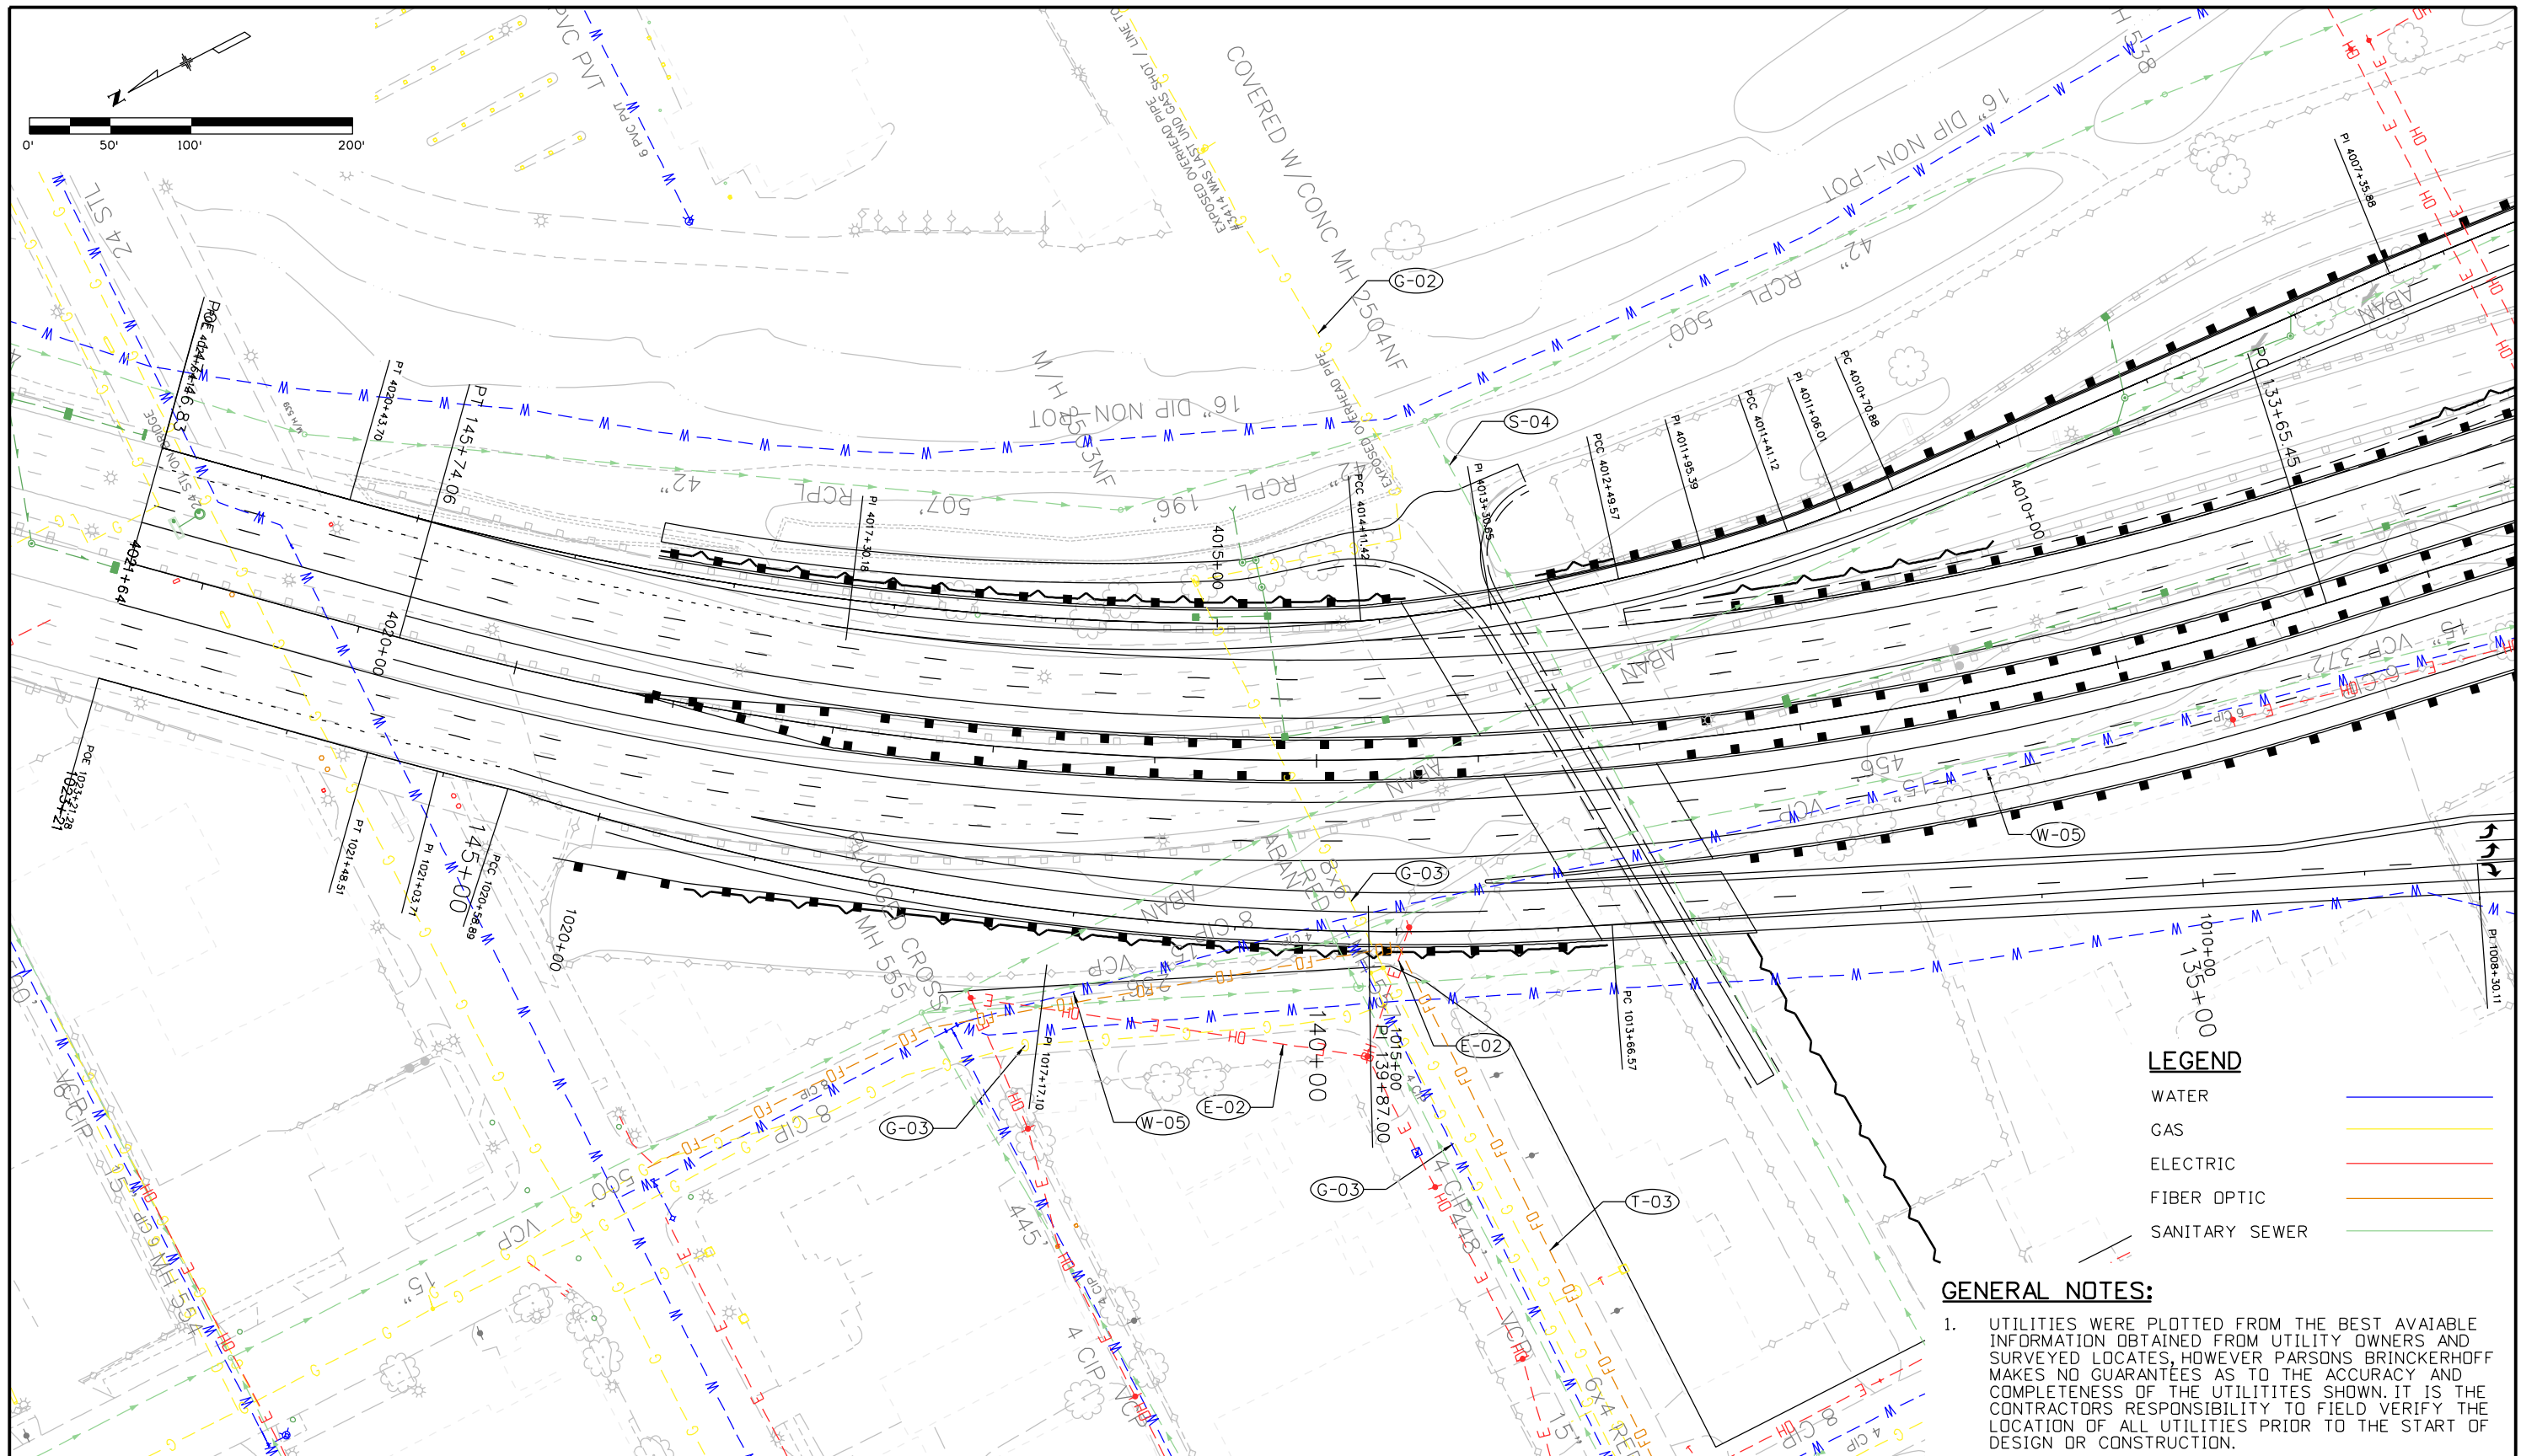

LEGEND

WATER	
GAS	
ELECTRIC	
FIBER OPTIC	
SANITARY SEWER	

GENERAL NOTES:

- UTILITIES WERE PLOTTED FROM THE BEST AVAILABLE INFORMATION OBTAINED FROM UTILITY OWNERS AND SURVEYED LOCATES, HOWEVER PARSONS BRINCKERHOFF MAKES NO GUARANTEES AS TO THE ACCURACY AND COMPLETENESS OF THE UTILITIES SHOWN. IT IS THE CONTRACTORS RESPONSIBILITY TO FIELD VERIFY THE LOCATION OF ALL UTILITIES PRIOR TO THE START OF DESIGN OR CONSTRUCTION.

Print Date: 2/25/2014	
File Name: Matrix Sheet 1	
Horiz. Scale: 1:100	Vert. Scale:
Unit Information	Unit Leader Initials
	555 17th Street Suite 500 Denver, CO 80202

Sheet Revisions		
Date:	Comments	Init.

Colorado Department of Transportation


 1480 Quail Lake Loop, Suite A
 Colorado Springs, CO 80906
 Phone: 719-634-2323 FAX: 719-227-3298
Region 2 **DMW**

As Constructed
No Revisions:
Revised:
Void:

UTILITY MATRIX MAP			
SHEET 1 OF 6			
Designer:	XXXXXXXX	Structure	
Detailer:	XXXXXXXX	Numbers	
Subset:	_SG	Subset Sheets:	_SN of _SO

Project No./Code
Sheet Number _ON

Padlok 10:12:11 AM p:\1\ABQPWINT01.wilson.com\Projects\Documents\8100-TRN\CDOT\13-100-312-01_125_Cimarron_Interch\Utilities\Drawings\Exhibit Drawings\Matrix Sheet 2

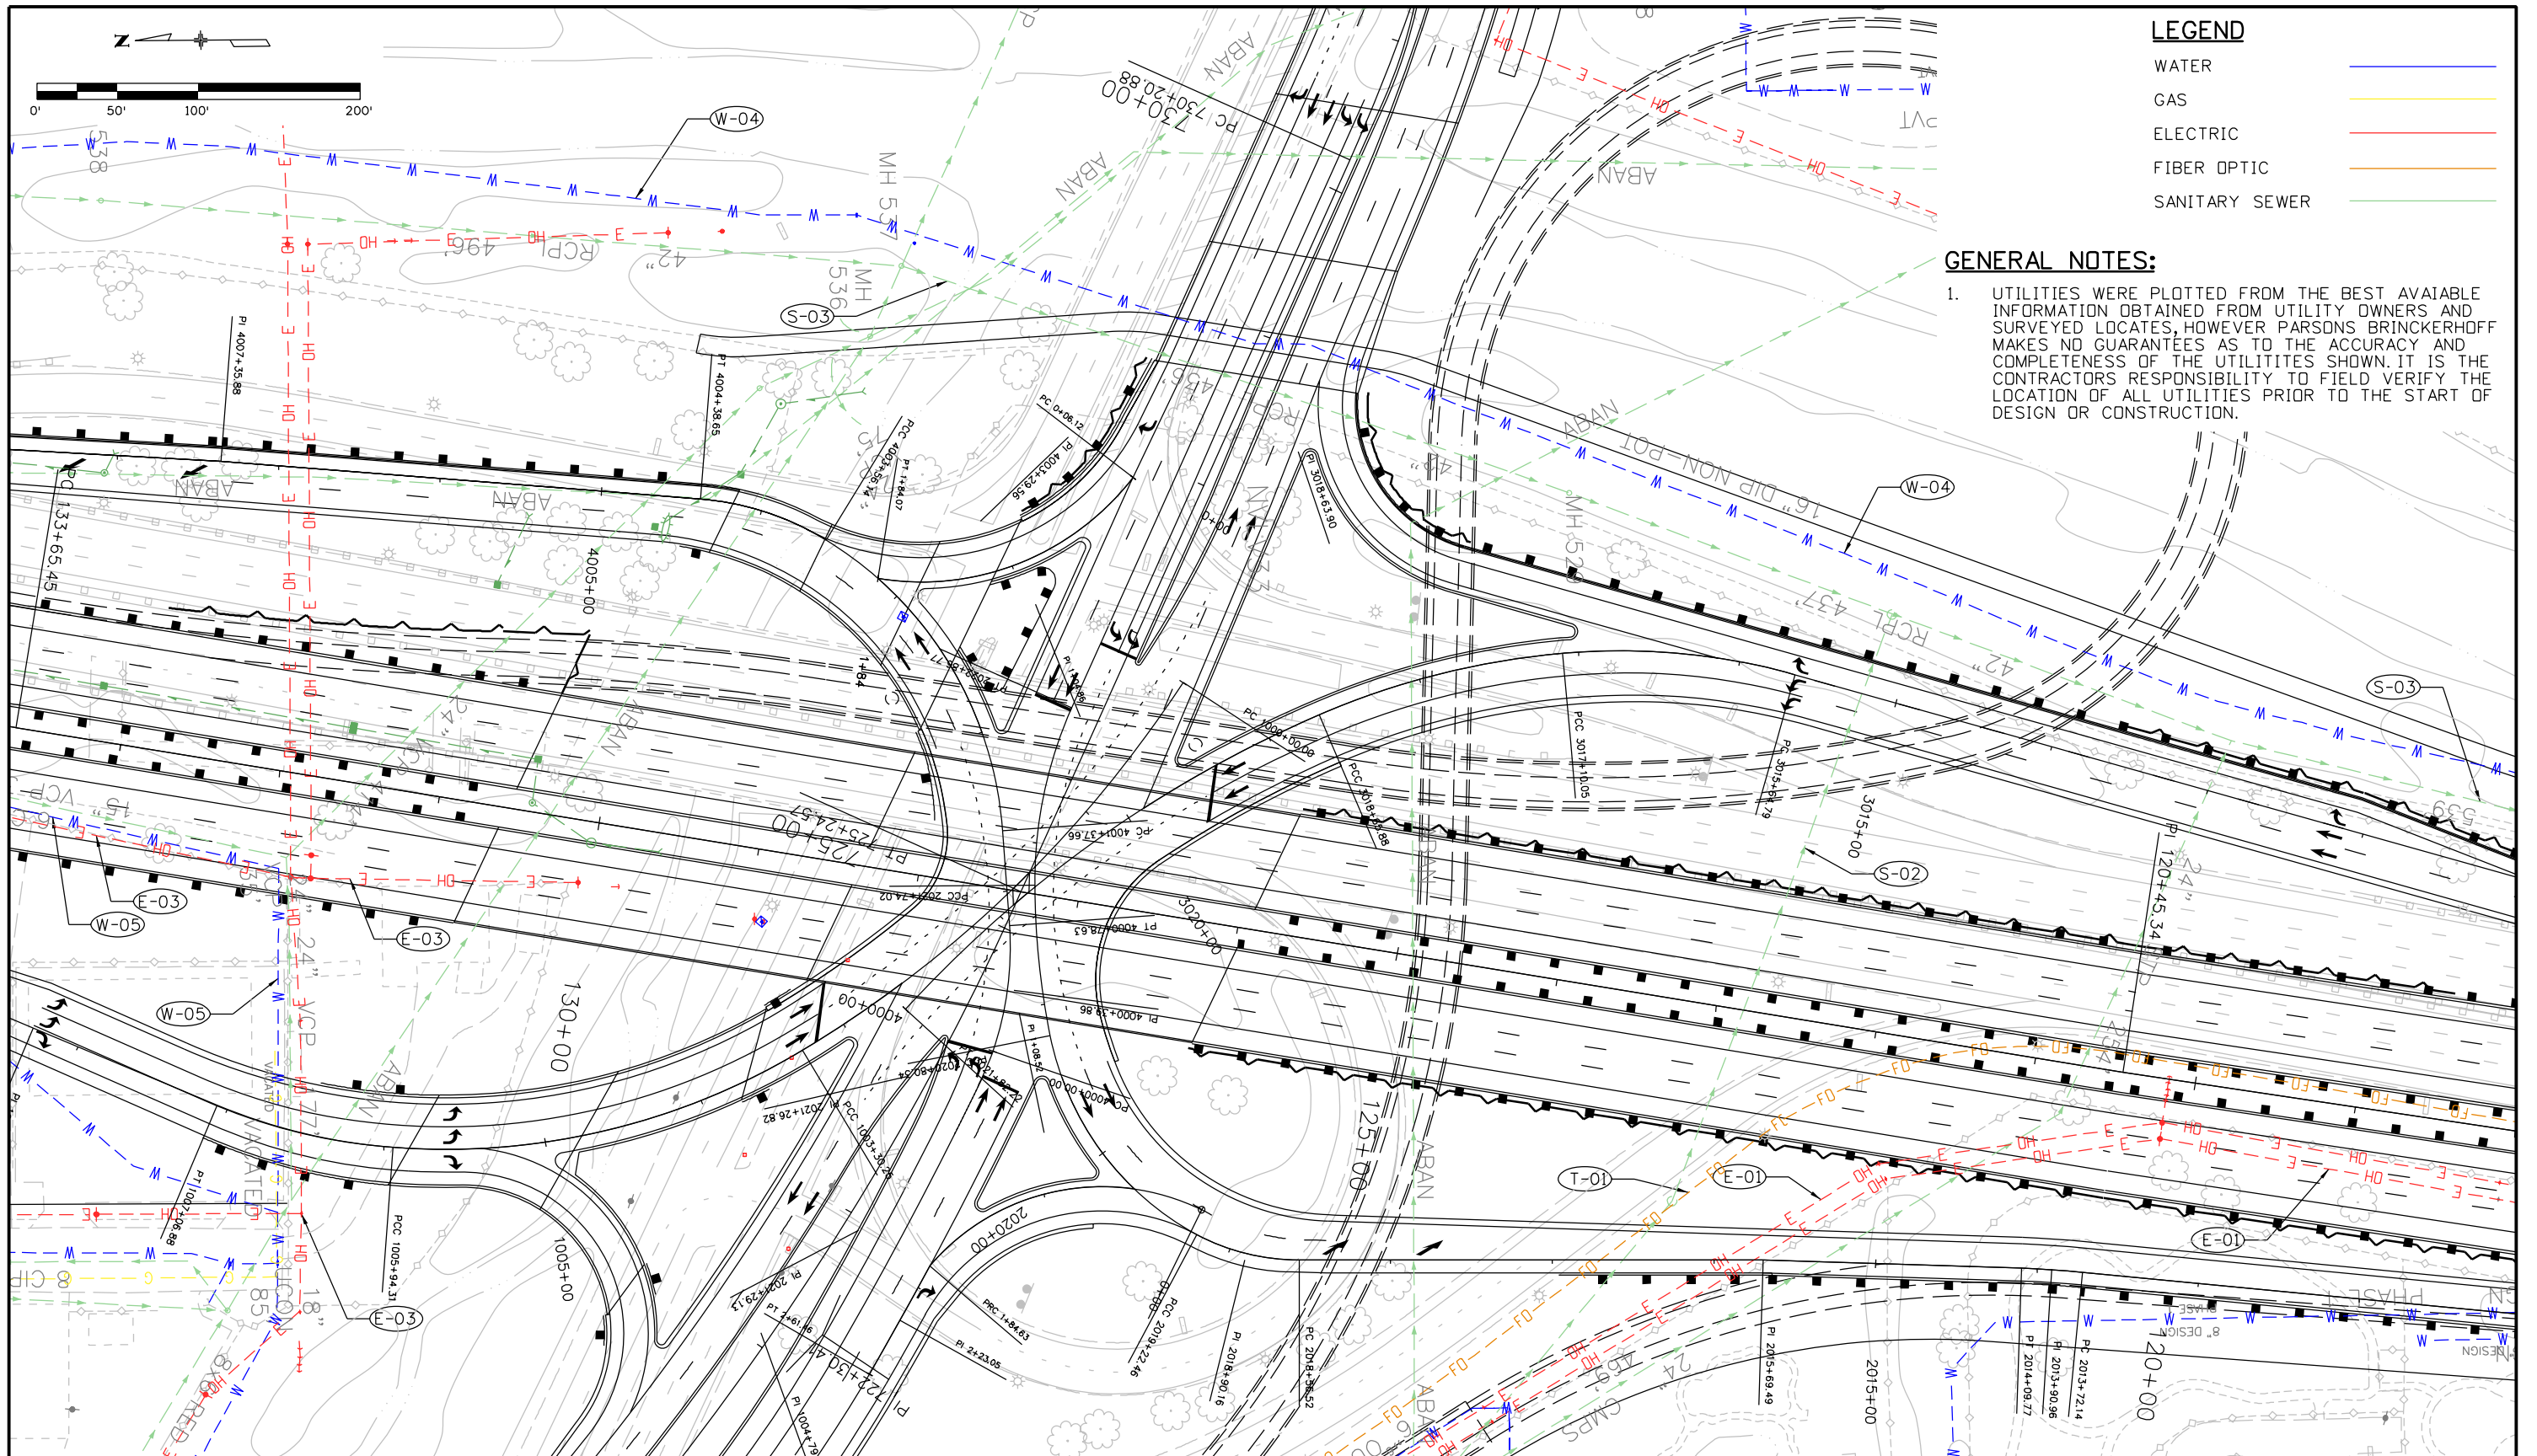

LEGEND

WATER	
GAS	
ELECTRIC	
FIBER OPTIC	
SANITARY SEWER	


GENERAL NOTES:

- UTILITIES WERE PLOTTED FROM THE BEST AVAILABLE INFORMATION OBTAINED FROM UTILITY OWNERS AND SURVEYED LOCATES, HOWEVER PARSONS BRINCKERHOFF MAKES NO GUARANTEES AS TO THE ACCURACY AND COMPLETENESS OF THE UTILITIES SHOWN. IT IS THE CONTRACTORS RESPONSIBILITY TO FIELD VERIFY THE LOCATION OF ALL UTILITIES PRIOR TO THE START OF DESIGN OR CONSTRUCTION.

Print Date: 2/25/2014
File Name: Matrix Sheet 2
Horiz. Scale: 1:99.9698 Vert. Scale:
Unit Information Unit Leader Initials
PARSONS BRINCKERHOFF 555 17th Street Suite 500 Denver, CO 80202

Sheet Revisions		
Date:	Comments	Init.

Colorado Department of Transportation



1480 Quail Lake Loop, Suite A
Colorado Springs, CO 80906
Phone: 719-634-2323 FAX: 719-227-3298


Region 2 DMW

As Constructed
No Revisions:
Revised:
Void:

UTILITY MATRIX MAP SHEET 2 OF 6			
Designer:	XXXXXXXX	Structure Numbers	
Detailer:	XXXXXXXX		
Subset:	_SG	Subset Sheets: _SN of _SO	


Project No./Code
Sheet Number _ON

Padlak 10:27:25 AM p:\p\ABOP\WINT01.wilsonco.com\Wilson_Proj\Projects\Documents\8100-TRN\CDOT\13-100-312-01\125_Cimarron_Utillies\Drawings\Exhibit Drawings\Matrix Sheet 3

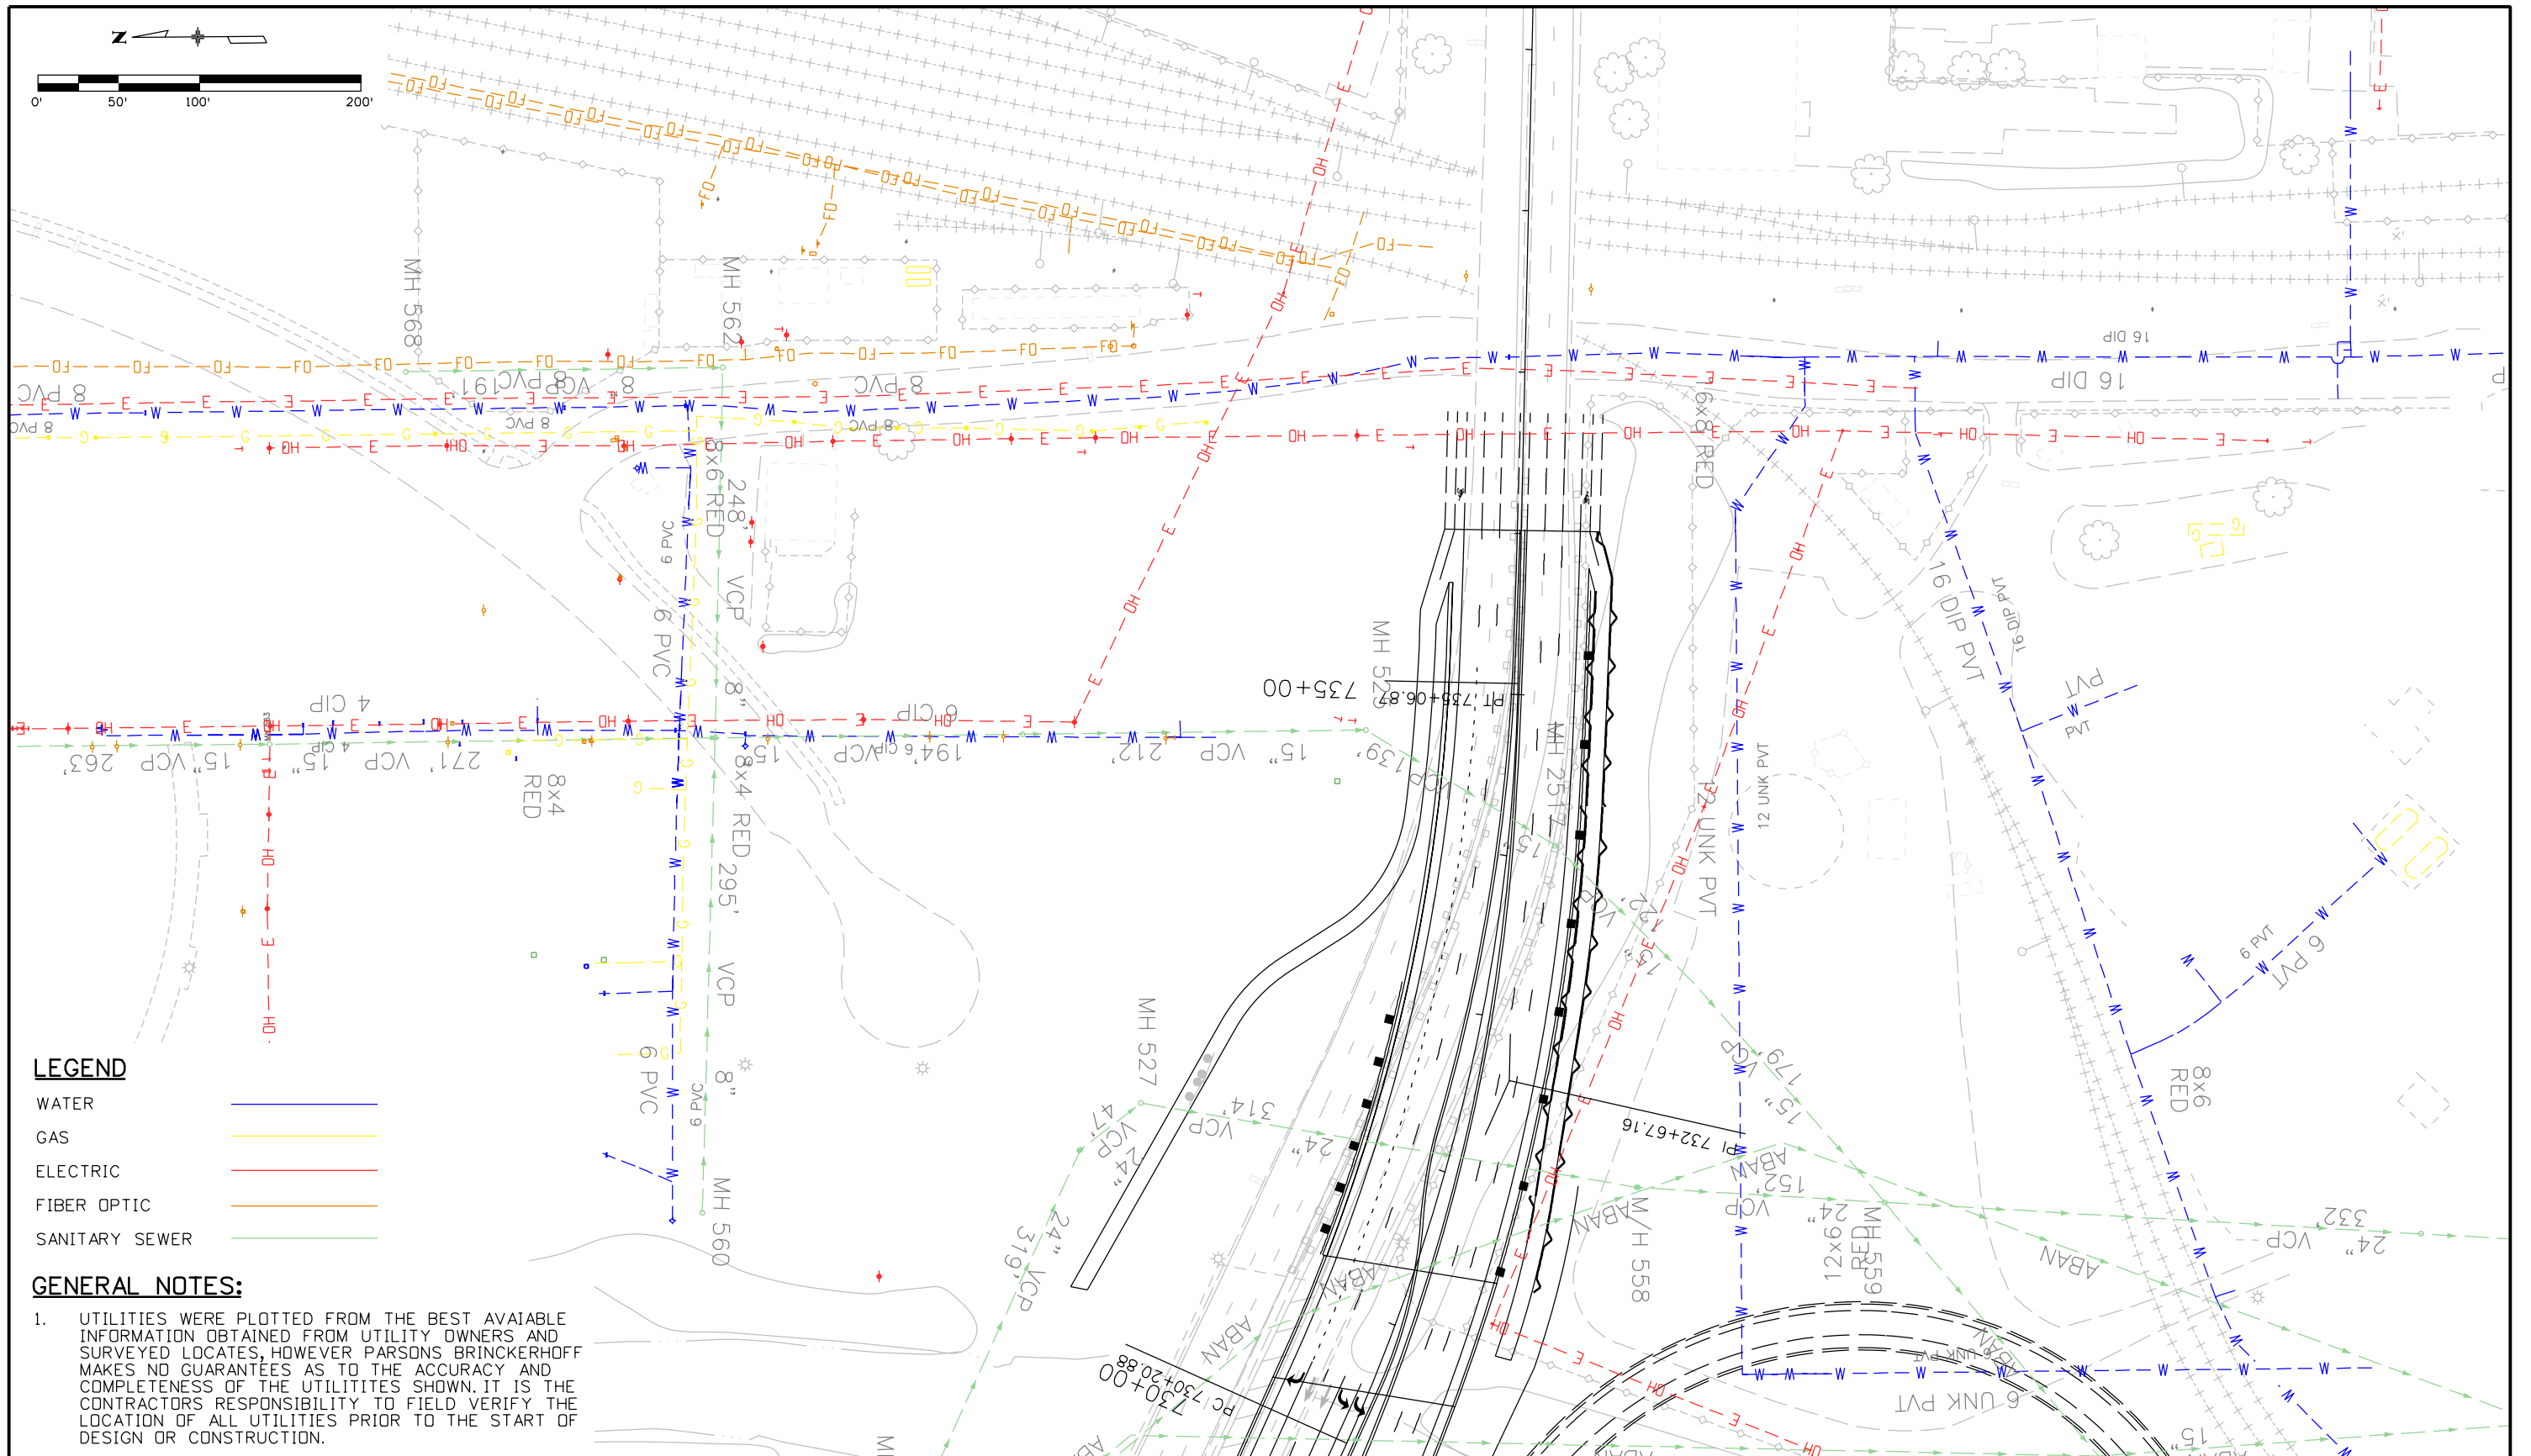

Print Date: 2/25/2014	
File Name: Matrix Sheet 3	
Horiz. Scale: 1:99.9698	Vert. Scale:
Unit Information	Unit Leader Initials
PARSONS BRINCKERHOFF	555 17th Street Suite 500 Denver, CO 80202

Sheet Revisions		
Date:	Comments	Init.


Colorado Department of Transportation

 1480 Quail Lake Loop, Suite A
 Colorado Springs, CO 80906
 Phone: 719-634-2323 FAX: 719-227-3298
Region 2 **DMW**

As Constructed
No Revisions:
Revised:
Void:

UTILITY MATRIX MAP SHEET 3 OF 6			
Designer:	XXXXXXXX	Structure Numbers	
Detailer:	XXXXXXXX		
Subset:	_SG	Subset Sheets: _SN of _SO	


Project No./Code
Sheet Number _ON

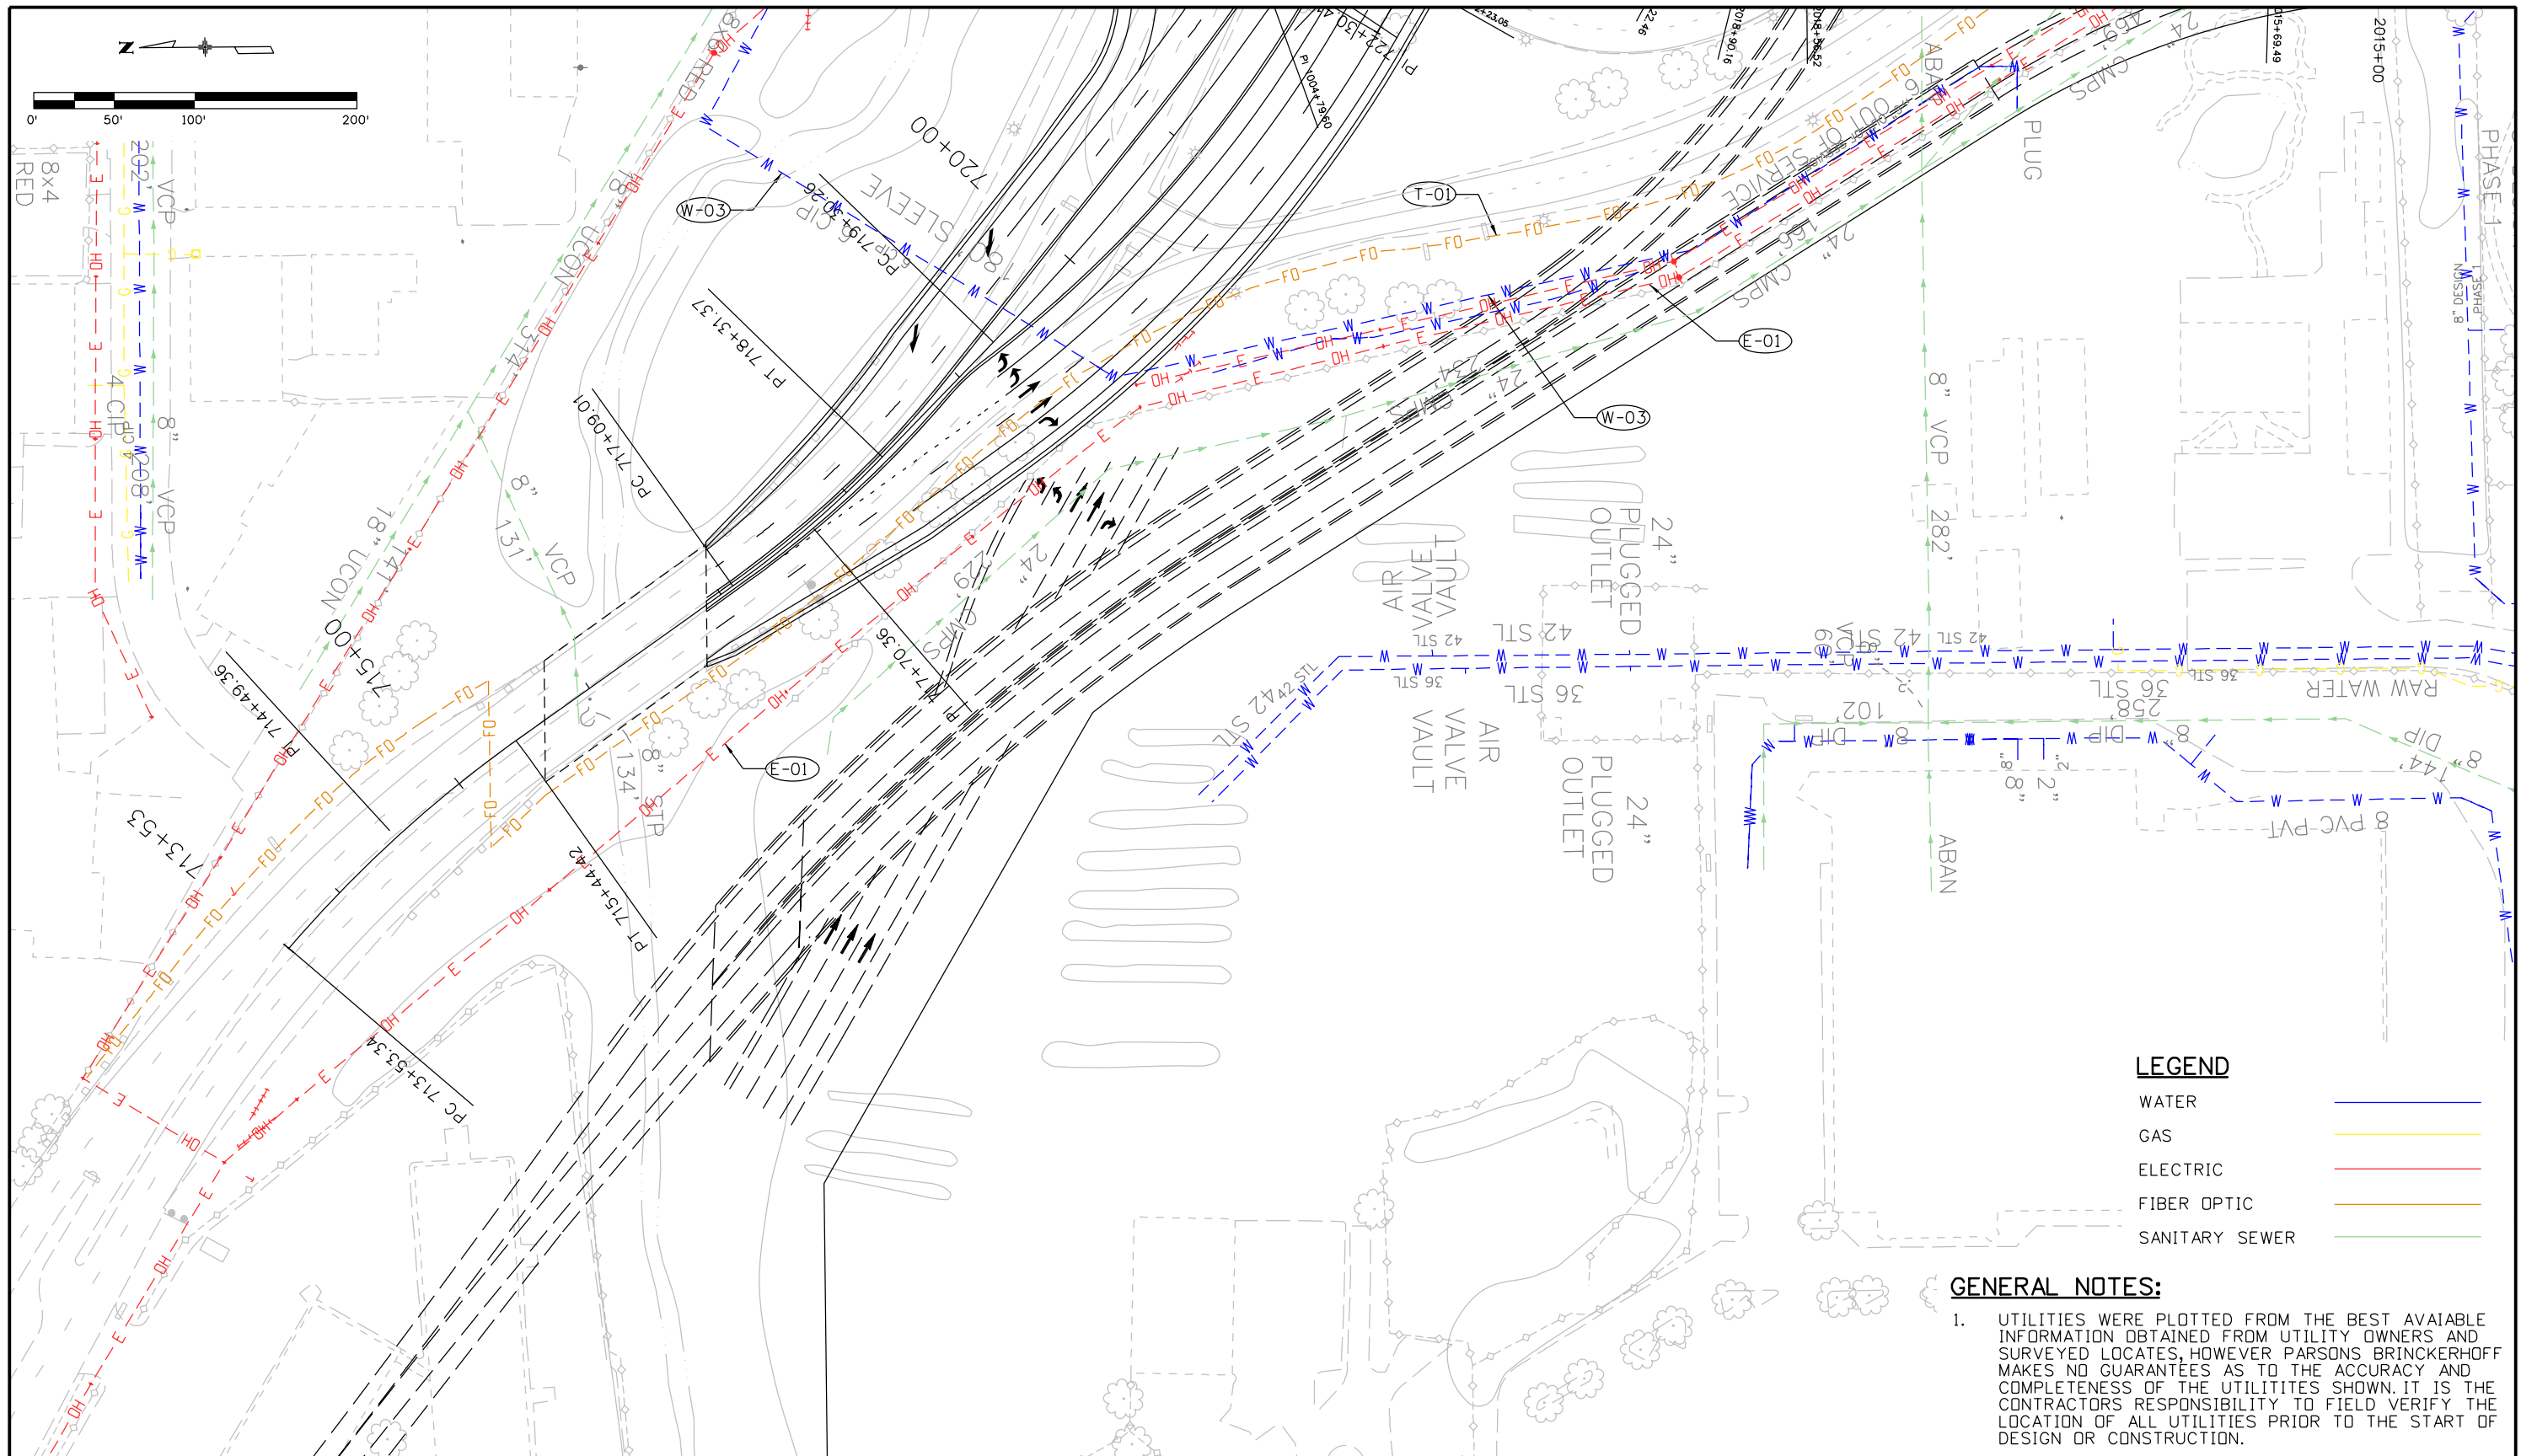Padlak 10:31:54 AM pw:\ABQP\WINT01_wilsonco.com\Projects\Documents\8100-TRN\CDOT\13-100-312-01_125-Cimarron\Utilities\Drawings\Exhibit Drawings\Matrix Sheet 4



Print Date: 2/25/2014		Sheet Revisions		Colorado Department of Transportation		As Constructed		UTILITY MATRIX MAP		Project No./Code	
File Name: Matrix Sheet 4		Date:	Comments	Init.	1480 Quail Lake Loop, Suite A Colorado Springs, CO 80906 Phone: 719-634-2323 FAX: 719-227-3298		No Revisions:		SHEET 4 OF 6		
Horiz. Scale: 1:100 Vert. Scale:					 DEPARTMENT OF TRANSPORTATION		Revised:		Designer: XXXXXXXX	Structure Numbers	
Unit Information Unit Leader Initials					Region 2 DMW		Void:		Detailer: XXXXXXXX		Sheet Number
 555 17th Street Suite 500 Denver, CO 80202		R-X							Subset: _SG	Subset Sheets: _SN of _SO	_ON

Padlak 11:26:21 AM p:\ABQP\WINT01.wilson.com\Wilson\Projects\Documents\B100-TRN\CDOT\13-100-312-01_125_Cimarron_Interch\Utilities\Drawings\Exhibit Drawings Matrix Sheet 5

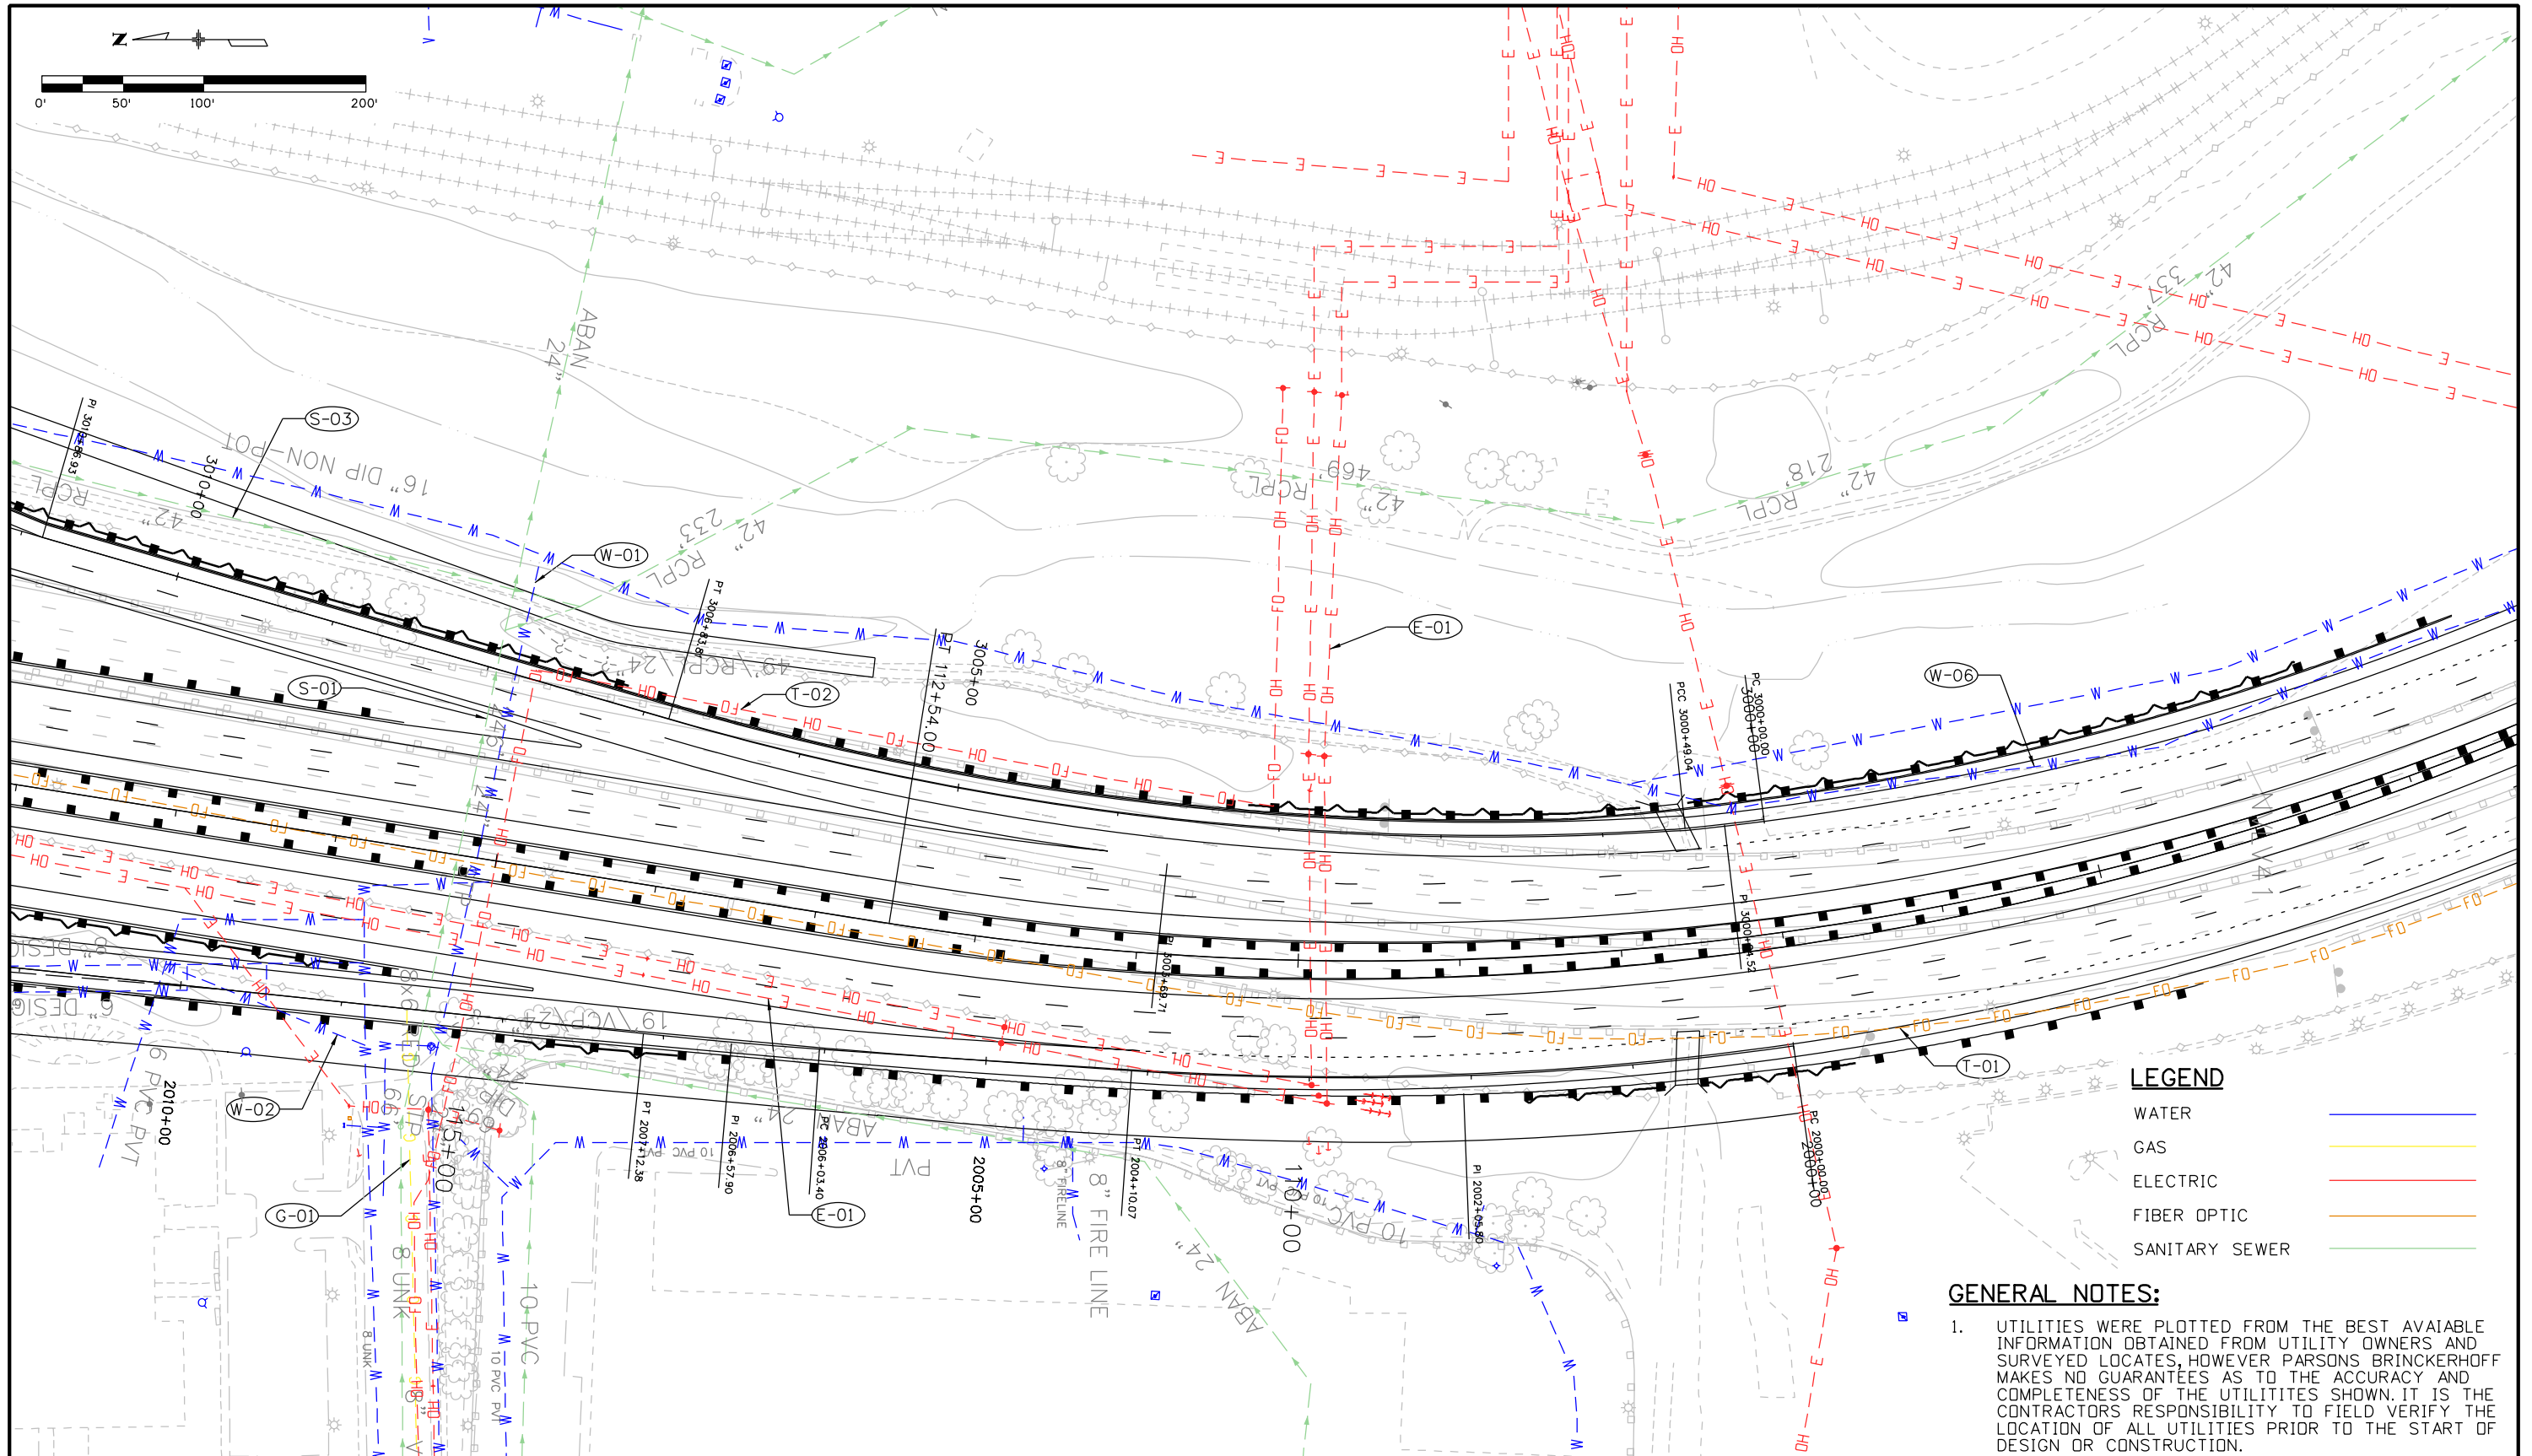

LEGEND	
WATER	
GAS	
ELECTRIC	
FIBER OPTIC	
SANITARY SEWER	

GENERAL NOTES:

- UTILITIES WERE PLOTTED FROM THE BEST AVAILABLE INFORMATION OBTAINED FROM UTILITY OWNERS AND SURVEYED LOCATES, HOWEVER PARSONS BRINCKERHOFF MAKES NO GUARANTEES AS TO THE ACCURACY AND COMPLETENESS OF THE UTILITIES SHOWN. IT IS THE CONTRACTOR'S RESPONSIBILITY TO FIELD VERIFY THE LOCATION OF ALL UTILITIES PRIOR TO THE START OF DESIGN OR CONSTRUCTION.

Print Date: 2/25/2014
 File Name: Matrix Sheet 5
 Horiz. Scale: 1:100 Vert. Scale:
 Unit Information Unit Leader Initials
PARSONS BRINCKERHOFF 555 17th Street
 Suite 500
 Denver, CO 80202

Sheet Revisions		
Date:	Comments	Init.

Colorado Department of Transportation



 1480 Quail Lake Loop, Suite A
 Colorado Springs, CO 80906
 Phone: 719-634-2323 FAX: 719-227-3298
Region 2 **DMW**

As Constructed
 No Revisions:
 Revised:
 Void:

UTILITY MATRIX MAP SHEET 5 OF 6			
Designer:	XXXXXXXX	Structure	
Detailer:	XXXXXXXX	Numbers	
Subset:	_SG	Subset Sheets:	_SN of _SD

Project No./Code
 Sheet Number **_ON**

Padfile: 10:44:50 AM pwr:\ABOP\WINT01.wilsonco.com\Projects\Documents\8100-TRN\CDOT\13-100-312-01-125-Cimarron-Interch\19039\Utilities\Drawings\Exhibit Drawings\Matrix Sheet 6

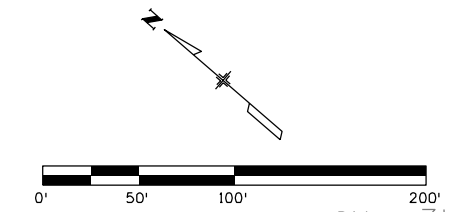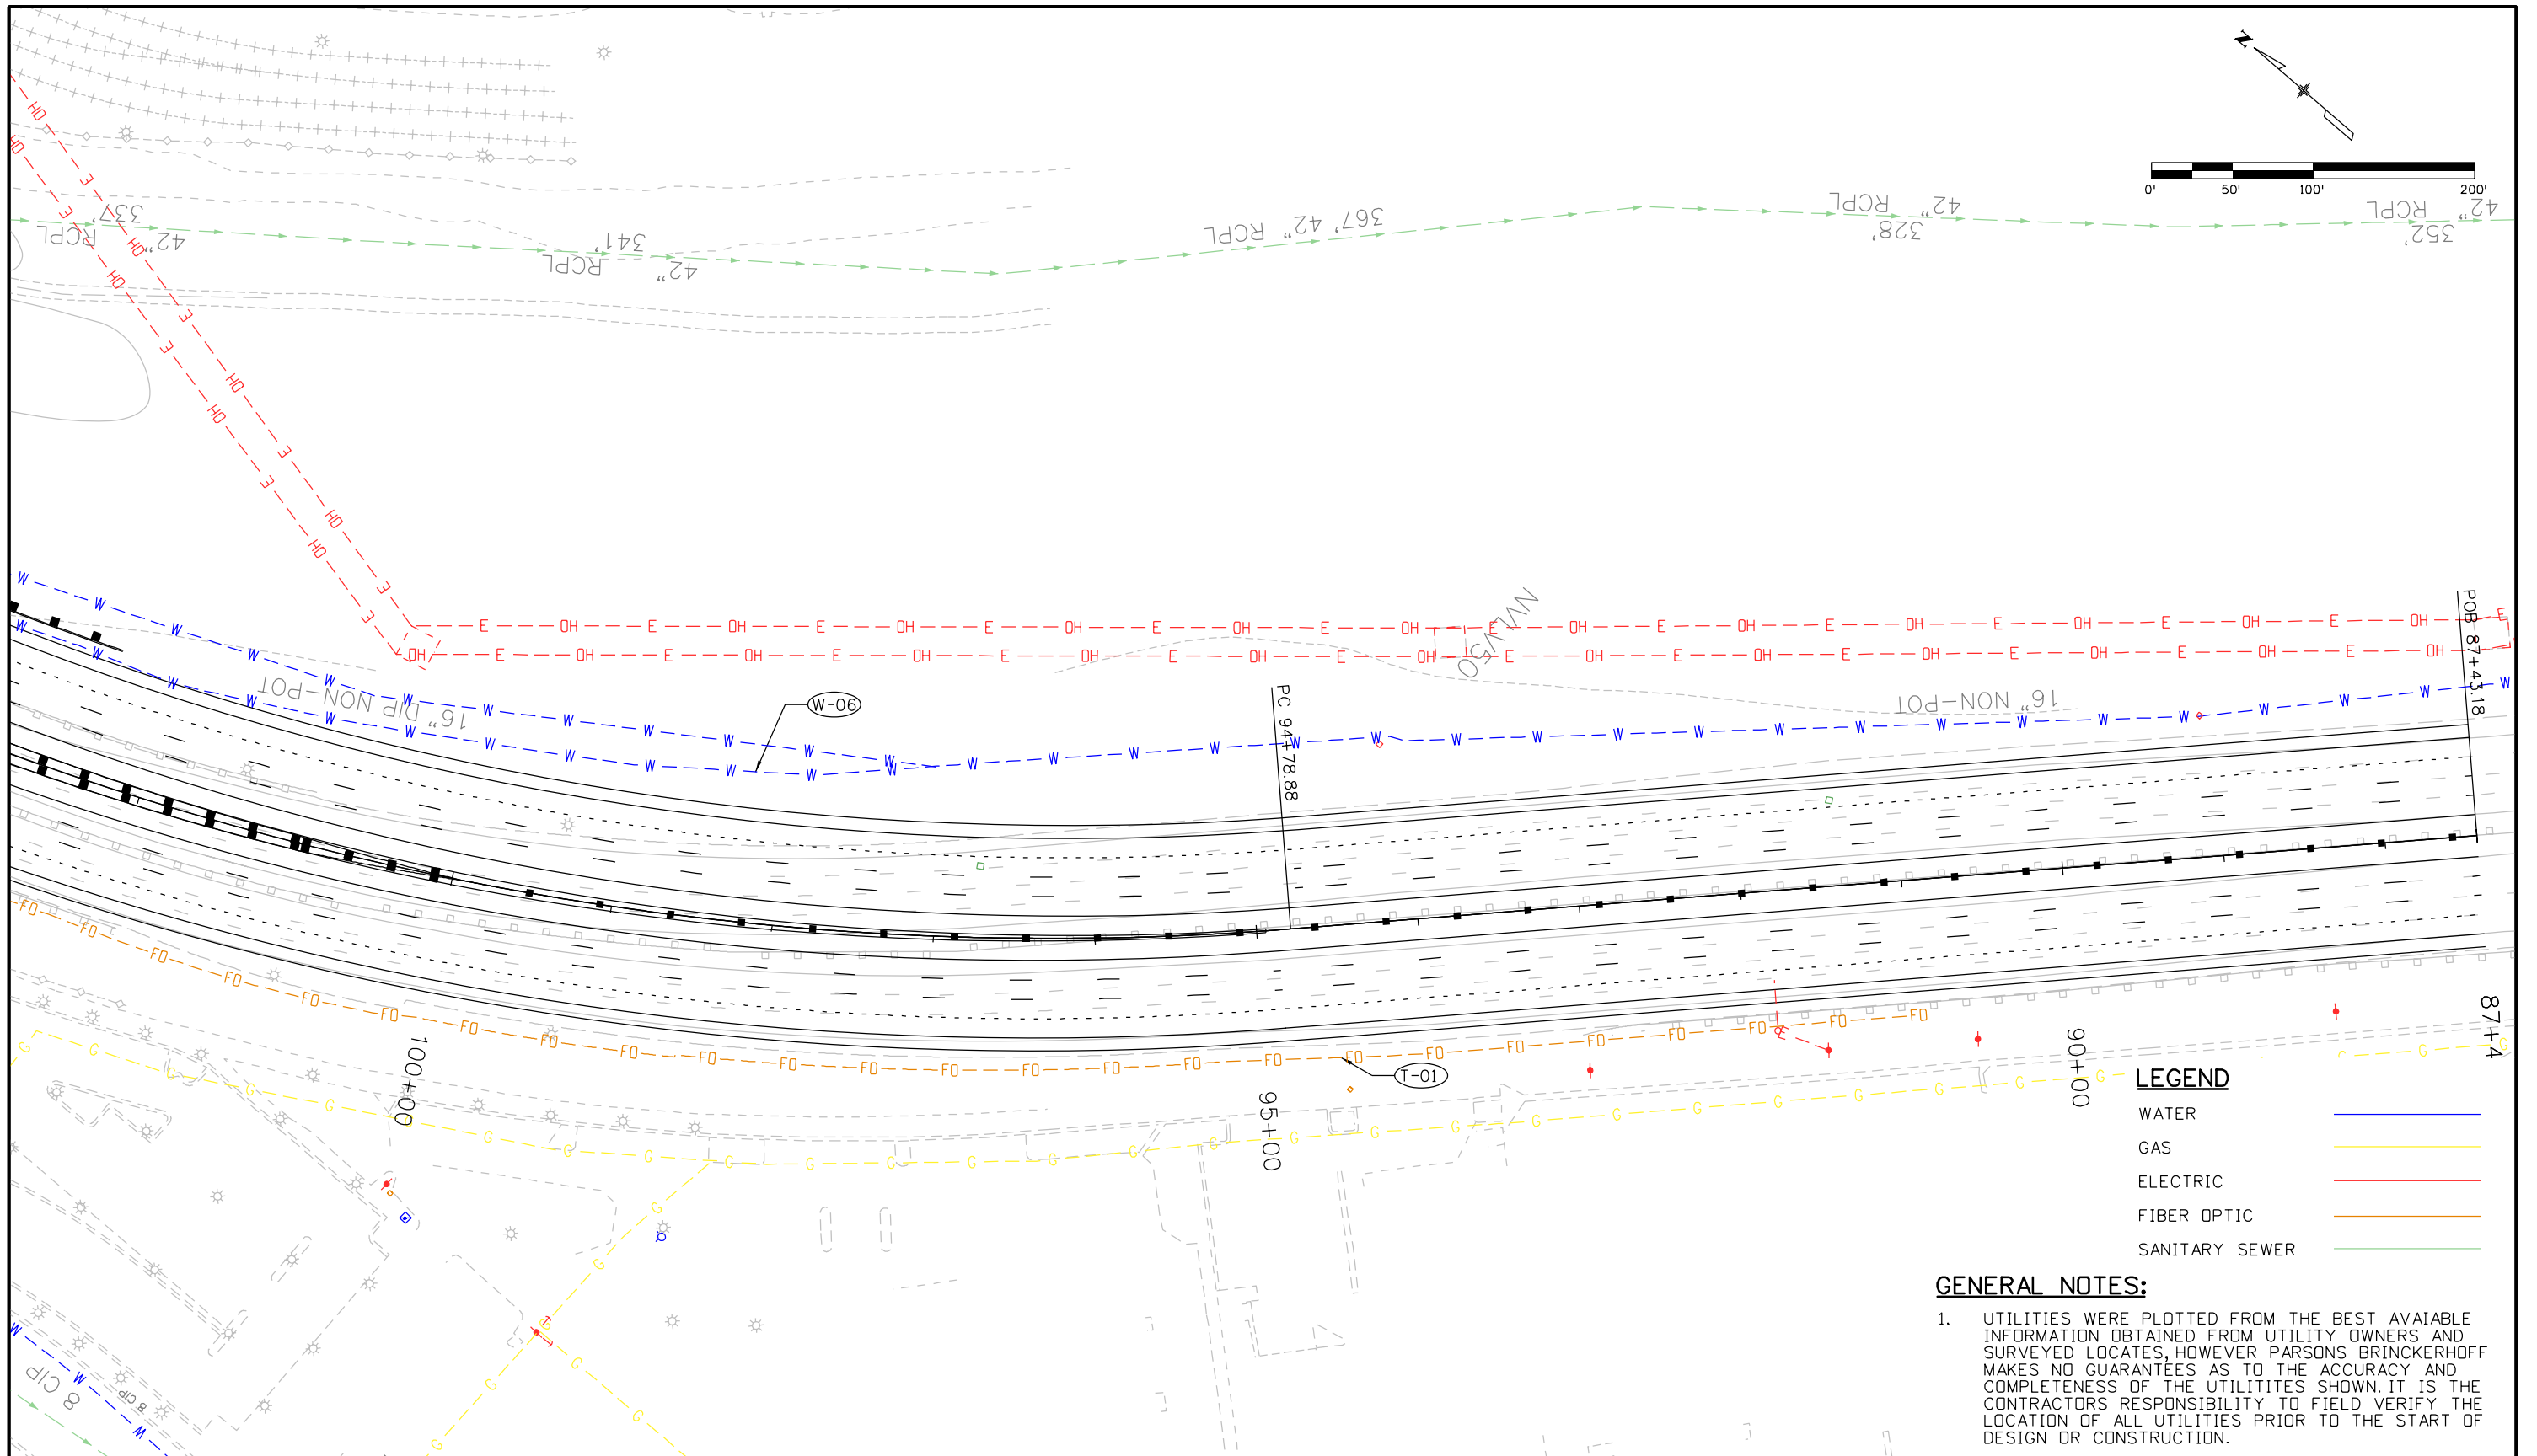

LEGEND

WATER	
GAS	
ELECTRIC	
FIBER OPTIC	
SANITARY SEWER	

GENERAL NOTES:

- UTILITIES WERE PLOTTED FROM THE BEST AVAILABLE INFORMATION OBTAINED FROM UTILITY OWNERS AND SURVEYED LOCATES, HOWEVER PARSONS BRINCKERHOFF MAKES NO GUARANTEES AS TO THE ACCURACY AND COMPLETENESS OF THE UTILITIES SHOWN. IT IS THE CONTRACTORS RESPONSIBILITY TO FIELD VERIFY THE LOCATION OF ALL UTILITIES PRIOR TO THE START OF DESIGN OR CONSTRUCTION.

Print Date: 2/25/2014	
File Name: Matrix Sheet 6	
Horiz. Scale: 1:99.9698	Vert. Scale:
Unit Information	Unit Leader Initials
PARSONS BRINCKERHOFF	555 17th Street Suite 500 Denver, CO 80202

Sheet Revisions		
Date:	Comments	Init.

Colorado Department of Transportation

 1480 Quail Lake Loop, Suite A
 Colorado Springs, CO 80906
 Phone: 719-634-2323 FAX: 719-227-3298
Region 2 **DMW**

As Constructed
No Revisions:
Revised:
Void:

UTILITY MATRIX MAP SHEET 6 OF 6			
Designer:	XXXXXXXX	Structure	
Detailer:	XXXXXXXX	Numbers	
Subset:	_SG	Subset Sheets:	_SN of _SO

Project No./Code
Sheet Number _ON