


PoDI / NHS	
FHWA PROJECT OF DIVISION INTEREST (PoDI)?	<input checked="" type="checkbox"/> NO <input type="checkbox"/> YES
NATIONAL HIGHWAY SYSTEM?	<input type="checkbox"/> NO <input checked="" type="checkbox"/> YES

DEPARTMENT OF TRANSPORTATION STATE OF COLORADO

CONSTRUCTION BID PLANS OF PROPOSED COLORADO PROJECT NO. C 0343-044 US 34 CURB RAMP REPLACEMENTS WASHINGTON & YUMA COUNTIES PROJECT CODE 23037

Related Projects:	
P. E. UNDER PROJECT:	C 0343-044
Project Number	23037
Project Code:	
R.O.W. Projects:	
R.O.W. Project Description	
C 0343-044	

TABULATION OF LENGTH & DESIGN DATA		
STATION	LINEAR FEET	
	ROADWAY	MAJOR STR.
US 34 AKRON, OTIS, YUMA, WRAY		
MP 195.34 BEGIN APPROACH	2,640	
MP 195.84 BEGIN PROJECT	4,963	
MP 196.78 - 209.36 NO WORK AREA	1,531	
MP 209.65 - 222.73 NO WORK AREA	3,274	
MP 223.35 - 249.99 NO WORK AREA	3,485	
MP 250.65 END PROJECT	2,640	
MP 251.15 END APPROACH		
SH 63 AKRON		
MP 28.58 BEGIN APPROACH	2,640	
MP 29.08 - 29.43 PROJECT	1,848	
MP 29.93 END APPROACH	2,640	
SH 61 OTIS		
MP 0.00 BEGIN APPROACH	370	
MP 0.07 - 0.16 PROJECT	475	
MP 0.66 END APPROACH	2,640	
SH 59 YUMA		
MP 105.72 BEGIN APPROACH	2,640	
MP 106.22 - 107.67 PROJECT	7,656	
MP 108.17 END APPROACH	2,640	
US 385 WRAY		
MP 242.48 BEGIN APPROACH	2,640	
MP 242.98 - 243.00 PROJECT	106	
MP 243.50 END APPROACH	2,640	
TOTAL	47,467.20	0.00
SUMMARY OF PROJECT LENGTH	FEET	MILES
ROADWAY	47,467.20	8.99
MAJOR STRUCTURE	0	0.00
PROJECT GROSS LENGTH	47,467.20	8.99

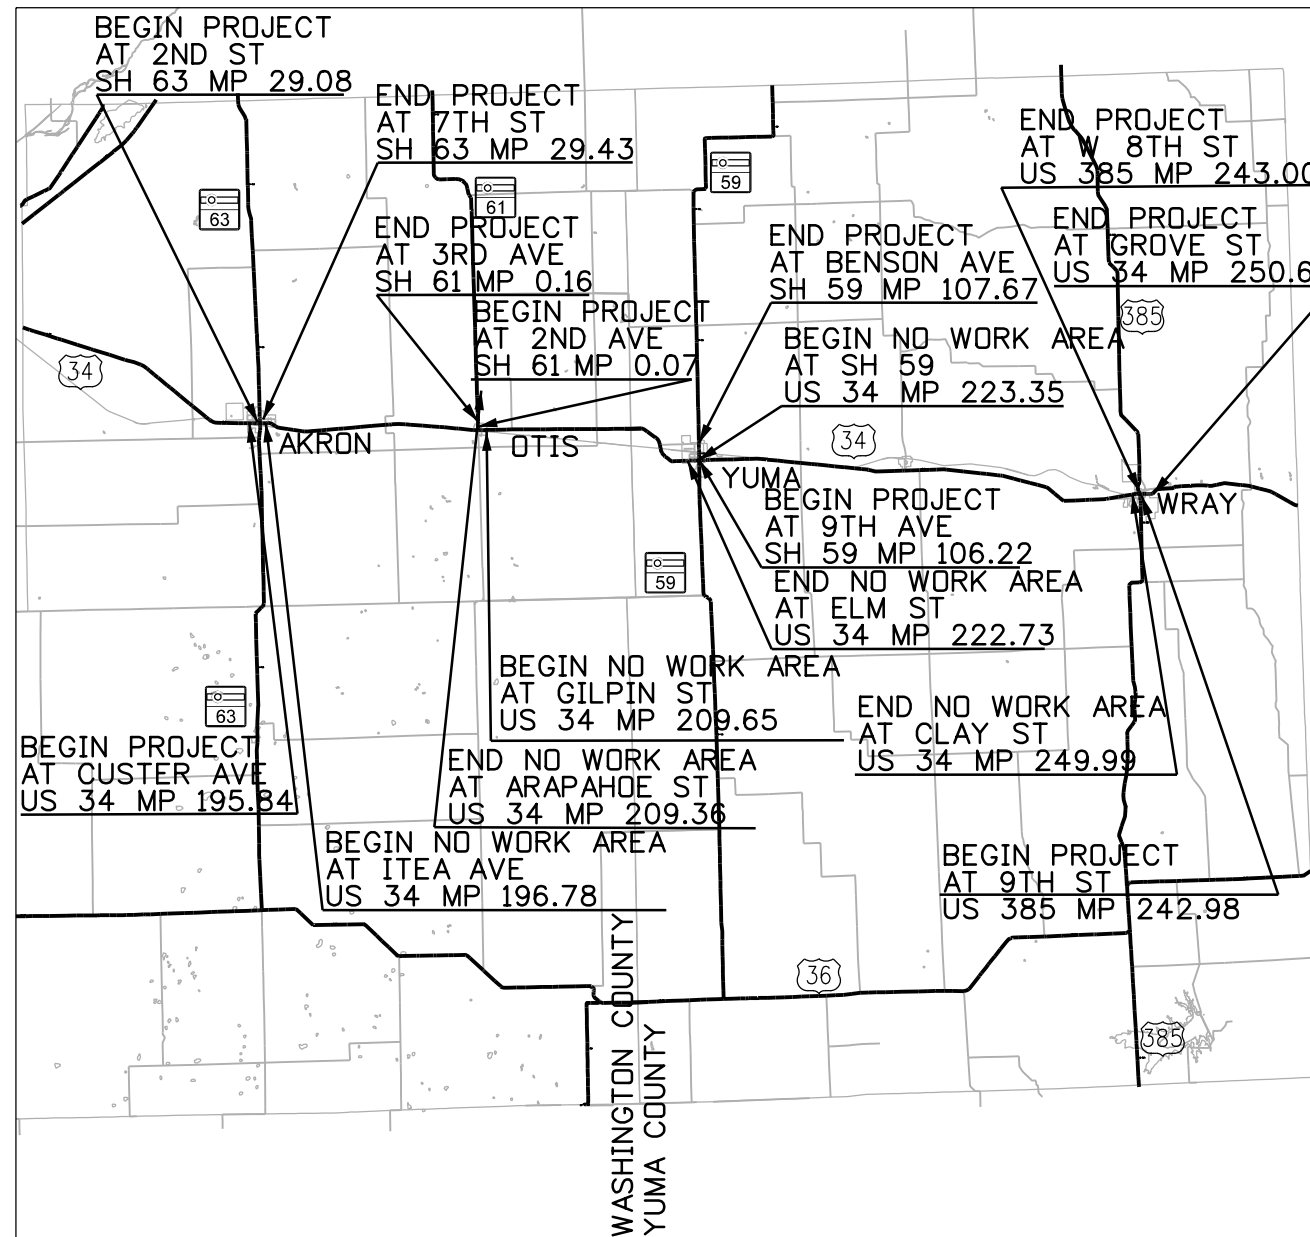

SHEET NO.	TITLE
1	TITLE SHEET
2	M&S STANDARDS LIST
3	GENERAL NOTES
4	KEY MAP
5 - 6	SUMMARY OF APPROXIMATE QUANTITIES
7 - 13	TABULATIONS
14 - 17	SURVEY CONTROL DIAGRAMS
18 - 48	AKRON CURB RAMP PLAN
49 - 59	OTIS CURB RAMP PLAN
60 - 80	YUMA CURB RAMP PLAN
81 - 102	WRAY CURB RAMP PLAN
103 - 108	STORMWATER MANAGEMENT PLAN
109	FLOODPLAIN INFORMATION SHEET
110	TRAFFIC CONTROL PLAN
111 - 122	RIGHT-OF-WAY PLANS

DESIGN DATA	US 34	SH 63	SH 61	SH 59	US 385
DESIGN SPEED (POSTED)	VARIABLES	VARIABLES	35 mph	VARIABLES	VARIABLES
2016 TRAFFIC	ADT 7,100 DHV 781	ADT 1,800 DHV 198	ADT 810 DHV 93	ADT 3,000 DHV 345	ADT 4,000 DHV 348
2036 TRAFFIC	ADT 8,378	ADT 2,196	ADT 1,029	ADT 4,110	ADT 4,720
OFF-PEAK TRUCK %	11.0%	12.0%	14.0%	16.0%	9.0%



**Know what's below.
Call before you dig.**

AD
1/25/2021

msalek 7:22:28 AM Y:\Denver\1518005\00151888\00_US34_Curb_Ramps_Eng_Docs\Drawings\23037DES_TitleSheet.dgn

Print Date: 1/25/2021
File Name: 23037DES_TitleSheet.dgn
Horiz. Scale: 1:6000 Vert. Scale: As Noted
Alfred Benesch & Company 7979 E Tufts Ave, Suite 800 Denver, Colorado 80237 303-771-6868 Proj. 151888.00

Sheet Revisions		
Date:	Comments	Init.

Colorado Department of Transportation
120 North Riverview Road
Sterling, CO 80751
Phone: 970-521-9705
FAX: 970-521-9729

Region 4 JTD

As Constructed
No Revisions:
Revised:
Void:

Contract Information
Contractor:
Resident Engineer:
Project Engineer:
PROJECT STARTED: ___/___/___ ACCEPTED: ___/___/___
Comments:

Project No./Code
C 0343-044
23037
Sheet Number 1