


MILE
1
7
8

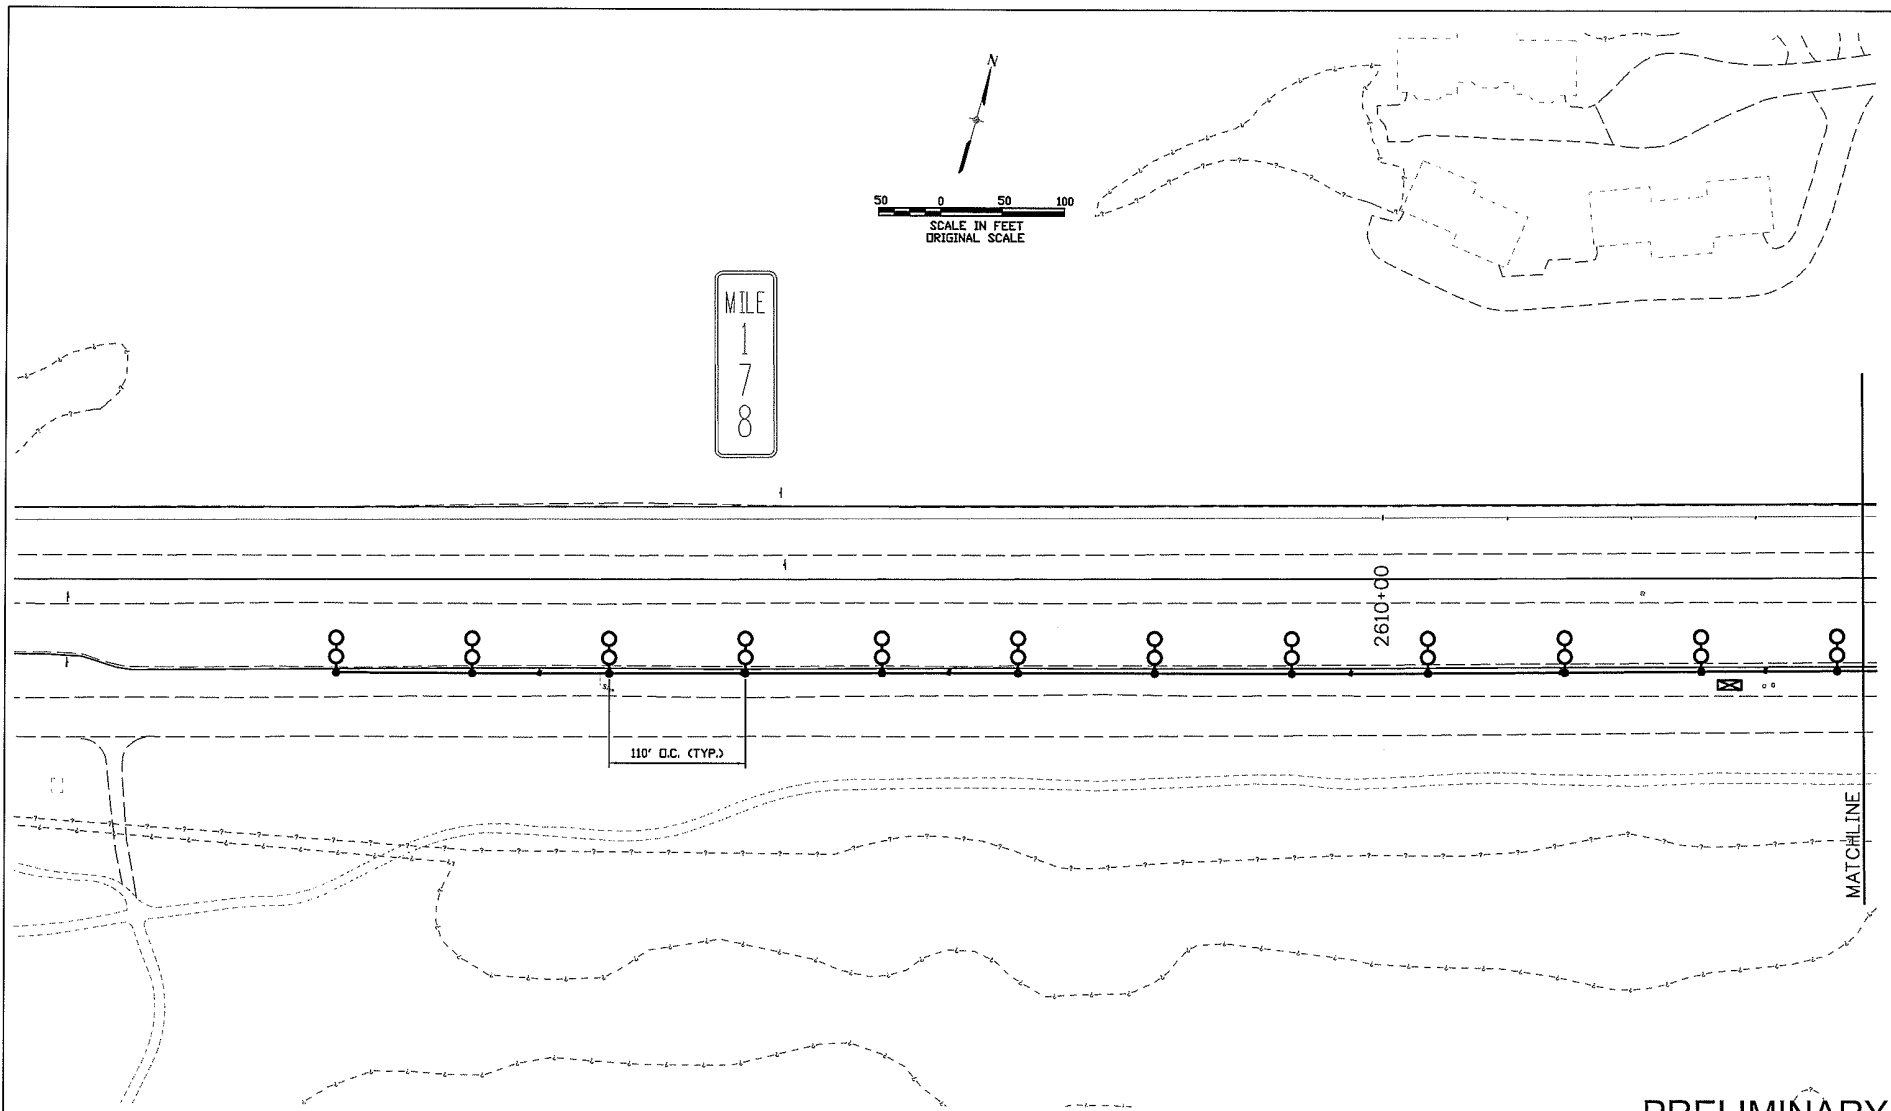

PRELIMINARY
SUBJECT TO REVISION

CLANTON & ASSOCIATES LIGHTING DESIGN AND ENGINEERING
609 N. W. 10th Street, Suite 102
DENVER, CO 80202
303-570-7124

Computer File Information	
Creation Date:	Initials: GF
Last Modification Date:	Initials: JE
Full Path: Z:\VAIL CHAIN STATIONS\CURRENT\	
Drawing File Name:	
Scale: REFER TO BAR SCALE	Units: ENGLISH


Index of Revisions	

Region 1
18500 East Colfax
Aurora, CO 80011
Phone: (303) 365-7340
FAX: (303) 365-7343

PBSJ
4601 DTC Blvd.
Suite 700
Denver, CO 80237
Phone: (303) 221-7275
Fax: (303) 221-7276

REGION I DW

As Constructed		LIGHTING PLAN - MP 177 PLAN & SWMP SITE MAP		Project No./Code	
No. Revisions:		Designer:	GF	Structure Numbers	
Revised:		Detailer:	JE		16701
Void:		Sheet Subset:	LE	Subset Sheets:	02 OF 24
					Sheet Number: 23

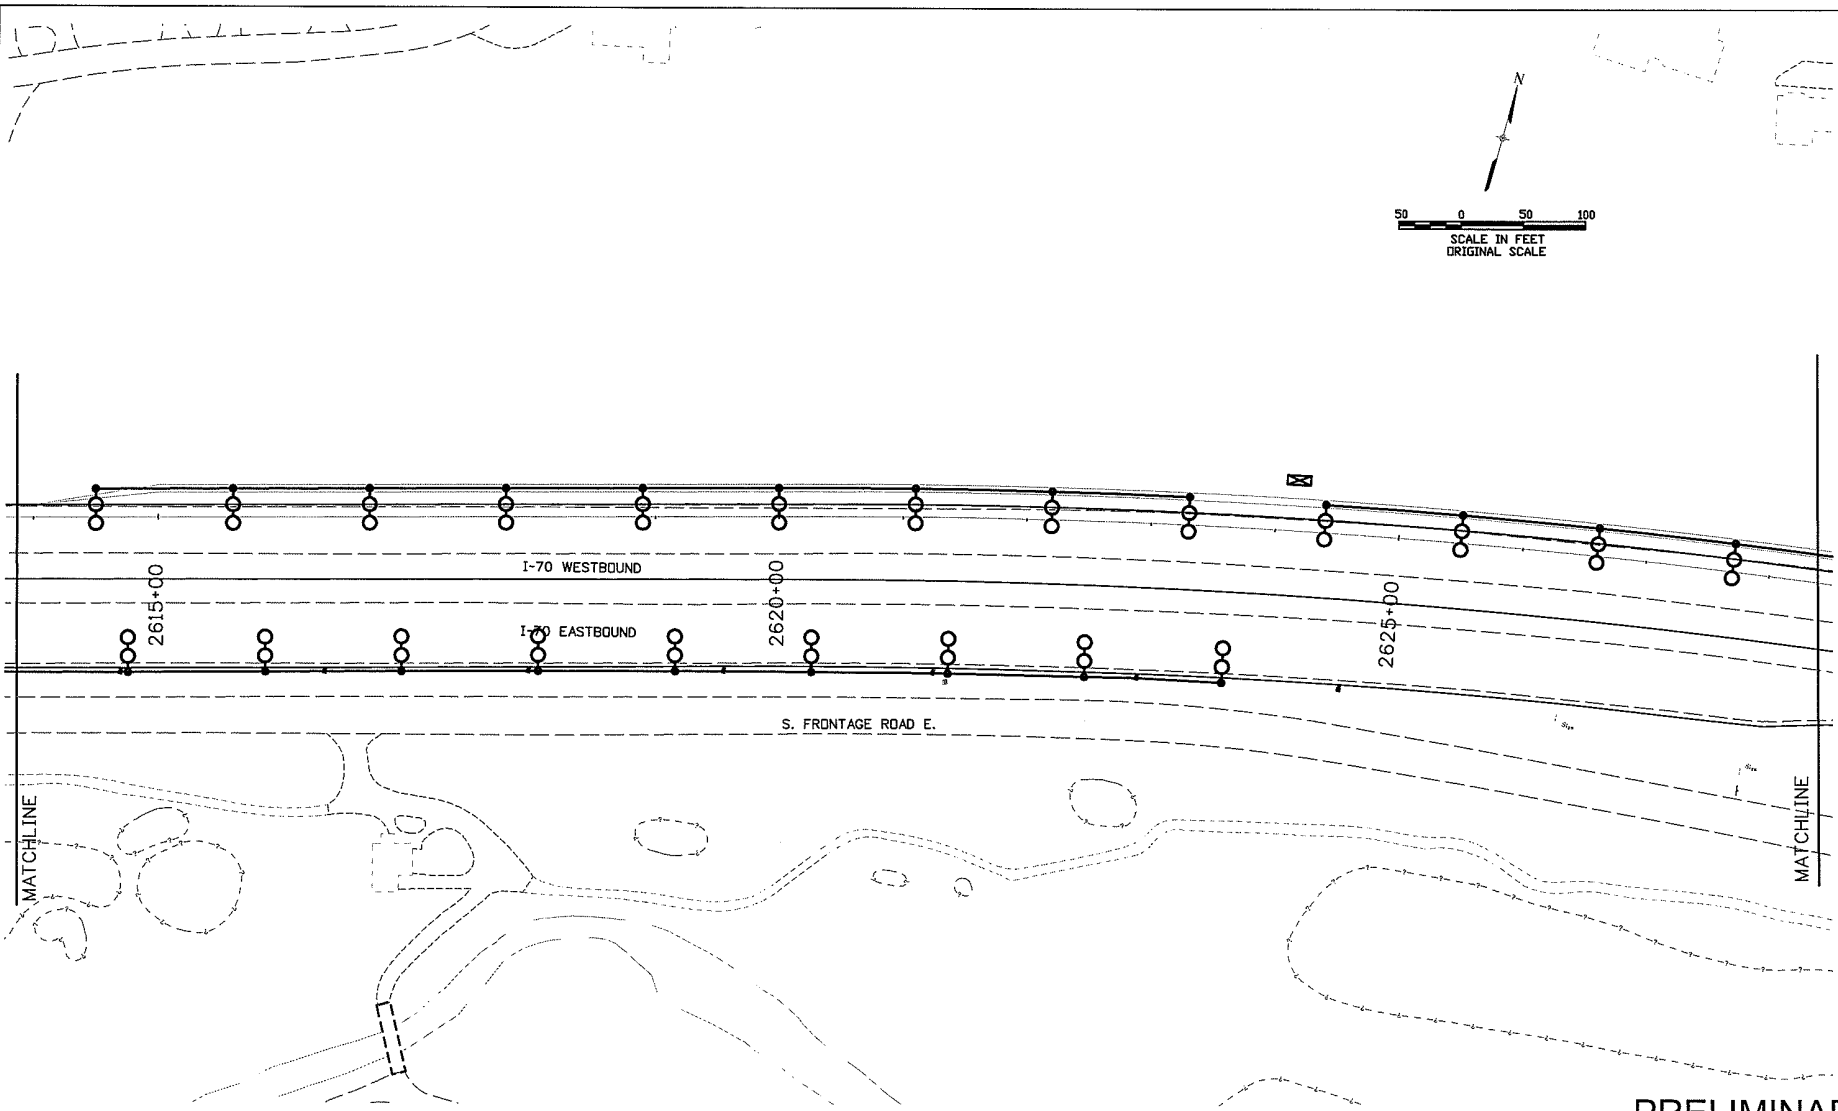

CLANTON & ASSOCIATES LIGHTING DESIGN AND ENGINEERING
 6899 N. W. COURSE SOUTH, STE. 102
 DENVER, CO 80237
 303-532-7529

Computer File Information	
Creation Date:	Initials: GF
Last Modification Date:	Initials: JE
Full Path: Z:\VAIL CHAIN STATIONS\CURRNET\	
Drawing File Name:	
Scale: REFER TO BAR SCALE	Units: ENGLISH

Index of Revisions	



Region 1
 16500 East Colfax
 Aurora, CO 80011
 Phone: (303) 365-7340
 FAX: (303) 365-7343




4601 DTC Blvd.
 Suite 700
 Denver, CO 80237
 Phone: (303) 221-7275
 Fax: (303) 221-7276

As Constructed
No. Revisions:
Revised:
Void:

LIGHTING PLAN - MP 177 PLAN & SWMP SITE MAP		
Designer:	GF	Structure
Detailer:	JE	Numbers
Sheet Subset:	LE	Subset Sheets: 03 OF 24

Project No./Code
IM 070A-003
16701
Sheet Number: 24

PRELIMINARY
 SUBJECT TO REVISION

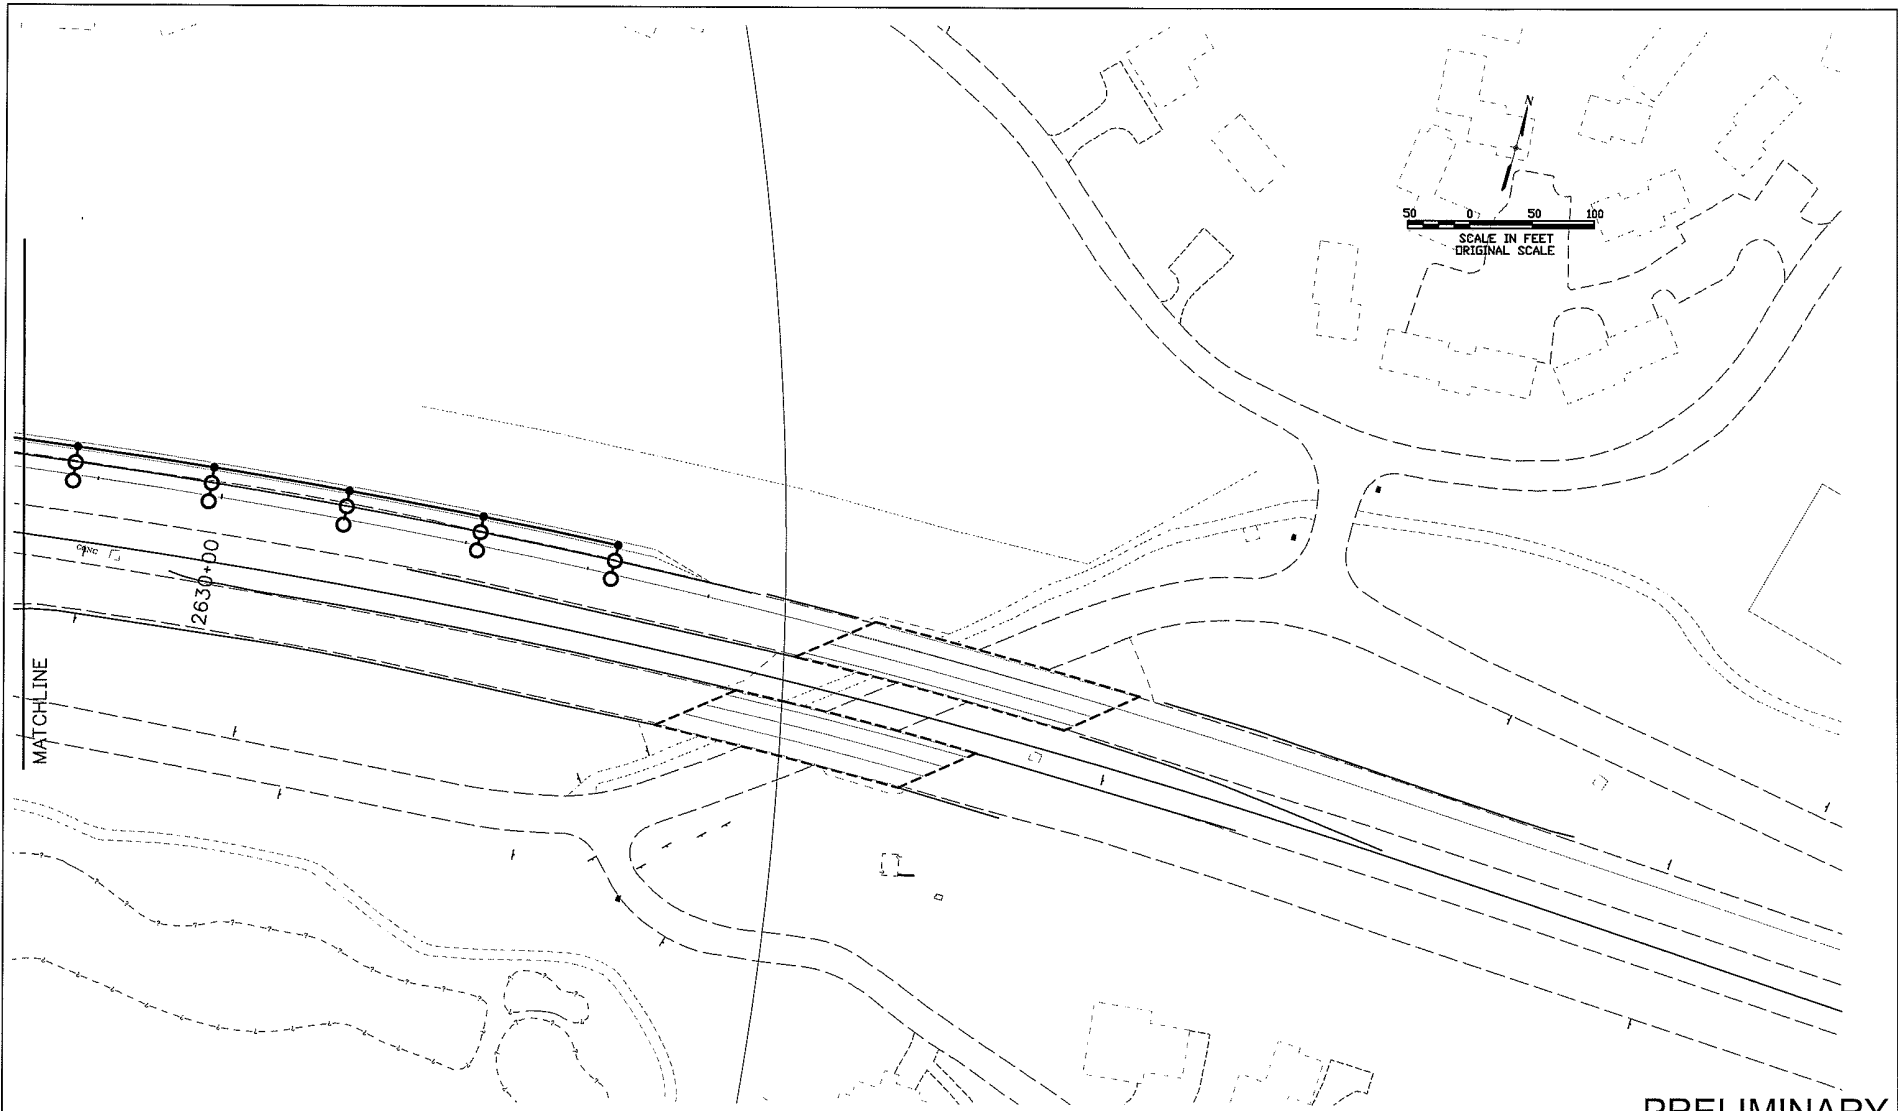

CLANTON & ASSOCIATES LIGHTING DESIGN AND ENGINEERING
 4899 N. JULES COURT, SUITE 107
 PUEBLO, CO 81009
 303-853-7079

Computer File Information	
Creation Date:	Initials: GF
Last Modification Date:	Initials: JE
Full Path: Z:\VAIL_CHAIN STATIONS\CURRNET\	
Drawing File Name:	
Scale: REFER TO BAR SCALE	Units: ENGLISH

Index of Revisions	

DOT
 DEPARTMENT OF TRANSPORTATION
 Region 1
 18500 East Colfax
 Aurora, CO 80011
 Phone: (303) 365-7340
 FAX: (303) 365-7343

REGION I **DW**


PBSJ
 4601 DTC Blvd.
 Suite 700
 Denver, CO 80237
 Phone: (303) 221-7275
 Fax: (303) 221-7276

As Constructed
No. Revisions:
Revised:
Void:

LIGHTING PLAN - MP 183 PLAN & SWMP SITE MAP		
Designer:	GF	Structure
Detailer:	JE	Numbers
Sheet Subset:	LE	Subset Sheets: 04 OF 24

Project No./Code
IM 070A-003
16701
Sheet Number: 25

PRELIMINARY
 SUBJECT TO REVISION

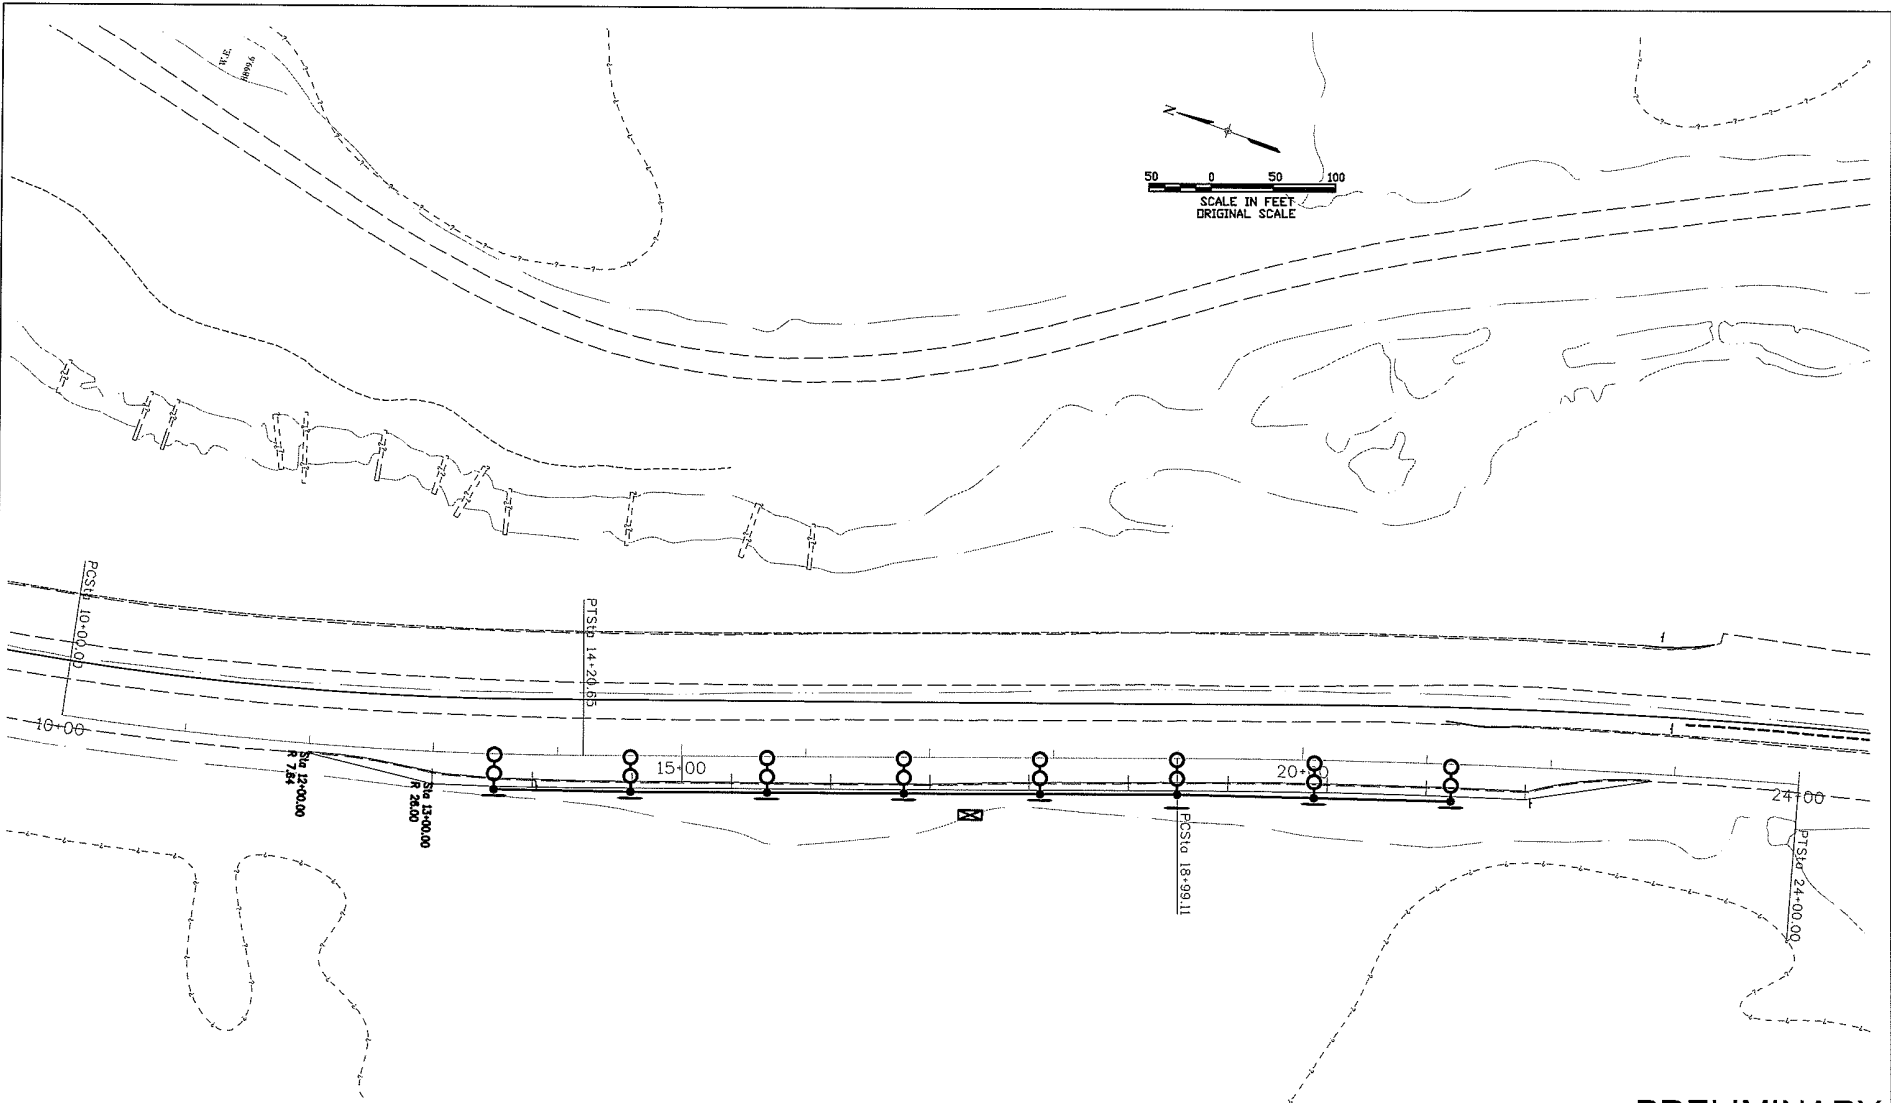



CLANTON & ASSOCIATES
 LIGHTING DESIGN AND ENGINEERING
 4699 N. JULES COURT, SUITE 102
 PUEBLO, CO 81015
 303-435-0299

Computer File Information	
Creation Date:	Initials: GF
Last Modification Date:	Initials: JE
Full Path: Z:\VAIL_CHAIN STATIONS\CURRNET\	
Drawing File Name:	
Scale: REFER TO BAR SCALE	Units: ENGLISH

Index of Revisions	


DOT
 DEPARTMENT OF TRANSPORTATION
 Region 1
 18500 East Colfax
 Aurora, CO 80011
 Phone: (303) 365-7340
 FAX: (303) 365-7343

REGION I **DW**



PBSJ
 4601 DTC Blvd.
 Suite 700
 Denver, CO 80237
 Phone: (303) 221-7275
 Fax: (303) 221-7276

As Constructed
No. Revisions:
Revised:
Void:

LIGHTING PLAN - MP 183 PLAN & SWMP SITE MAP		
Designer:	GF	Structure
Detailer:	JE	Numbers
Sheet Subset:	LE	Subset Sheets:

Project No./Code
IM 070A-003
16701
Sheet Number: 26

PRELIMINARY
 SUBJECT TO REVISION

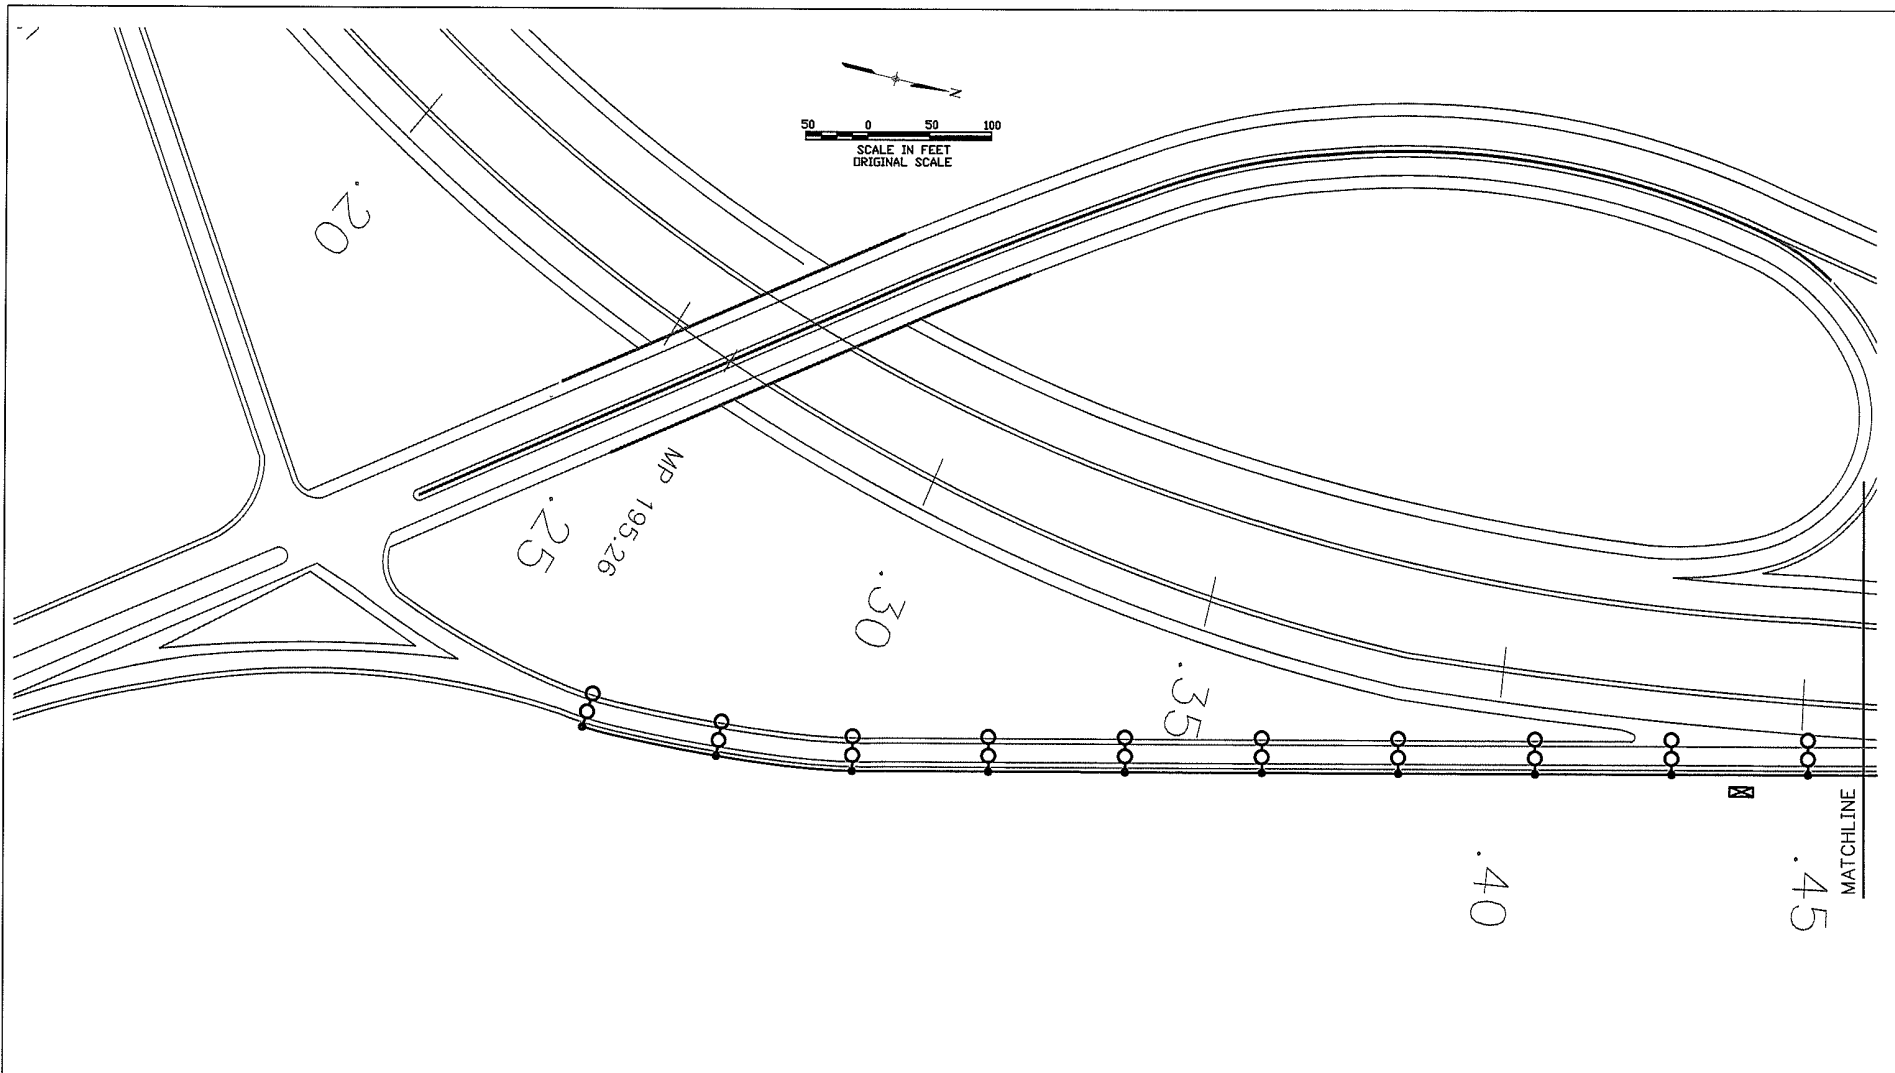

CLANTON & ASSOCIATES LIGHTING DESIGN AND ENGINEERING
 4599 KUIP AVE. SUITE 100 • STE. 02
 PUEBLO, CO 81001
 303-435-6229

Computer File Information	
Creation Date:	Initials: GF
Last Modification Date:	Initials: JE
Full Path: Z:\VAIL CHAIN STATIONS\CURRNET\	
Drawing File Name:	
Scale: REFER TO BAR SCALE	Units: ENGLISH

Index of Revisions	

DOT
 DEPARTMENT OF TRANSPORTATION

Region 1
 18500 East Colfax
 Aurora, CO 80011
 Phone: (303) 365-7340
 FAX: (303) 365-7343

REGION I DW


PBSJ
 4801 DTC Blvd.
 Suite 700
 Denver, CO 80237
 Phone: (303) 221-7275
 Fax: (303) 221-7276

As Constructed
No. Revisions:
Revised:
Void:

LIGHTING PLAN - MP 195 PLAN & SWMP SITE MAP		
Designer:	GF	Structure
Detailer:	JE	Numbers
Sheet Subset:	LE	Subset Sheets: 06 OF 24

Project No./Code
IM 070A-003
16701
Sheet Number: 27

PRELIMINARY
 SUBJECT TO REVISION

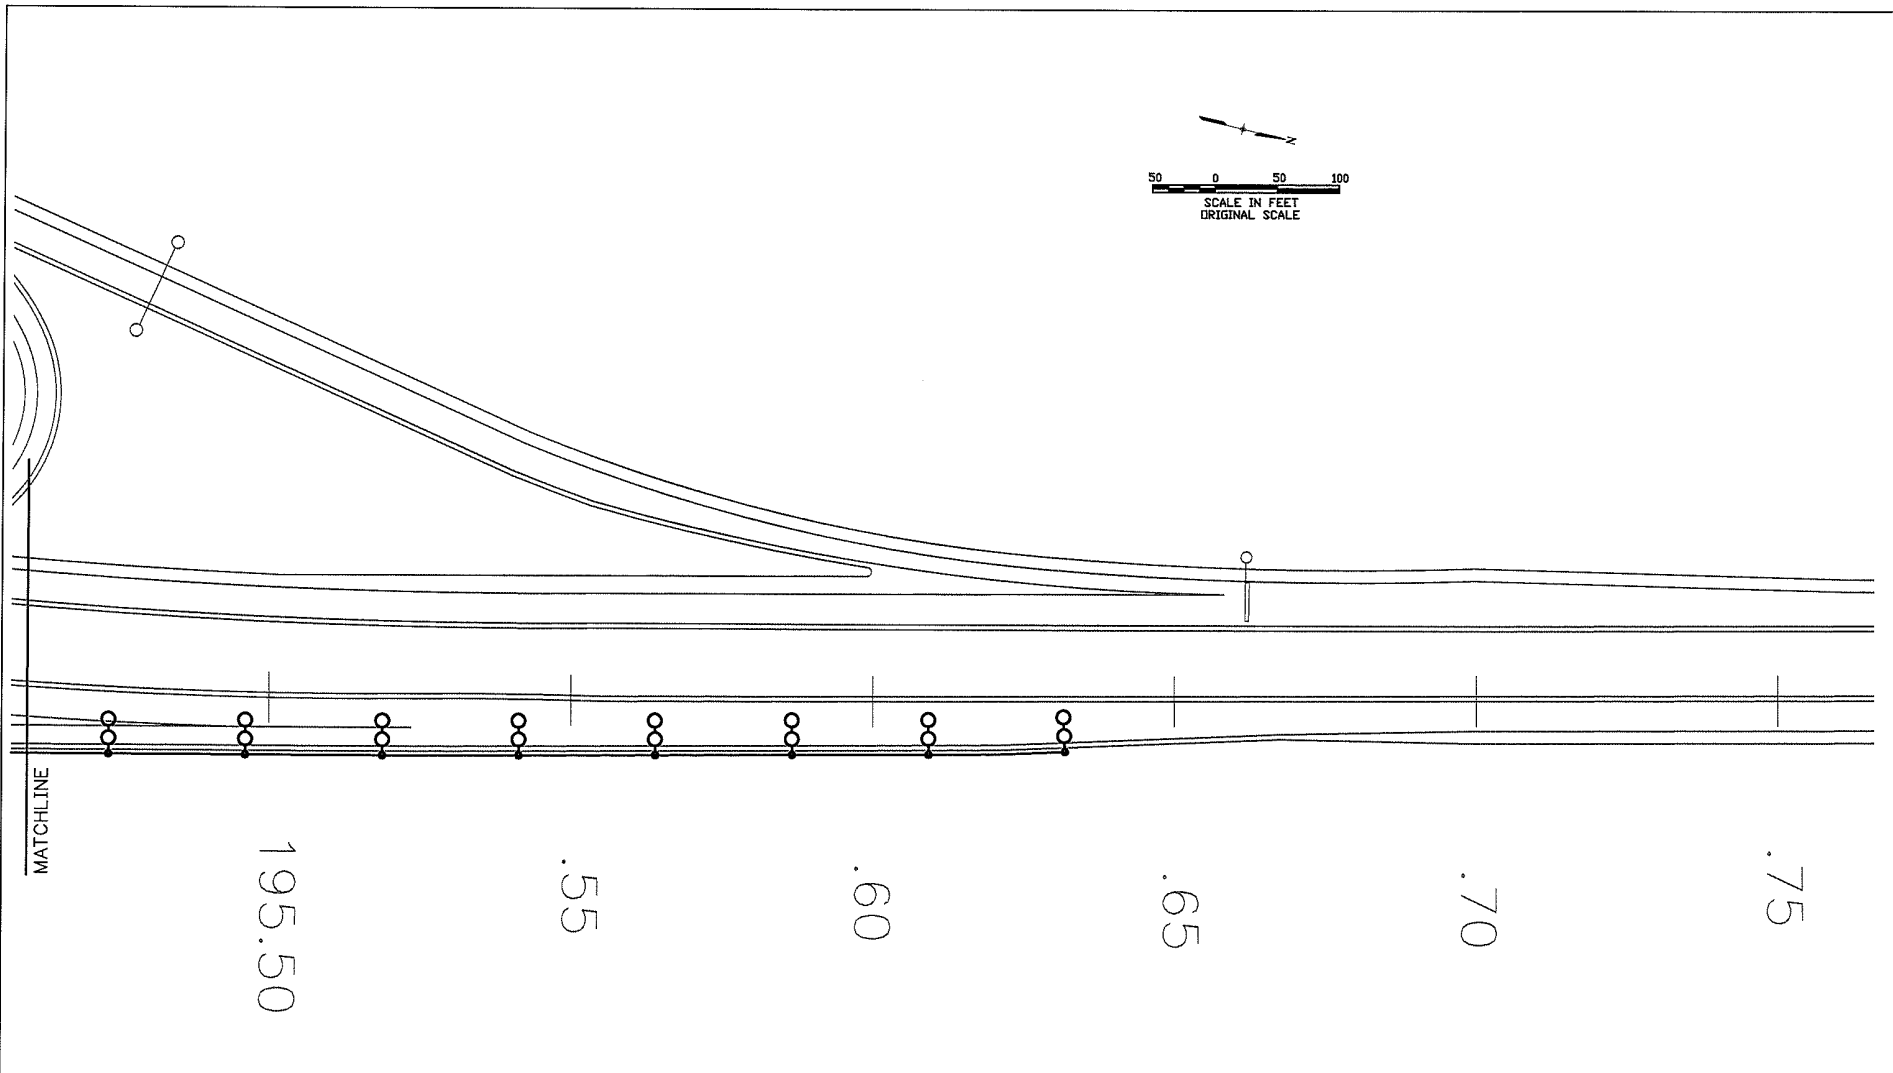

CLANTON & ASSOCIATES LIGHTING DESIGN AND ENGINEERING
 1499 KATYUK COOPER SOUTH STE 102
 BOULDER, CO 80501
 303-442-7274

PRELIMINARY
 SUBJECT TO REVISION

Computer File Information	
Creation Date:	Initials: GF
Last Modification Date:	Initials: JE
Full Path: Z:\VAIL CHAIN STATIONS\CURRENT\	
Drawing File Name:	
Scale: REFER TO BAR SCALE	Units: ENGLISH

Index of Revisions	




REGION I DW

PBSJ
 4601 DTC Blvd.
 Suite 700
 Denver, CO 80237
 Phone: (303) 221-7275
 Fax: (303) 221-7276

As Constructed	
No. Revisions:	
Revised:	
Void:	

LIGHTING PLAN - MP 195 PLAN & SWMP SITE MAP			
Designer:	GF	Structure	
Detailer:	JE	Numbers	
Sheet Subset:	LE	Subset Sheets:	07 OF 24

Project No./Code	
IM 070A-003	
16701	
Sheet Number:	28

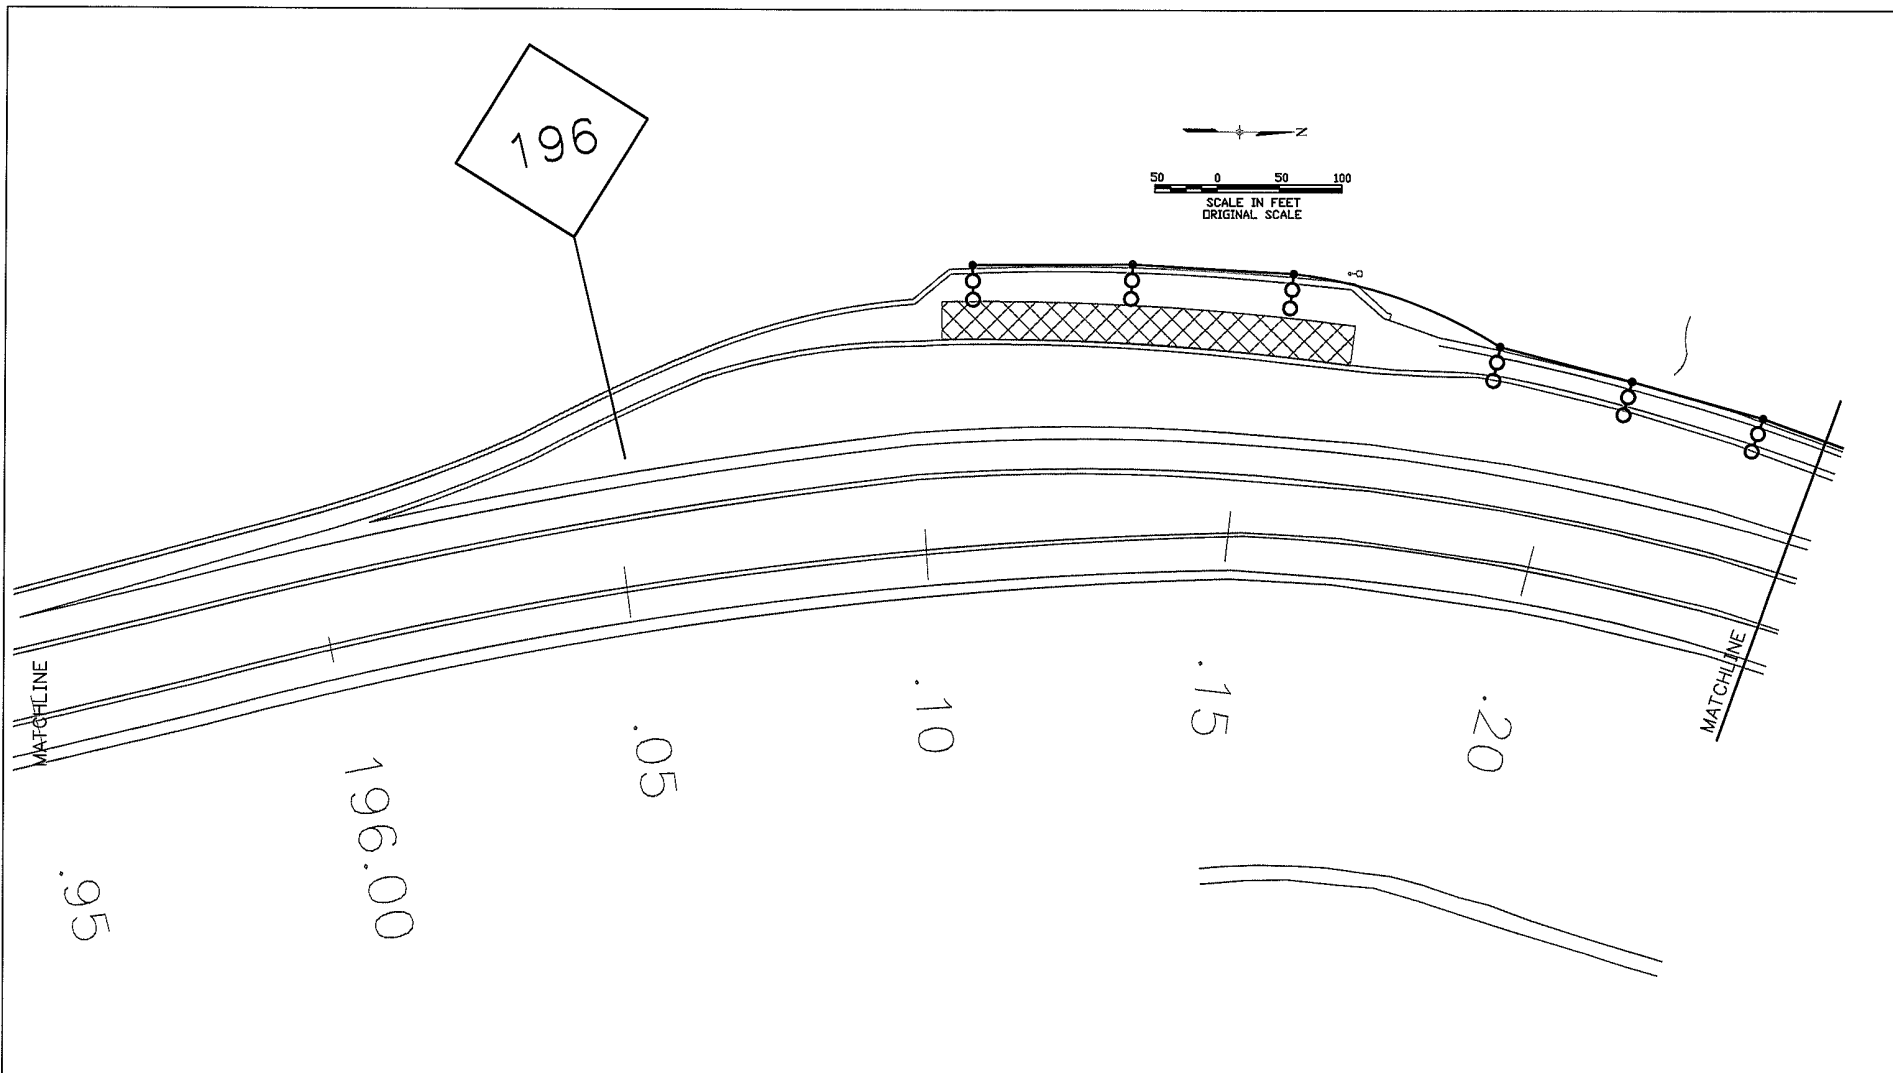

CLANTON & ASSOCIATES LIGHTING DESIGN AND ENGINEERING
 6499 VALLEY VIEW COURT SOUTH STE. 102
 BOWLING GREEN, CO 80209
 303-437-9709

Computer File Information	
Creation Date:	Initials: GF
Last Modification Date:	Initials: JE
Full Path: Z:\VAR_CHAIN STATIONS\CURRNET\	
Drawing File Name:	
Scale: REFER TO BAR SCALE	Units: ENGLISH

Index of Revisions	
0000	



REGION I DW



4601 DTC Blvd.
 Suite 700
 Denver, CO 80237
 Phone: (303) 221-7275
 Fax: (303) 221-7276


As Constructed
No. Revisions:
Revised:
Void:

LIGHTING PLAN - MP 196 PLAN & SWMP SITE MAP		
Designer:	GF	Structure
Detailer:	JE	Numbers
Sheet Subset:	LE	Subset Sheets:

Project No./Code
IM 070A-003
16701
Sheet Number: 29

PRELIMINARY
 SUBJECT TO REVISION

08 OF 24

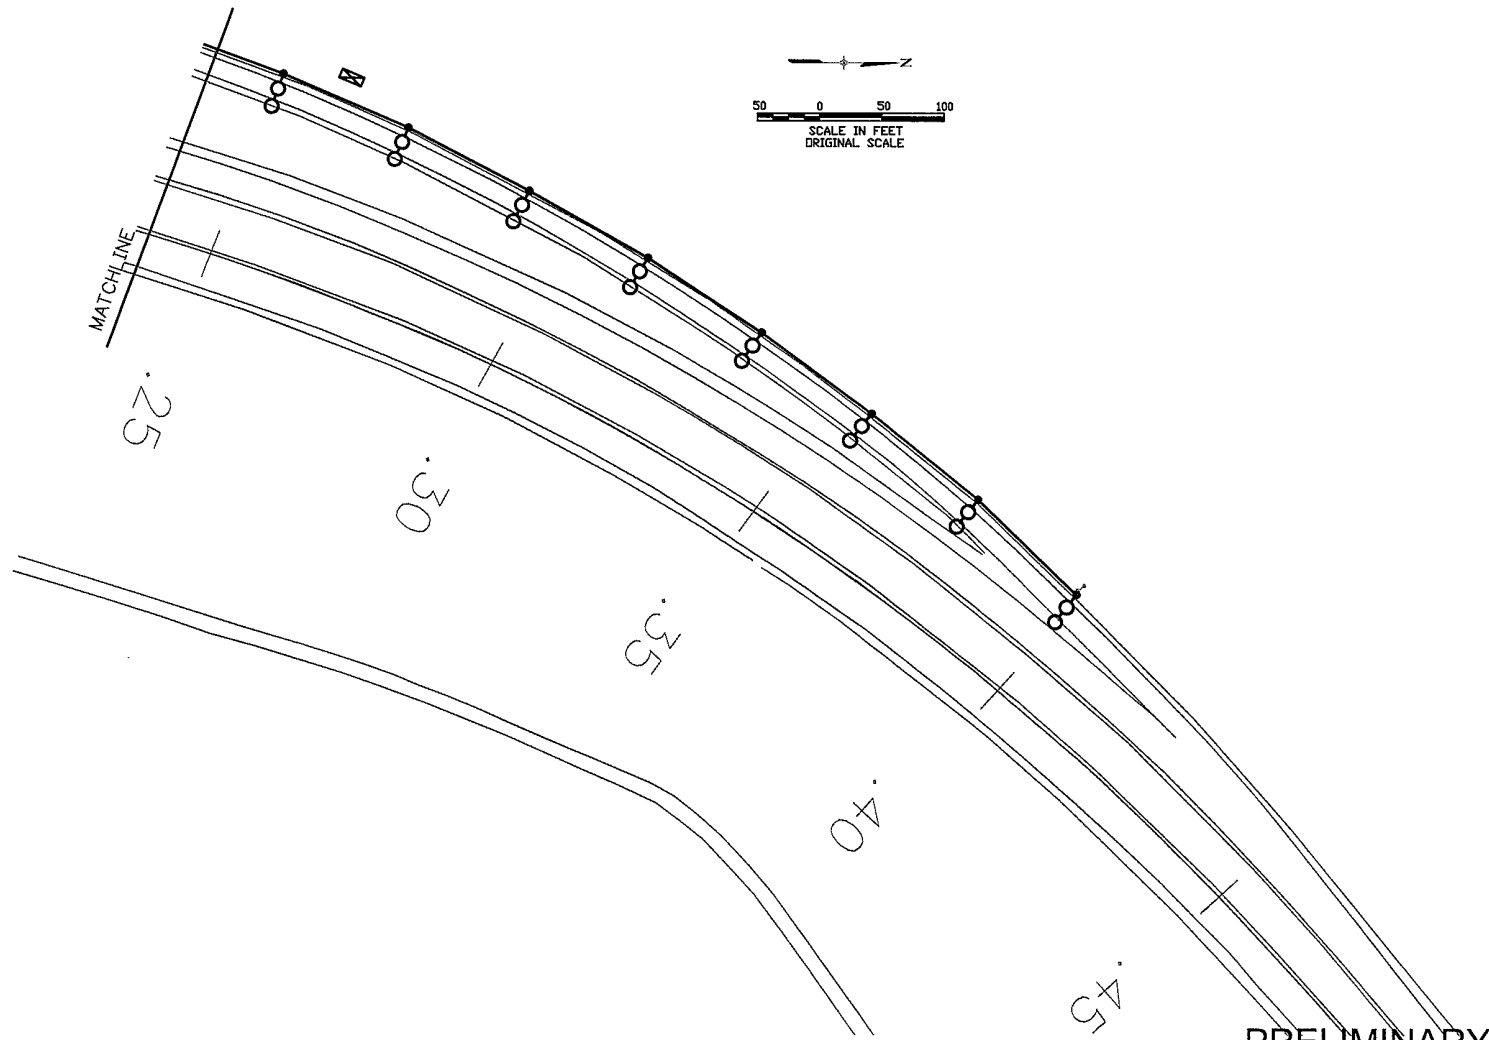

PRELIMINARY
SUBJECT TO REVISION

CLANTON & ASSOCIATES LIGHTING DESIGN AND ENGINEERING
 4899 N. JEFFERSON COURT, SUITE 102
 DENVER, CO 80221
 303-435-7104

Computer File Information	
Creation Date:	Initials: GF
Last Modification Date:	Initials: JE
Full Path: Z:\VAIL CHAIN STATIONS\CURRNET\	
Drawing File Name:	
Scale: REFER TO BAR SCALE	Units: ENGLISH

Index of Revisions	

DOT
 DEPARTMENT OF TRANSPORTATION

Region 1
 18500 East Colfax
 Aurora, CO 80011
 Phone: (303) 365-7340
 FAX: (303) 365-7343

REGION I DW


PBSJ

4601 DTC Blvd.
 Suite 700
 Denver, CO 80237
 Phone: (303) 221-7275
 Fax: (303) 221-7276

As Constructed
No. Revisions:
Revised:
Void:

LIGHTING PLAN - MP 196 PLAN & SWMP SITE MAP	
Designer: GF	Structure
Detailer: JE	Numbers
Sheet Subset: LE	Subset Sheets: 09 OF 24

Project No./Code
IM 070A-003
16701
Sheet Number: 30

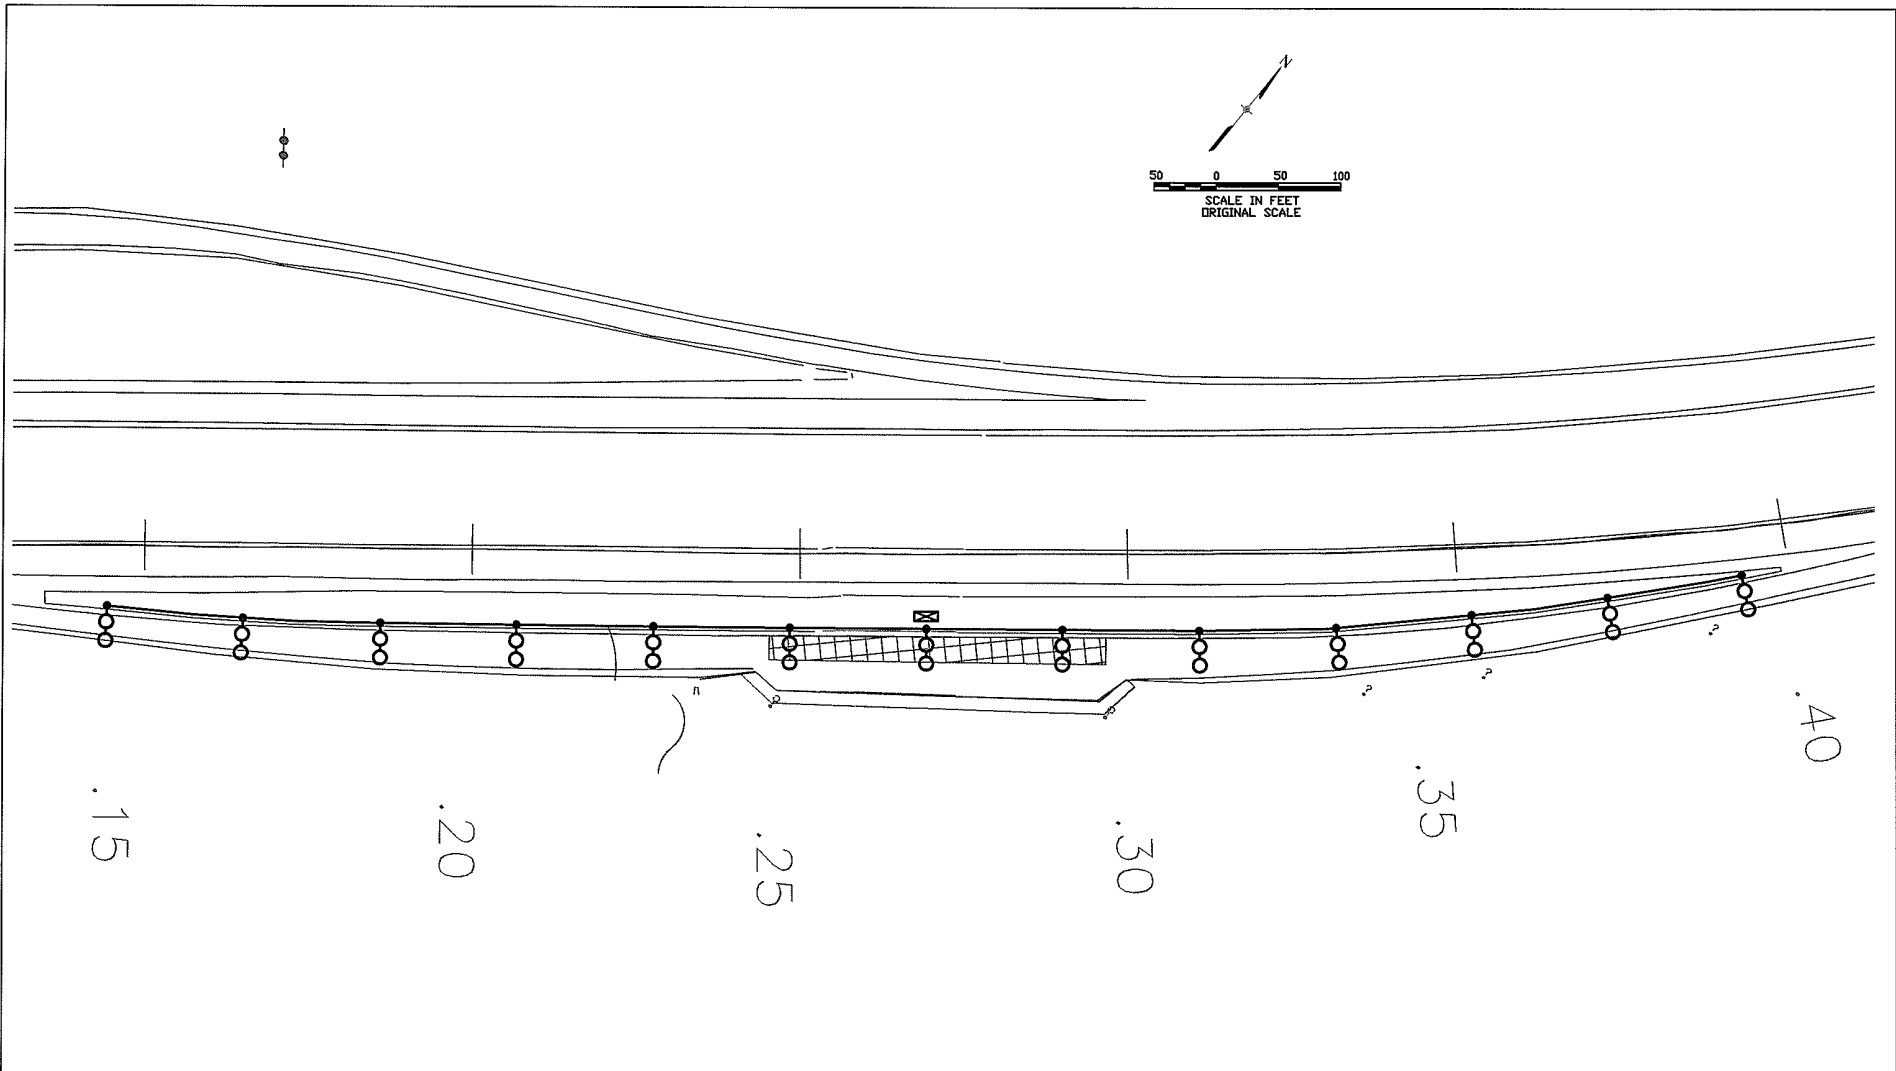


CLANTON & ASSOCIATES LIGHTING DESIGN AND ENGINEERING
 4499 N. HUNTER COURT SOUTH STE 107
 DENVER, CO 80237
 303-433-7279

Computer File Information	
Creation Date:	Initials: GF
Last Modification Date:	Initials: JE
Full Path: Z:\VAIL CHAIN STATIONS\CURRNET\	
Drawing File Name:	
Scale: REFER TO BAR SCALE	Units: ENGLISH

Index of Revisions	



REGION I DW



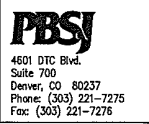


As Constructed
No. Revisions:
Revised:
Void:

LIGHTING PLAN - MP 203 PLAN & SWMP SITE MAP		
Designer:	GF	Structure
Detailer:	JE	Numbers
Sheet Subset:	LE	Subset Sheets: 10 OF 24

PRELIMINARY
 SUBJECT TO REVISION

Project No./Code	IM 070A-003
Sheet Number:	3/

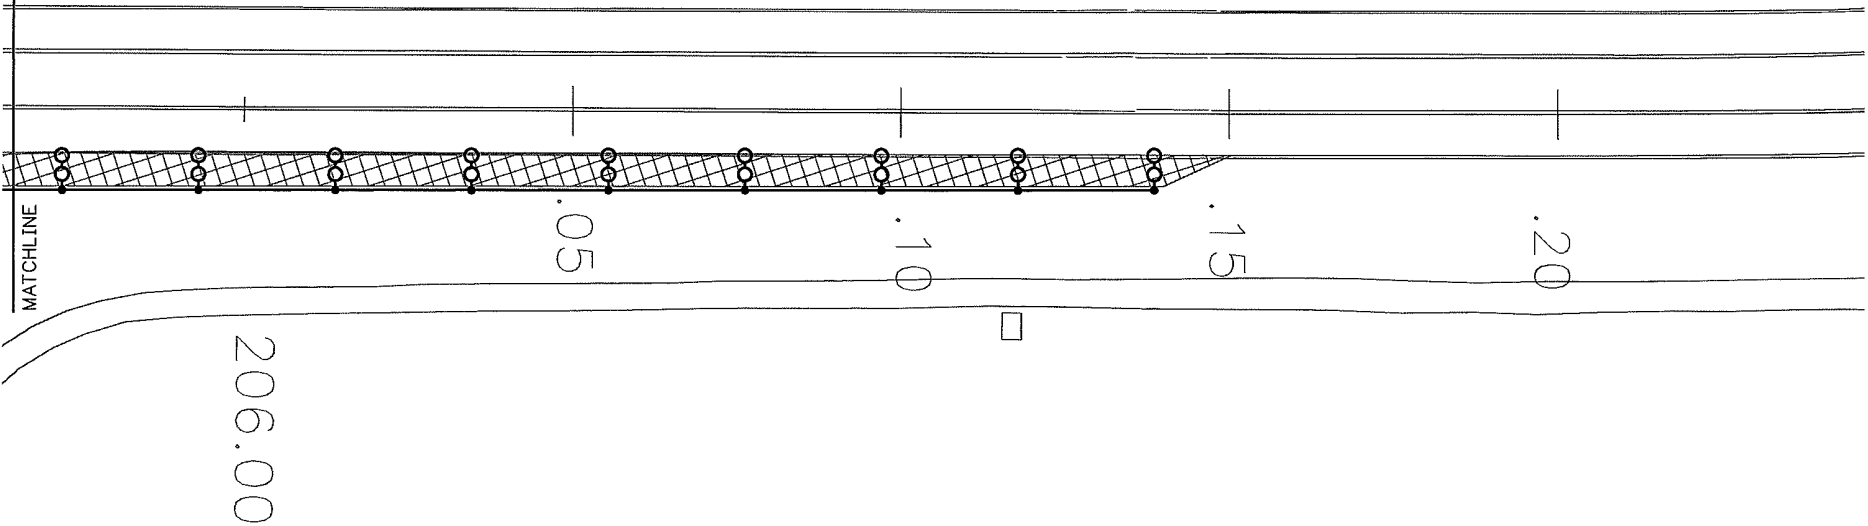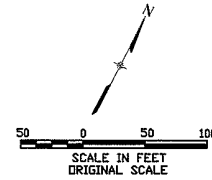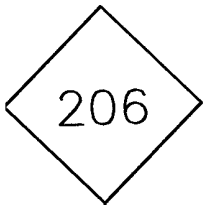


CLANTON & ASSOCIATES LIGHTING DESIGN AND ENGINEERING
 6499 HALF MOON COURT SOUTH STE 102
 BROOMFIELD, CO 80020
 303-435-9229

Computer File Information	
Creation Date:	Initials: GF
Last Modification Date:	Initials: JE
Full Path: Z:\VAIL CHAIN STATIONS\CURRNET\	
Drawing File Name:	
Scale: REFER TO BAR SCALE	Units: ENGLISH

Index of Revisions	



REGION I DW

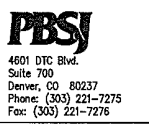


As Constructed	
No. Revisions:	
Revised:	
Void:	

LIGHTING PLAN - MP 205 PLAN & SWMP SITE MAP			
Designer:	GF	Structure	
Detailer:	JE	Numbers	
Sheet Subset:	LE	Subset Sheets:	12 OF 24

PRELIMINARY
SUBJECT TO REVISION

Project No./Code	
IM 070A-003	
16701	
Sheet Number:	33

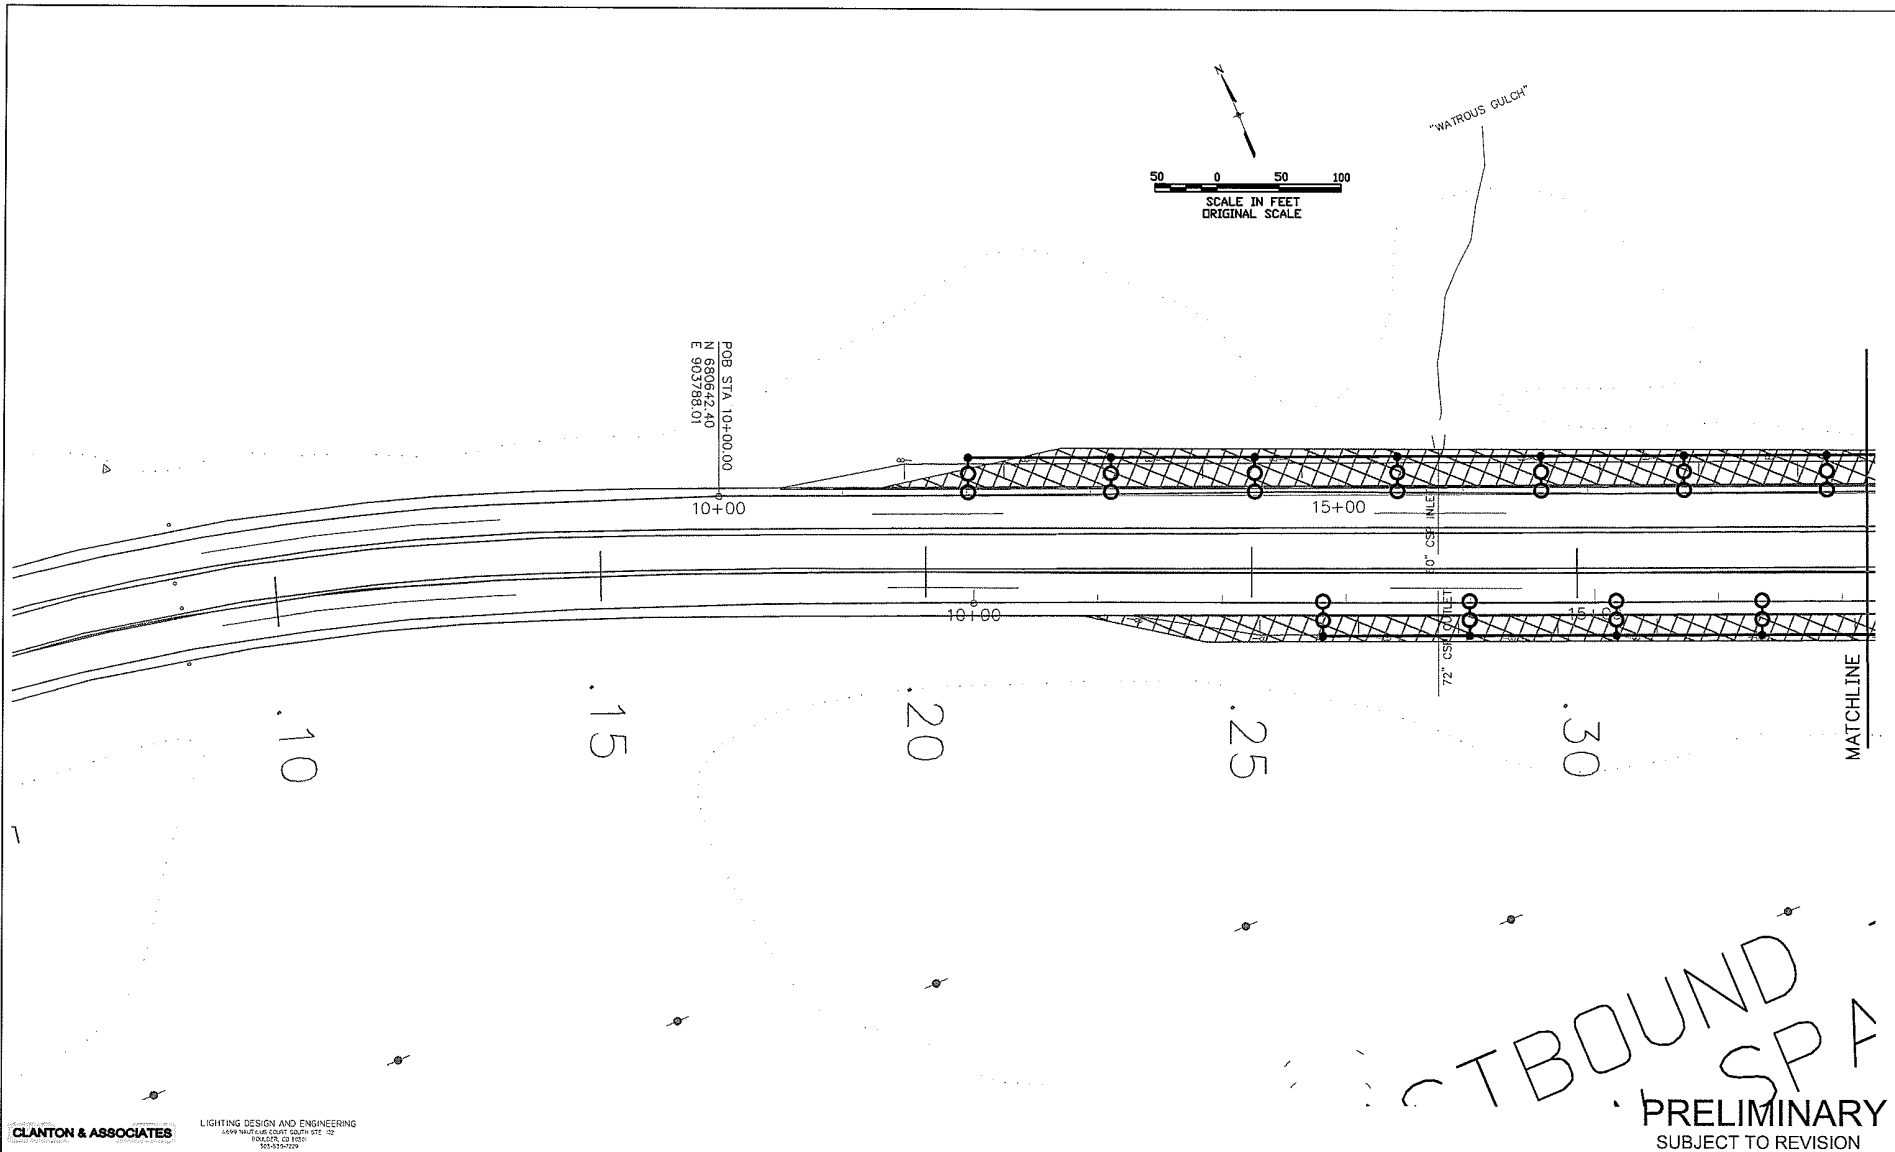

CLANTON & ASSOCIATES LIGHTING DESIGN AND ENGINEERING
 6499 VALDEZ COURT SOUTH STE 102
 DENVER, CO 80237
 303-555-7279

Computer File Information	
Creation Date:	Initials: GF
Last Modification Date:	Initials: JE
Full Path: Z:\VAIL CHAIN STATIONS\CURRNET\	
Drawing File Name:	
Scale: REFER TO BAR SCALE	Units: ENGLISH

Index of Revisions	



DOT
 DEPARTMENT OF TRANSPORTATION
 Region 1
 16500 East Colfax
 Aurora, CO 80011
 Phone: (303) 365-7340
 FAX: (303) 365-7343

PBSJ
 4601 DTC Blvd.
 Suite 700
 Denver, CO 80237
 Phone: (303) 221-7275
 Fax: (303) 221-7276

As Constructed
No. Revisions:
Revised:
Void:

LIGHTING PLAN - MP 219 EAST & PLAN & SWMP SITE MAP		
Designer:	GF	Structure
Detailer:	JE	Numbers
Sheet Subset:	LE	Subset Sheets: 14 OF 24


Project No./Code
IM 070A-003
16701
Sheet Number: 35

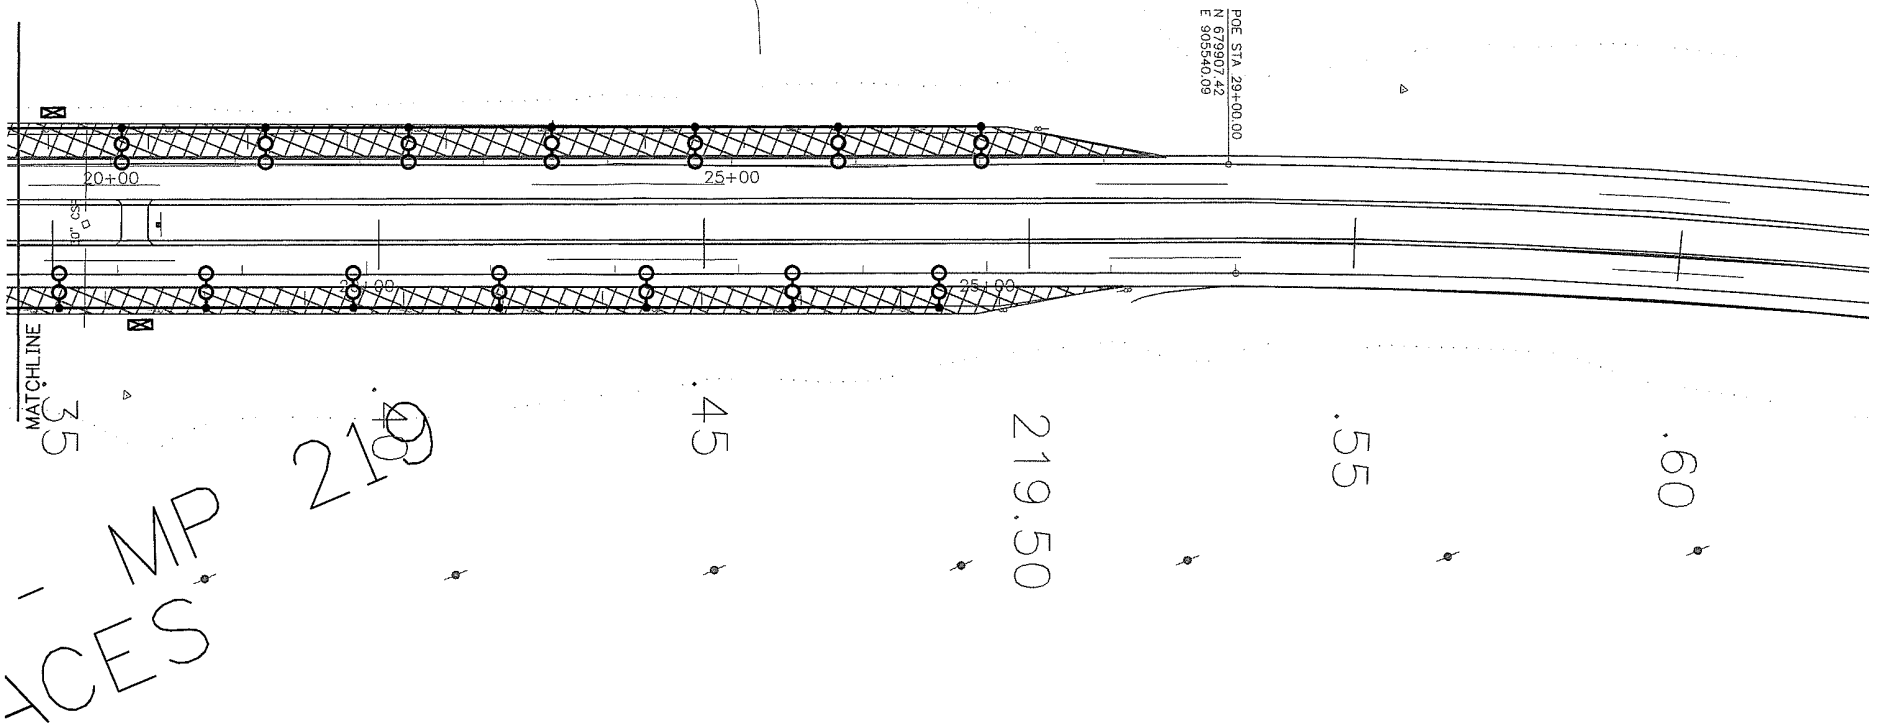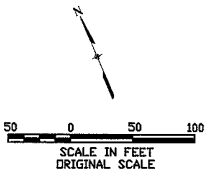



 LIGHTING DESIGN AND ENGINEERING
 4499 AIR FORCE COURT, SUITE 102
 BOULDER, CO 80504
 303-440-7229

Computer File Information	
Creation Date:	Initials: GF
Last Modification Date:	Initials: JE
Full Path: Z:\VAIL CHAIN STATIONS\CURRNET\	
Drawing File Name:	
Scale: REFER TO BAR SCALE	Units: ENGLISH

Index of Revisions	


 Region 1
 18500 East Colfax
 Aurora, CO 80011
 Phone: (303) 365-7340
 FAX: (303) 365-7343
 DEPARTMENT OF TRANSPORTATION
 REGION I DW




 4801 DTC Blvd.
 Suite 700
 Denver, CO 80237
 Phone: (303) 221-7275
 Fax: (303) 221-7276

As Constructed
No. Revisions:
Revised:
Void:

LIGHTING PLAN - MP 219 PLAN & SWMP SITE MAP		
Designer:	GF	Structure
Detailer:	JE	Numbers
Sheet Subset:	LE	Subset Sheets:

Project No./Code
IM 070A-003
16701
Sheet Number: 36

PRELIMINARY
 SUBJECT TO REVISION

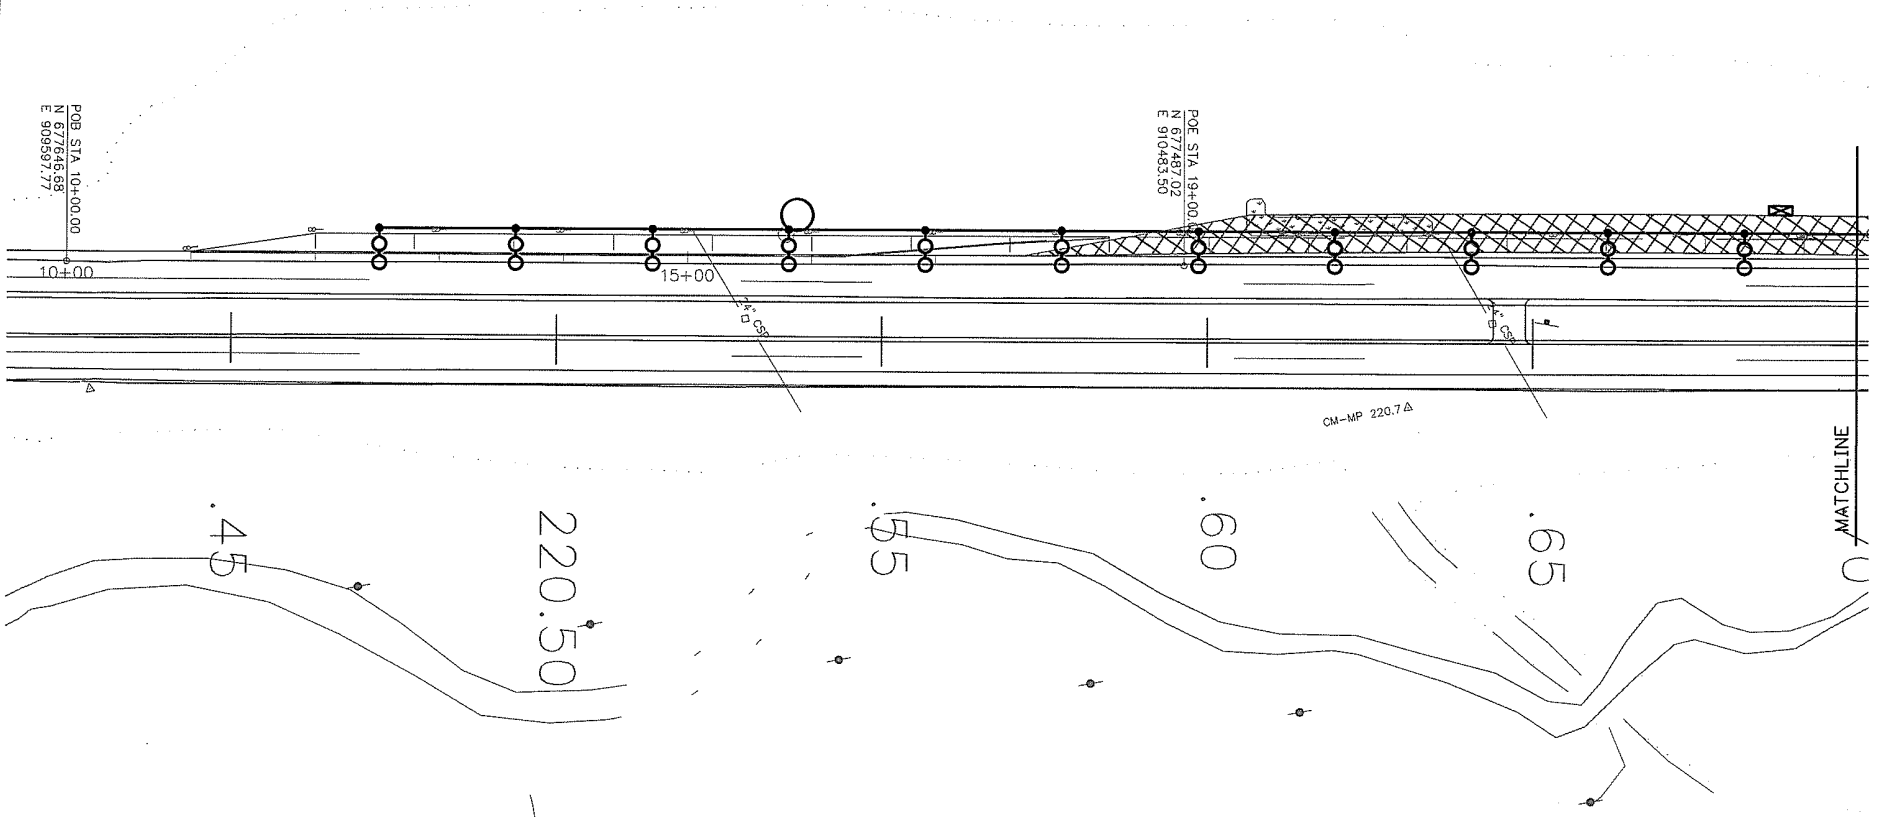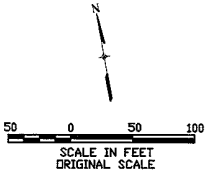

CLANTON & ASSOCIATES LIGHTING DESIGN AND ENGINEERING
 6599 N. W. 10TH AVE. SUITE 102
 BOULDER, CO 80504
 303-440-7029

Computer File Information	
Creation Date:	Initials: GF
Last Modification Date:	Initials: JE
Full Path: Z:\VAIL_CHAIN STATIONS\CURRNET\	
Drawing File Name:	
Scale: REFER TO BAR SCALE	Units: ENGLISH

Index of Revisions	

DOT Region 1
 16500 East Colfax
 Aurora, CO 80011
 Phone: (303) 365-7340
 FAX: (303) 365-7343

REGION I DW



PBSJ
 4801 DTC Blvd.
 Suite 700
 Denver, CO 80237
 Phone: (303) 221-7275
 Fax: (303) 221-7276

As Constructed
No. Revisions:
Revised:
Void:

LIGHTING PLAN - MP 221 PLAN & SWMP SITE MAP		
Designer:	GF	Structure
Detailer:	JE	Numbers
Sheet Subset:	LE	Subset Sheets: 16 OF 24

Project No./Code
IM 070A-003
16701
Sheet Number: 37

PRELIMINARY
 SUBJECT TO REVISION

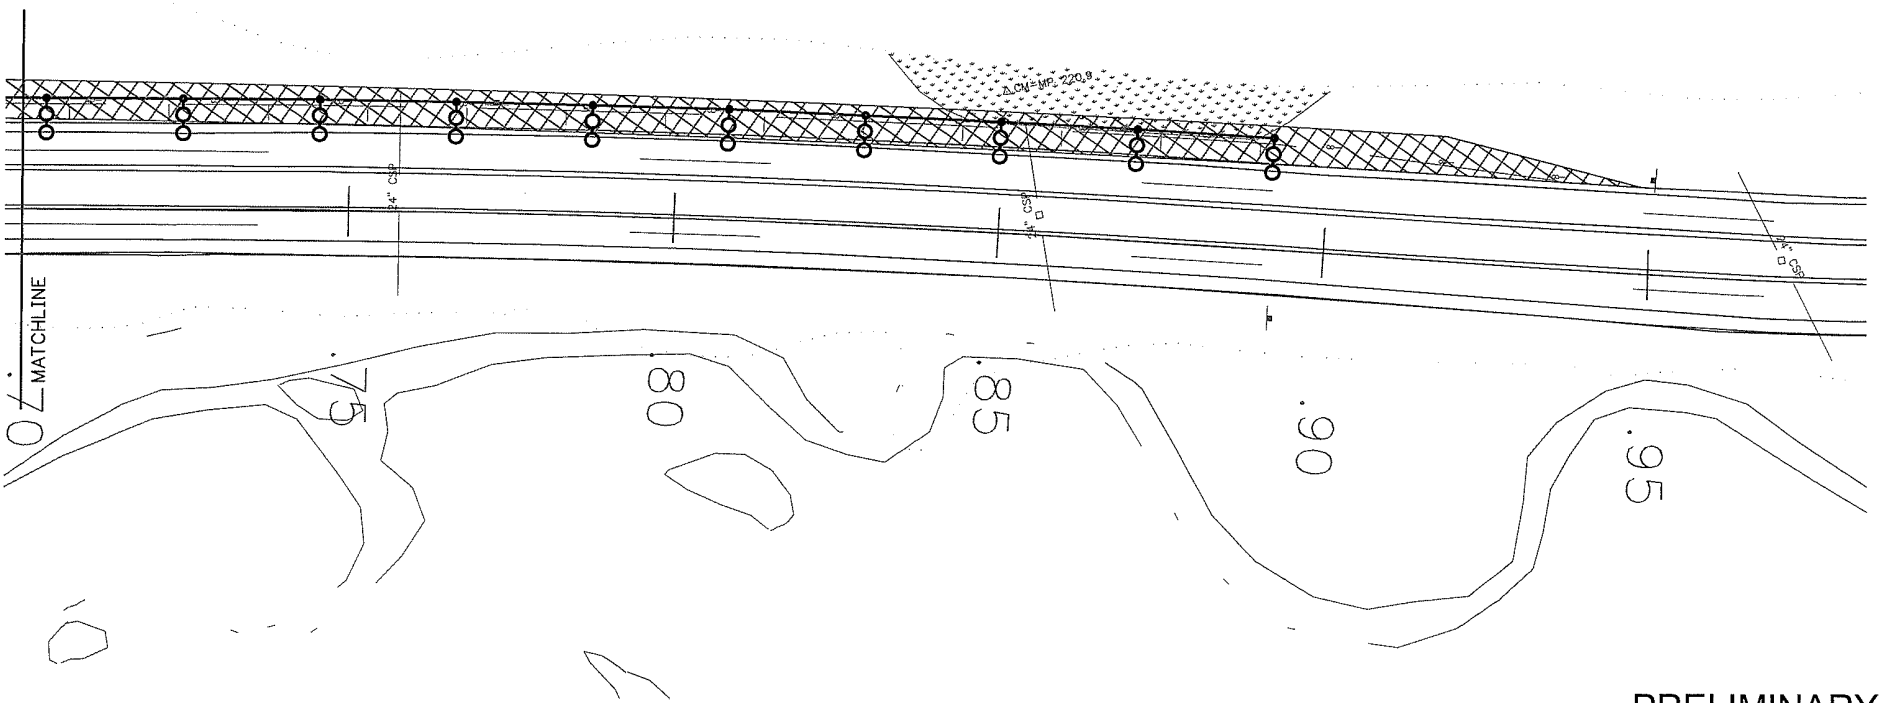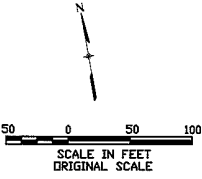

CLANTON & ASSOCIATES LIGHTING DESIGN AND ENGINEERING
 4499 N. HUNTER COURT, SUITE 102
 DENVER, CO 80221
 303-933-2629

PRELIMINARY
 SUBJECT TO REVISION

Computer File Information	
Creation Date:	Initials: GF
Last Modification Date:	Initials: JE
Full Path: Z:\VAIL CHAIN STATIONS\CURRNET\	
Drawing File Name:	
Scale: REFER TO BAR SCALE	Units: ENGLISH

Index of Revisions	

DOT
 REGION I
 DEPARTMENT OF TRANSPORTATION

Region 1
 18500 East Colfax
 Aurora, CO 80011
 Phone: (303) 365-7340
 FAX: (303) 365-7343


PBSJ

4601 DTC Blvd.
 Suite 700
 Denver, CO 80237
 Phone: (303) 221-7275
 Fax: (303) 221-7276

As Constructed
No. Revisions:
Revised:
Void:

LIGHTING PLAN - MP 221 PLAN & SWMP SITE MAP		
Designer:	GF	Structure
Detailer:	JE	Numbers
Sheet Subset:	LE	Subset Sheets:


Project No./Code
IM 070A-003
16701
Sheet Number: 38

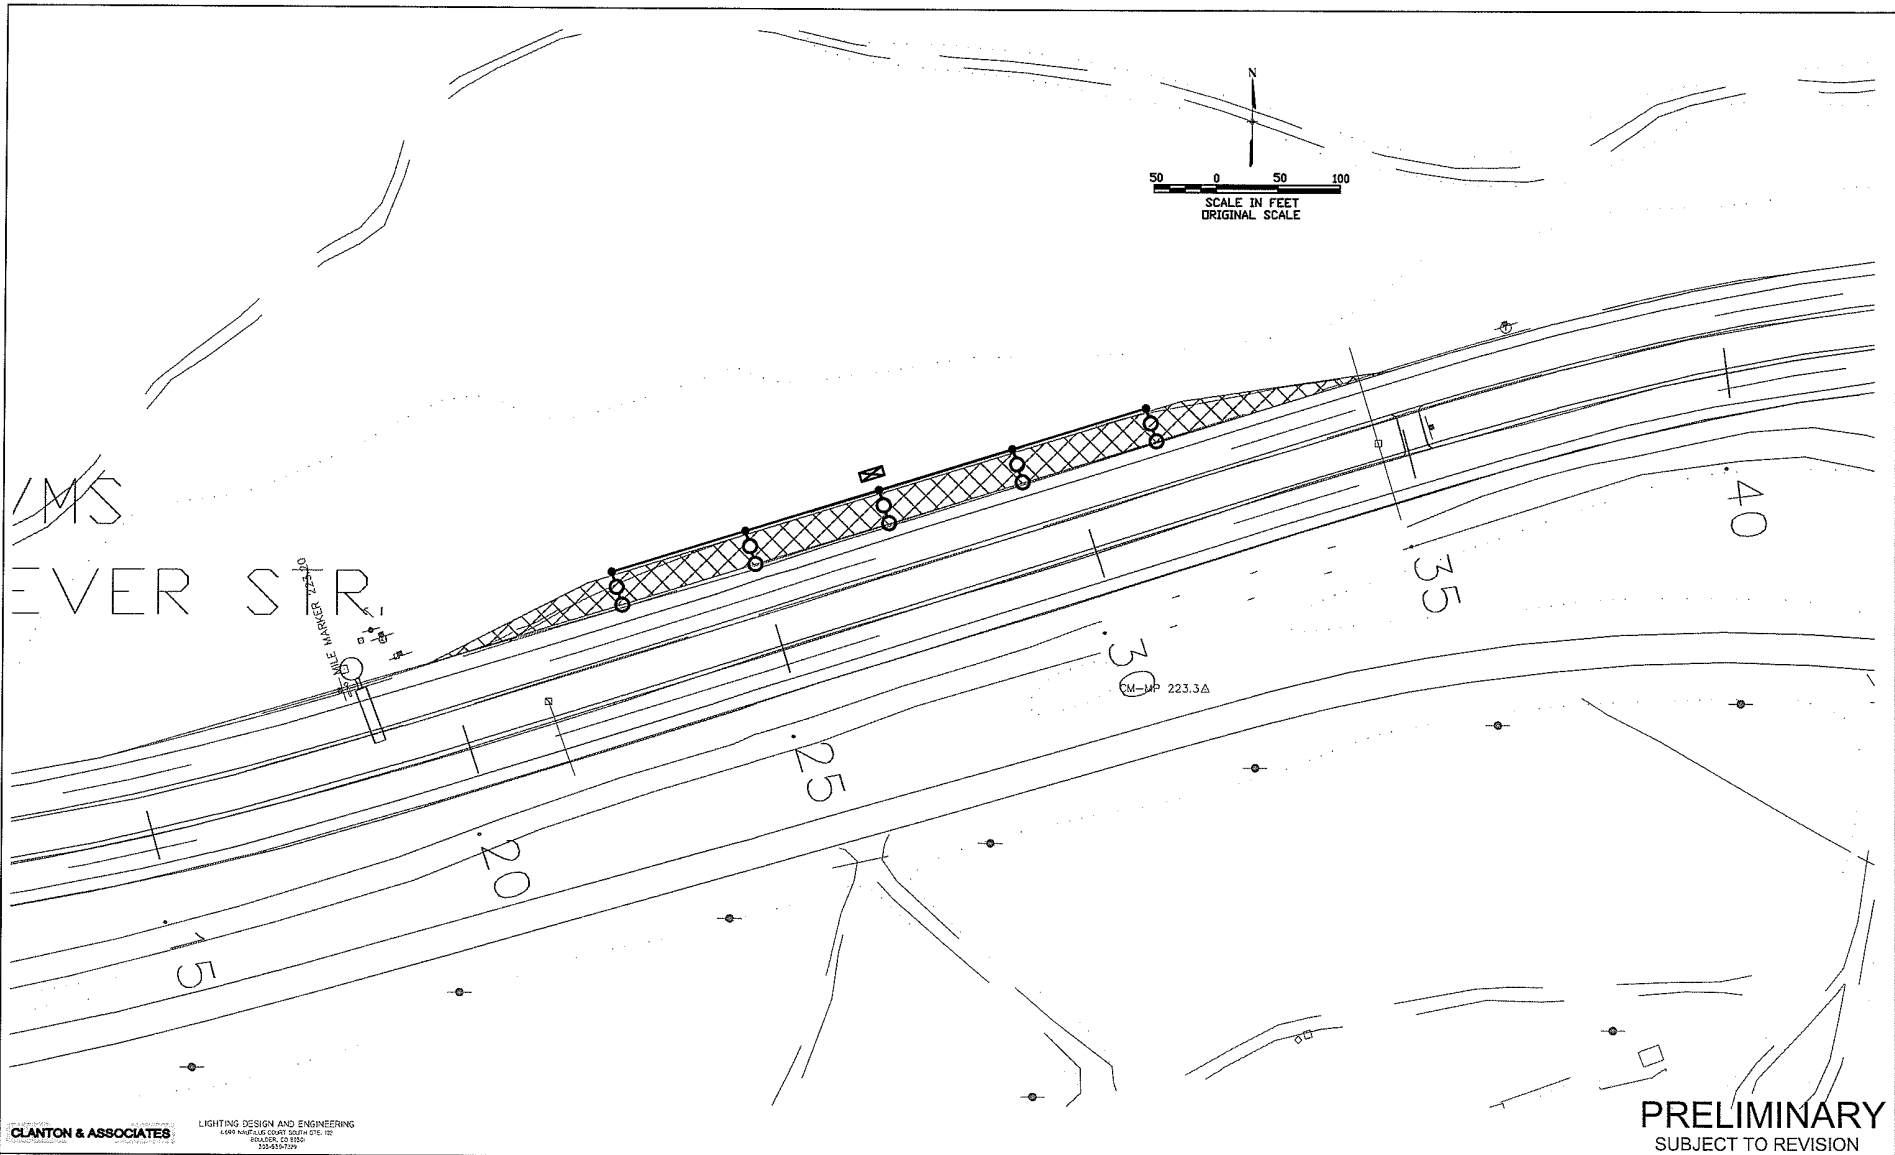

CLANTON & ASSOCIATES
 LIGHTING DESIGN AND ENGINEERING
 6000 RAMPAGE COURT SOUTH DTC, 102
 DENVER, CO 80237
 303-451-9799

Computer File Information	
Creation Date:	Initials: GF
Last Modification Date:	Initials: JE
Full Path: Z:\VAIL CHAIN STATIONS\CURRENT\	
Drawing File Name:	
Scale: REFER TO BAR SCALE	Units: ENGLISH

Index of Revisions	


 Region 1
 18500 East Colfax
 Aurora, CO 80011
 Phone: (303) 365-7340
 FAX: (303) 365-7343
 REGION I DW




 4601 DTC Blvd.
 Suite 700
 Denver, CO 80237
 Phone: (303) 221-7275
 Fax: (303) 221-7276

As Constructed
No. Revisions:
Revised:
Void:

LIGHTING PLAN - MP 223 PLAN & SWMP SITE MAP		
Designer:	GF	Structure
Detailer:	JE	Numbers
Sheet Subset:	LE	Subset Sheets: 18 OF 24

Project No./Code
IM 070A-003
16701
Sheet Number: 39

 MP 228
 ES

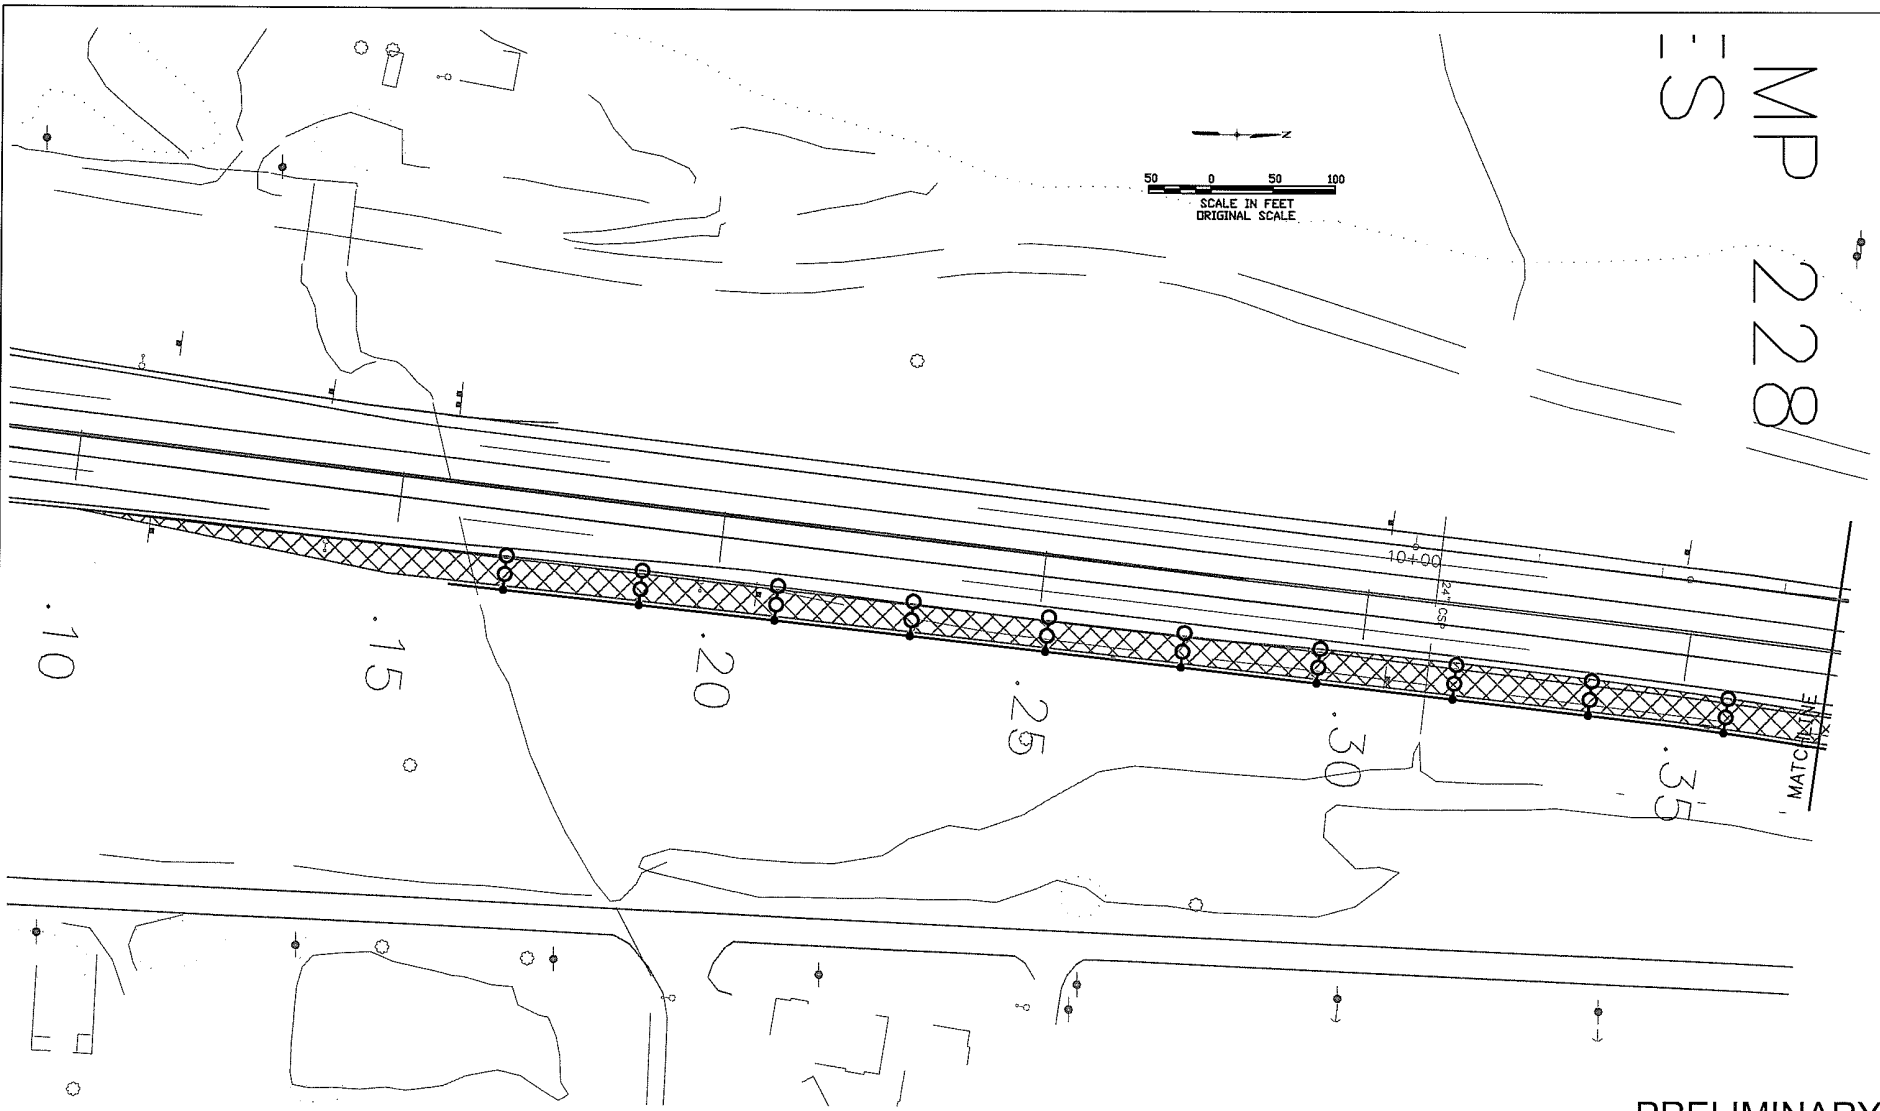

CLANTON & ASSOCIATES LIGHTING DESIGN AND ENGINEERING
 1899 SOUTH GLENVIEW COURT SUITE 102
 BOULDER, CO 80502
 303-440-7100

Computer File Information	
Creation Date:	Initials: GF
Last Modification Date:	Initials: JE
Full Path: Z:\VARL_CHAIN STATIONS\CURRNET\	
Drawing File Name:	
Scale: REFER TO BAR SCALE	Units: ENGLISH

Index of Revisions	

DOT
 REGION I
 DEPARTMENT OF TRANSPORTATION

Region 1
 18500 East Colfax
 Aurora, CO 80011
 Phone: (303) 365-7340
 FAX: (303) 365-7343

REGION I DW


PBSJ
 4601 DTC Blvd.
 Suite 700
 Denver, CO 80237
 Phone: (303) 221-7275
 Fax: (303) 221-7276

As Constructed	
No. Revisions:	
Revised:	
Void:	

LIGHTING PLAN - MP 228 PLAN & SWMP SITE MAP		
Designer:	GF	Structure
Detailer:	JE	Numbers
Sheet Subset:	LE	Subset Sheets:

Project No./Code	
IM 070A-003	
16701	
Sheet Number: 40	

PRELIMINARY
 SUBJECT TO REVISION

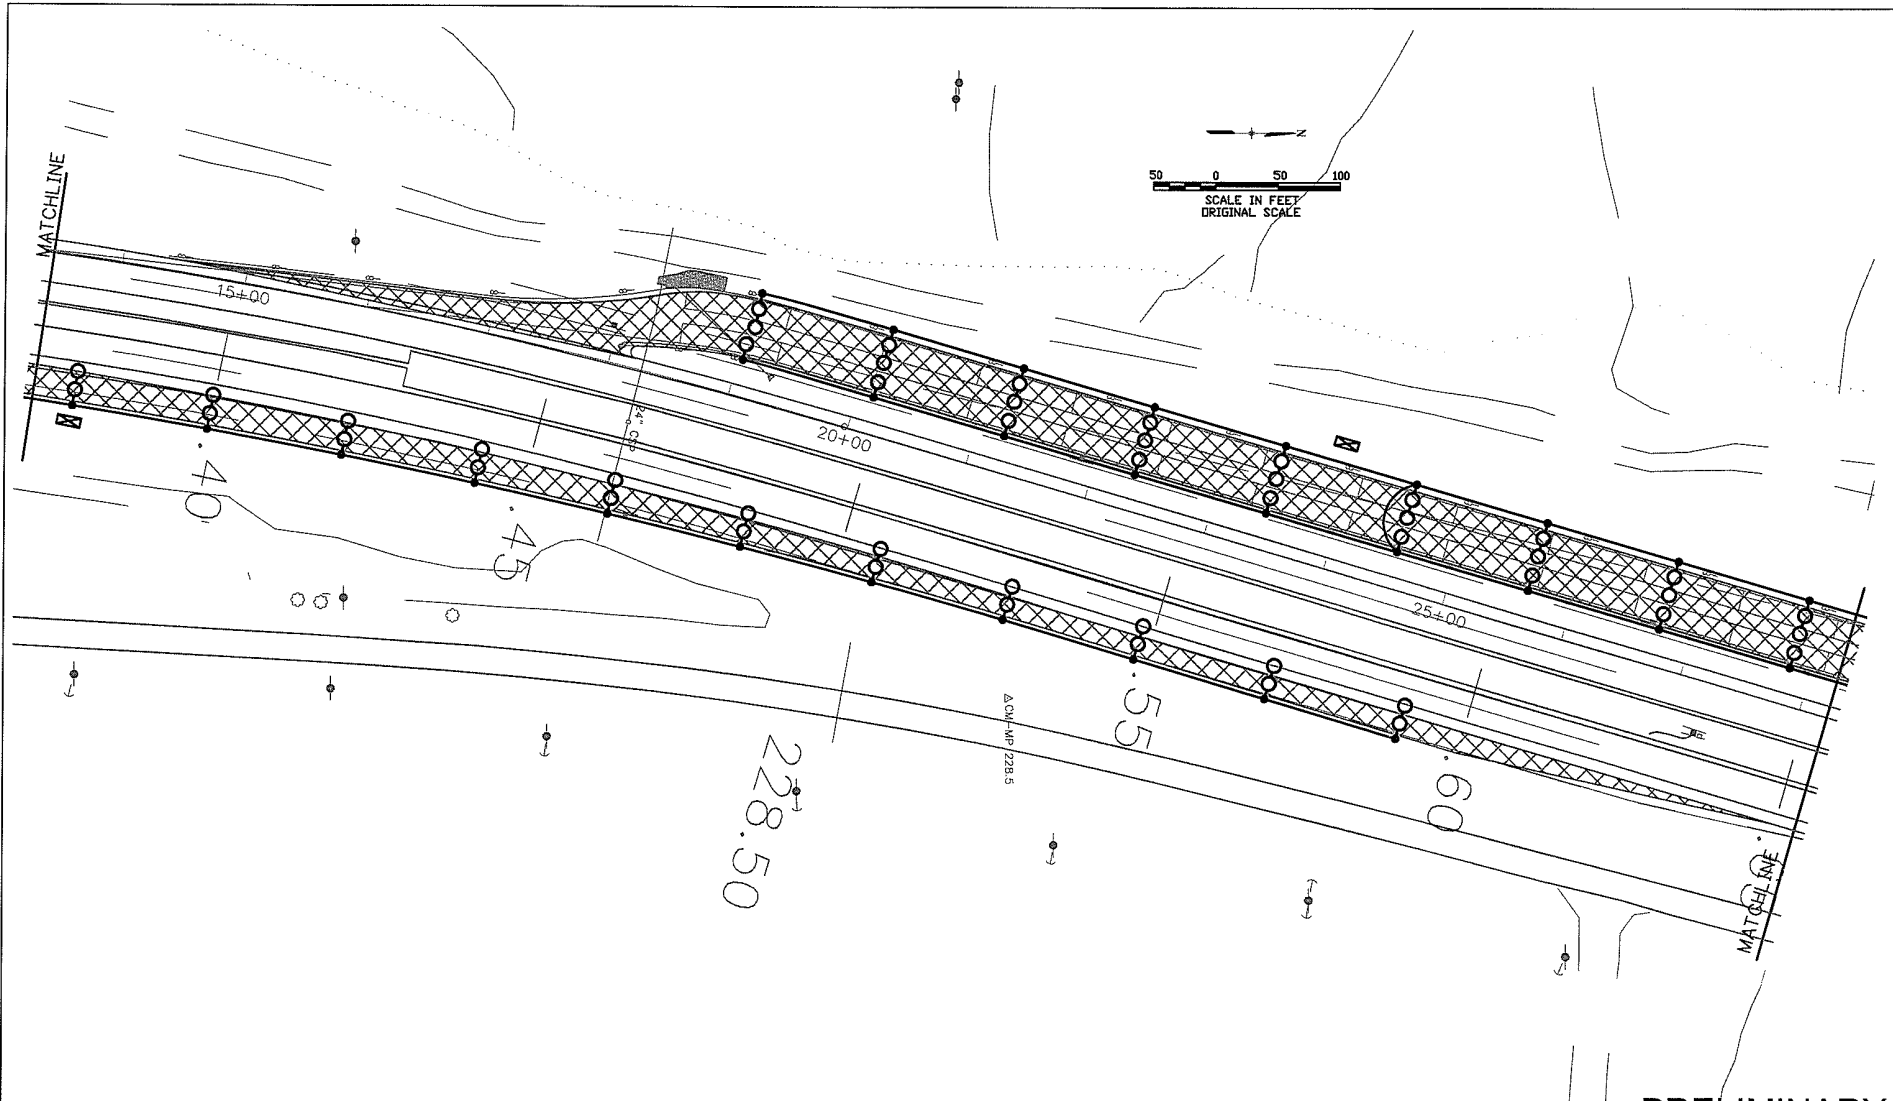

CLANTON & ASSOCIATES LIGHTING DESIGN AND ENGINEERING
 4609 NE 16th Ave., Suite 100, Denver, CO 80231
 Phone: (303) 365-7340 Fax: (303) 365-7343

Computer File Information	
Creation Date:	Initials: GF
Last Modification Date:	Initials: JE
Full Path: Z:\VAIL_CHAIN STATIONS\CURRNET\	
Drawing File Name:	
Scale: REFER TO BAR SCALE	Units: ENGLISH

Index of Revisions	



REGION I DW


Region 1
 18500 East Colfax
 Aurora, CO 80011
 Phone: (303) 365-7340
 FAX: (303) 365-7343



4601 DTC Blvd.
 Suite 700
 Denver, CO 80237
 Phone: (303) 221-7275
 Fax: (303) 221-7276

As Constructed		LIGHTING PLAN - MP 228 PLAN & SWMP SITE MAP		Project No./Code	
No. Revisions:		Designer:	GF	Structure	
Revised:		Detailer:	JE	Numbers	16701
Void:		Sheet Subset:	LE	Subset Sheets:	20 OF 24
					Sheet Number: 4/1

PRELIMINARY
 SUBJECT TO REVISION

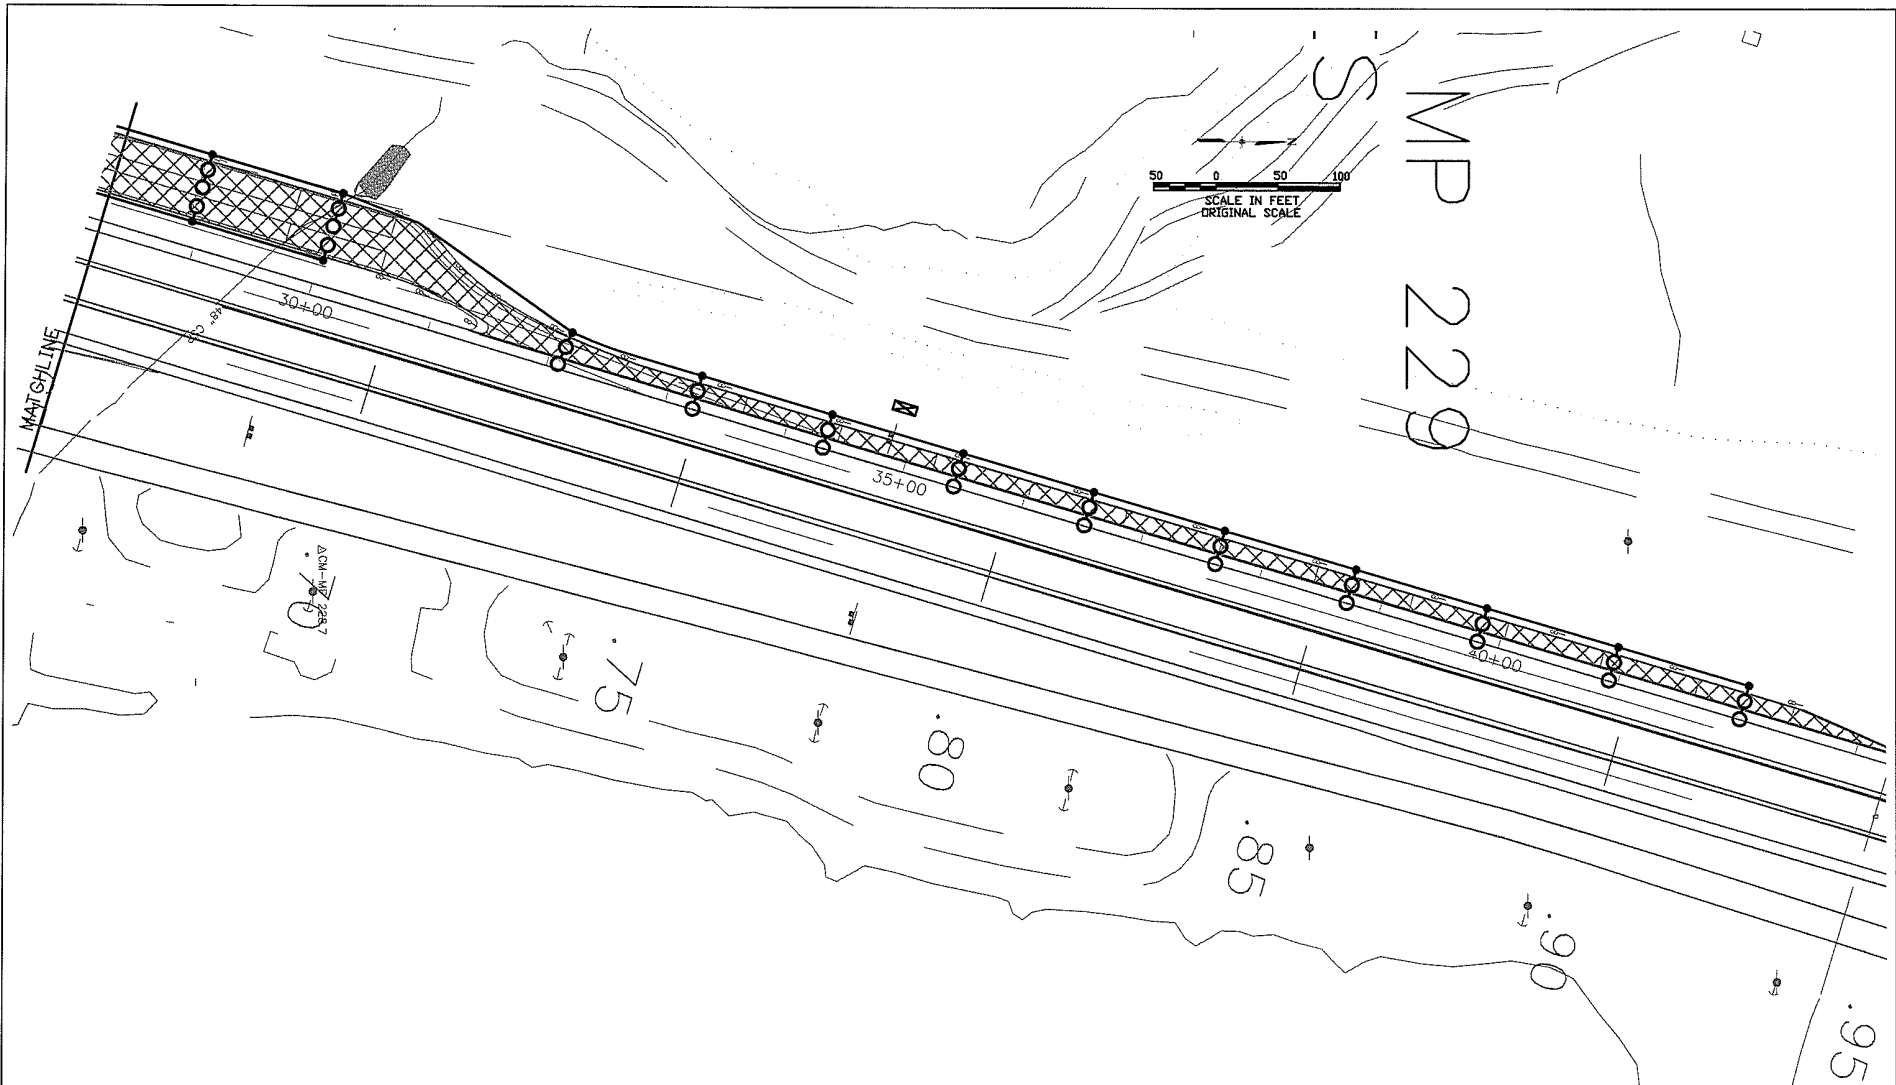

CLANTON & ASSOCIATES LIGHTING DESIGN AND ENGINEERING
 1699 ALPINE COURT SOUTH STE. 107
 BOULDER, CO 80502
 303-440-7029

Computer File Information	
Creation Date:	Initials: GF
Last Modification Date:	Initials: JE
Full Path: Z:\VAIL CHAIN STATIONS\CURRNET\	
Drawing File Name:	
Scale: REFER TO BAR SCALE	Units: ENGLISH

Index of Revisions	

DOT
 REGION I
 DEPARTMENT OF TRANSPORTATION

Region 1
 18500 East Colfax
 Aurora, CO 80011
 Phone: (303) 365-7340
 FAX: (303) 365-7343

REGION I DW


PBSJ
 4601 DTC Blvd.
 Suite 700
 Denver, CO 80237
 Phone: (303) 221-7275
 Fax: (303) 221-7276

As Constructed
No. Revisions:
Revised:
Void:

LIGHTING PLAN - MP 228 PLAN & SWMP SITE MAP	
Designer:	GF Structure
Detailer:	JE Numbers
Sheet Subset:	LE Subset Sheets: 21 OF 24

Project No./Code
IM 070A-003
16701
Sheet Number: 42

PRELIMINARY
 SUBJECT TO REVISION

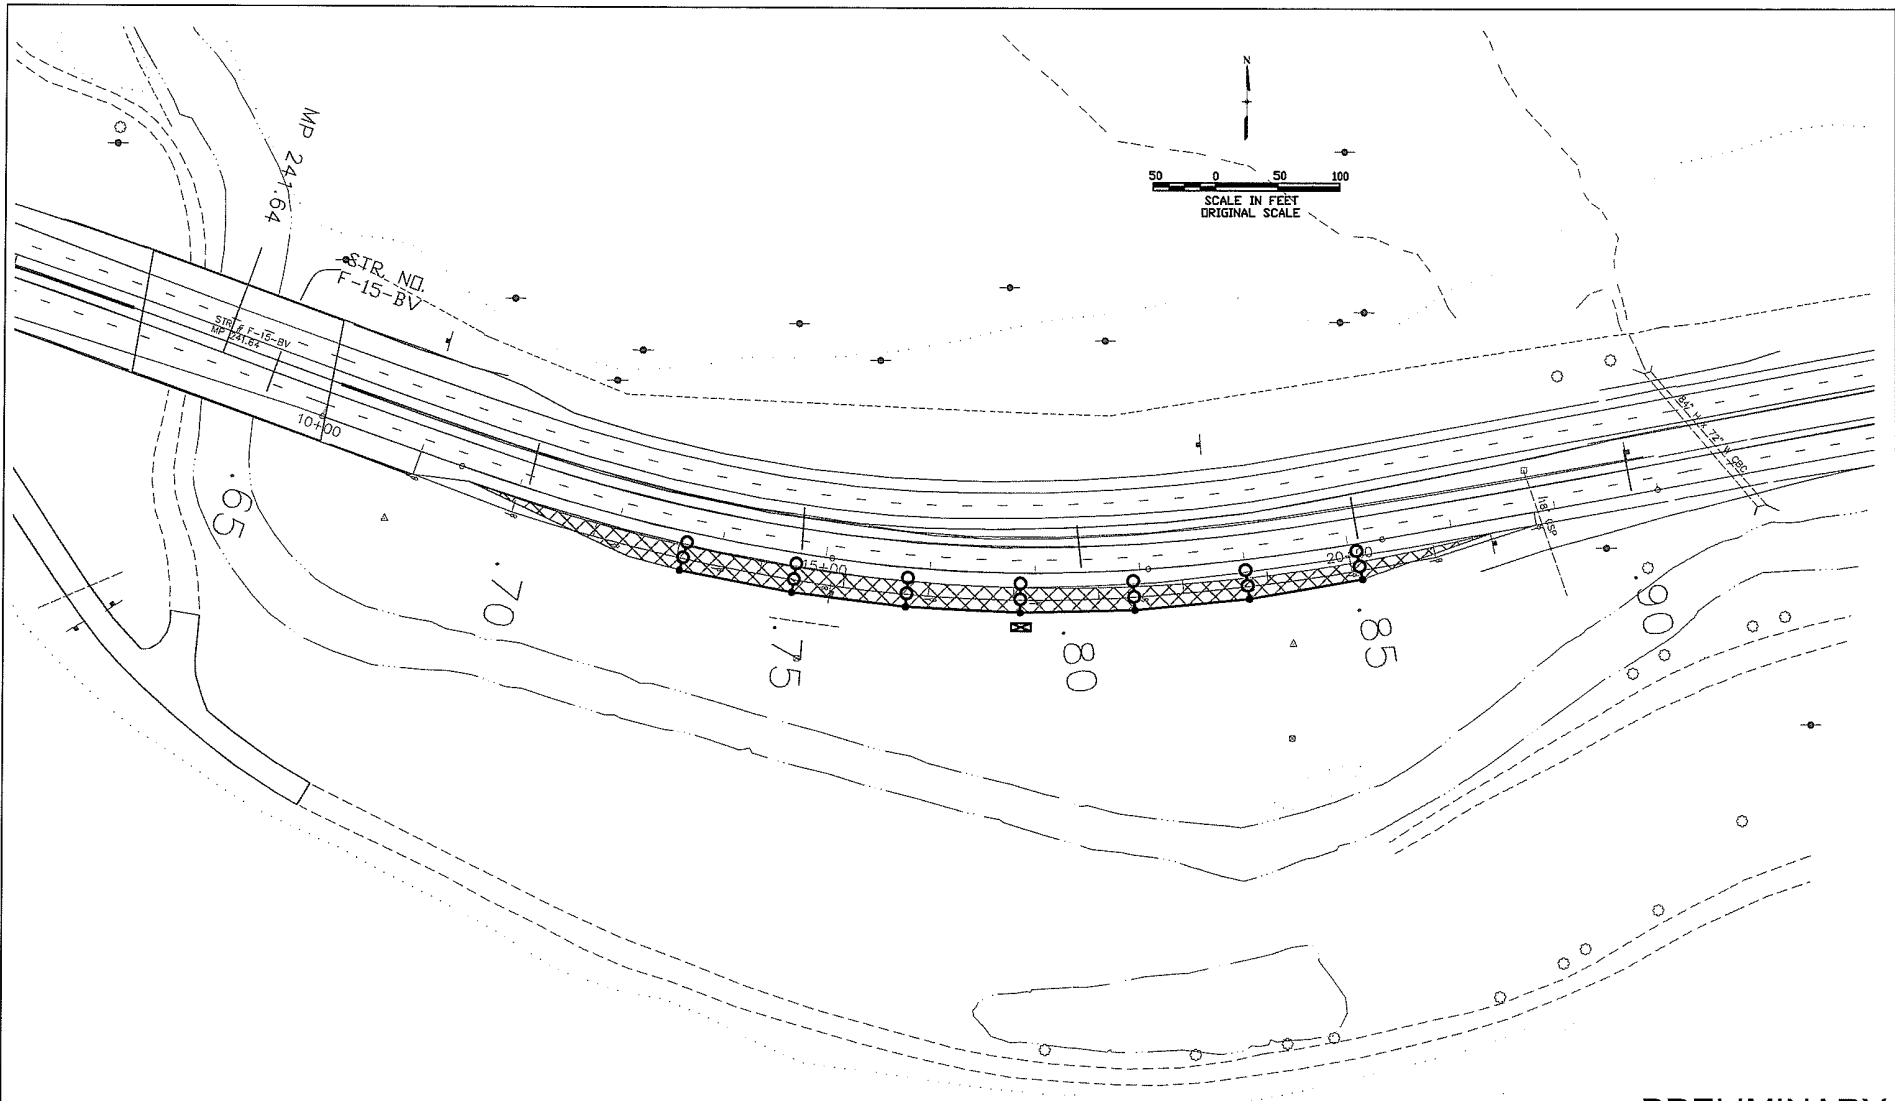

CLANTON & ASSOCIATES

LIGHTING DESIGN AND ENGINEERING
 1499 N. W. 12th Ave., Suite 102
 Fort Lauderdale, FL 33304
 Phone: (305) 555-7777
 Fax: (305) 555-7777

Computer File Information	
Creation Date:	Initials: GF
Last Modification Date:	Initials: JE
Full Path: Z:\VAIL CHAIN STATIONS\CURRNET\	
Drawing File Name:	
Scale: REFER TO BAR SCALE	Units: ENGLISH

Index of Revisions	

DOT
 DEPARTMENT OF TRANSPORTATION

Region 1
 18500 East Colfax
 Aurora, CO 80011
 Phone: (303) 365-7340
 FAX: (303) 365-7343

REGION I DW

PBSJ



4801 DTC Blvd.
 Suite 700
 Denver, CO 80237
 Phone: (303) 221-7275
 Fax: (303) 221-7276

As Constructed
No. Revisions:
Revised:
Void:

LIGHTING PLAN - MP 241 PLAN & SWMP SITE MAP		
Designer:	GF	Structure
Detailer:	JE	Numbers
Sheet Subset:	LE	Subset Sheets: 22 OF 24

Project No./Code
IM 070A-003
16701
Sheet Number: 43

PRELIMINARY
 SUBJECT TO REVISION

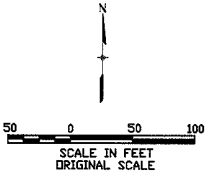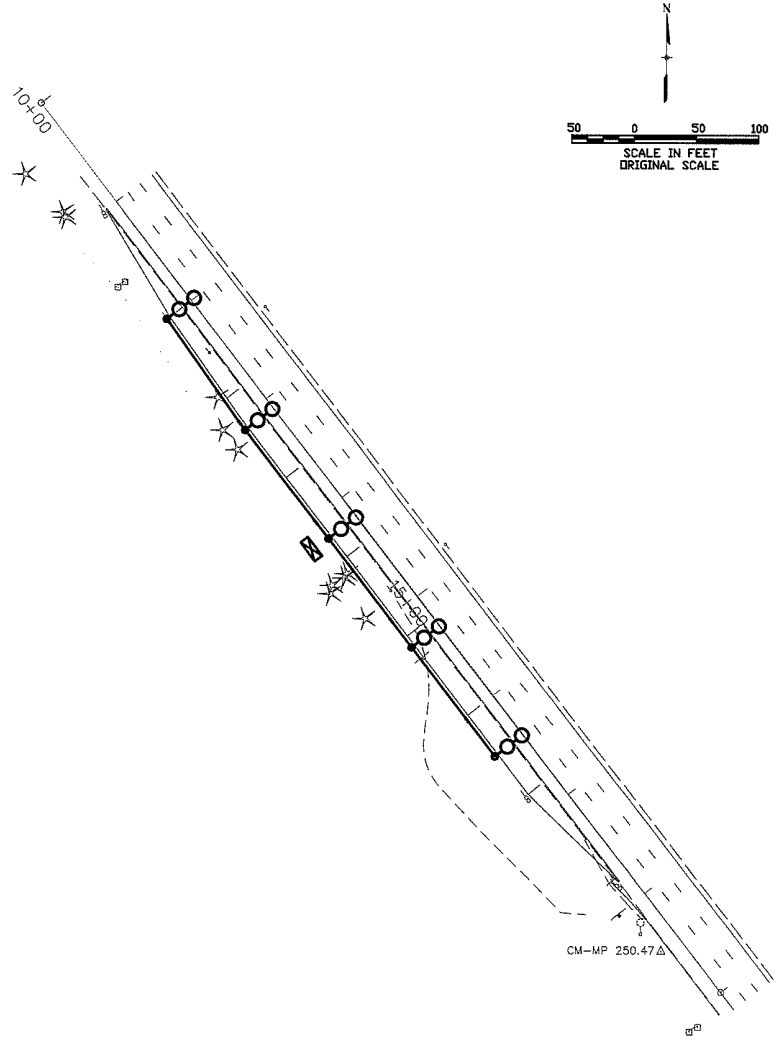

CLANTON & ASSOCIATES LIGHTING DESIGN AND ENGINEERING
 1699 N. J. BLVD. SUITE 200 DENVER, CO 80202
 (303) 733-7777

Computer File Information	
Creation Date:	Initials: GF
Last Modification Date:	Initials: JE
Full Path: Z:\VAL CHAIN STATIONS\CURRNET\	
Drawing File Name:	
Scale: REFER TO BAR SCALE	Units: ENGLISH

Index of Revisions	

DOT REGION I
 DEPARTMENT OF TRANSPORTATION
 Region 1
 18500 East Colfax
 Aurora, CO 80011
 Phone: (303) 365-7340
 FAX: (303) 365-7343

PBSJ
 4601 DTC Blvd.
 Suite 700
 Denver, CO 80237
 Phone: (303) 221-7275
 Fax: (303) 221-7276

As Constructed
No. Revisions:
Revised:
Void:

LIGHTING PLAN - MP 251 PLAN & SWMP SITE MAP		
Designer:	GF	Structure
Detailer:	JE	Numbers
Sheet Subset:	LE	Subset Sheets: 23 OF 24

Project No./Code
IM 070A-003
16701
Sheet Number: 44

PRELIMINARY
SUBJECT TO REVISION